



imited brand

LIMITED STORE PLANNING, INC.  
d/b/a STORE DESIGN & CONSTRUCTION

Three Limited Parkway • Columbus, Ohio 43230  
Telephone: 614.415.7000 • Fax: 614.415.7349

[illegible]

# CONGOL

**VICTORIA'S SECRET**

**VICTORIA'S  
PARK PLAZA MALL  
6000 W. MARKHAM STREET**

**REVISIONS:**


REQUIRED BY:	DATE
_____	_____
_____	_____
DATE ISSUED: 05/23/2016  
DESIGNED BY: BDI  
DRAWN BY: BDI  
CHECKED BY: DFC

# ELECTRICAL POWER & FIRE ALARM PLAN

DRAWING NUMBER:

E02.02

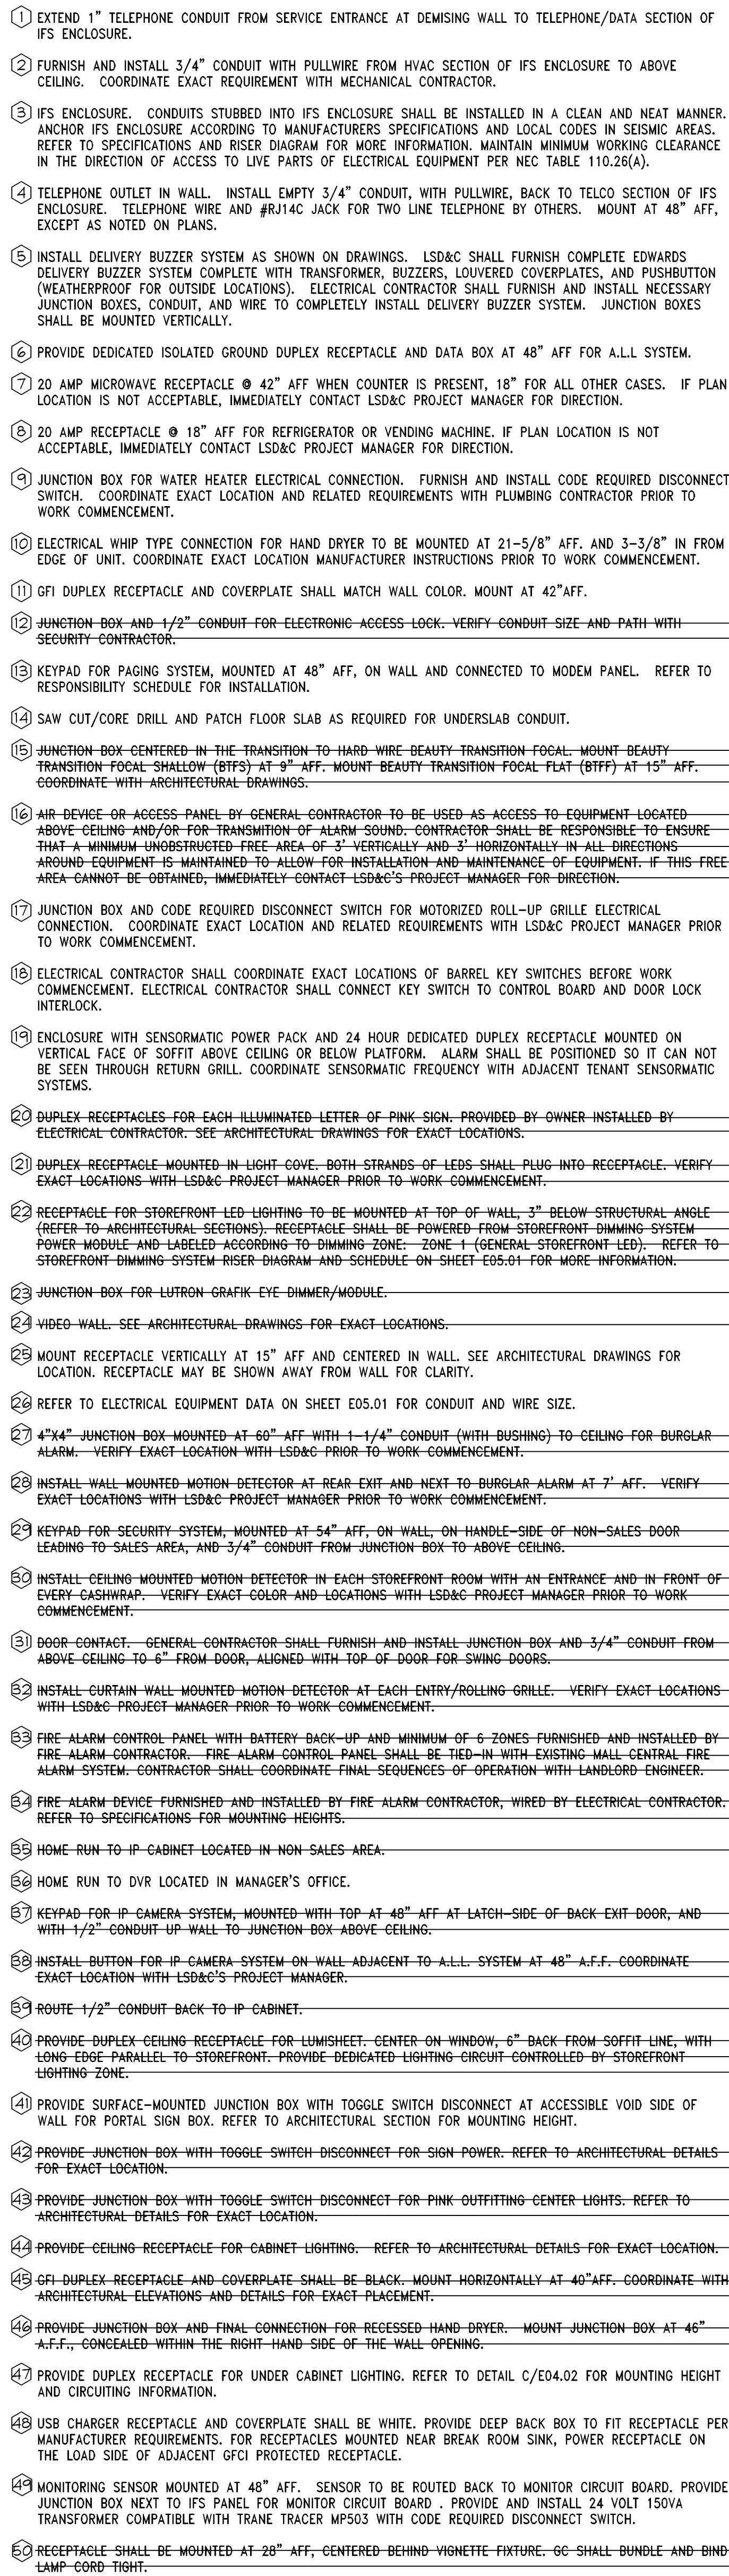

NTS	D
-	09/25/1

<b>1/4" = 1'-0"</b>	<b>A</b>

## ELECTRICAL POWER AND FIRE ALARM PLAN