

- ① ELECTRICAL CONTRACTOR SHALL INSTALL OCCUPANCY MOTION SENSOR SWITCH FOR CONTROL OF LIGHTS AS SHOWN. ELECTRICAL CONTRACTOR SHALL SET SWITCH FOR 15 MINUTES. MOUNT AT 44" AFF.
- ② BREAK-OFF CIRCUIT.
- ③ REFER TO SHEET E02.01 FOR VIEW MOUNT POWER REQUIREMENT. REFER TO ARCHITECTURAL RCP PLAN FOR CIRCUL EX-LOCATION.
- ④ ELECTRICAL CONTRACTOR SHALL FURNISH AND INSTALL 4" JUNCTION BOX FOR TIFFANY/POSTER BOXES. REFER TO ARCHITECTURAL DRAWINGS FOR MORE INFORMATION.
- ⑤ CONTRACTOR TO ROTATE FIXTURES SO THAT UL LABELS ARE NOT VISIBLE TO CUSTOMER.
- ⑥ ELECTRICAL CONTRACTOR SHALL FURNISH AND INSTALL 4" JUNCTION BOX FOR SHADOW BOXES. MOUNT JUNCTION BOX BELOW SHADOW BOX FOR CONNECTION TO TRANSFORMER. REFER TO ARCHITECTURAL DRAWINGS FOR MORE INFORMATION.
- ⑦ PROVIDE JUNCTION BOX FOR BLADE SIGN MOUNTED ON INTERIOR OF STORE, ACCESSIBLE ABOVE CEILING.
- ⑧ FURNISH AND INSTALL JUNCTION BOX, TOGGLE DISCONNECT SWITCH IN NON-VISIBLE LOCATION, AND FINAL CONNECTION FOR 120 VOLT SIGN. SIGN IS FURNISHED WITH INTERNAL GROUND FAULT PROTECTION BY SIGN MANUFACTURER PER I.E.C. ARTICLE 600-23b. VERIFY EXACT LOCATION OF JUNCTION BOX WITH SIGN MANUFACTURER. (REUSE EXISTING JUNCTION BOX AND CONDUIT INTO SPACE IF ALREADY INSTALLED. VERIFY IN FIELD EXACT LOCATION ON CANOPY). FOR CANOPY POWER SEE SHEET A08.01 FOR WALL PENETRATION IN ROUTING CONDUIT.
- NOTE:
THESE
CIRCUIT FOR SIGNAGE MUST BE A DEDICATED ISOLATED 3-LINE CIRCUIT CONSISTING OF HOT, NEUTRAL, AND GROUND WIRES LEADING DIRECTLY TO THE PANEL.
- ⑨ LIGHT FIXTURES TO BE INSTALLED IN MILLWORK FIXTURE, NOT IN CEILING, VERIFY WITH LSD&C. REFER TO SHEET E02.01 FOR POWER REQUIREMENTS.
- ⑩ "AA" LIGHTS ARE REMODEL HOUSING AND DO NOT INSTALL DURING ROUGH FRAMING.

NTS

0301-D00-NOTE

D

Limited brands

LIMITED STORE PLANNING, INC.
d/b/a STORE DESIGN & CONSTRUCTION
 Three Limited Parkway • Columbus, Ohio 43230
 Telephone: 614.415.7000 • Fax: 614.415.7349

[illegible]

PROJECT INFORMATION:

BATH & BODY WORKS
MEMORIAL CITY MALL
303 MEMORIAL CITY WAY
SUITE 733
HOUSTON, TX 77024

SCOPE: RELO DWN / NEW PACKAGE:
DESIGN TYPE: EASTON—G
GENERATION: 14150


REVISIONS:

REVISION NO.	DATE	BY	DESCRIPTION
1	04/11/2011	PF	DATE ISSUED:
2		PF	DESIGNED BY:
3		PF	DRAWN BY:
4		TW	CHECKED BY:

ELITE CONSTRUCTION GROUP
LAKE JACKSON, TX
PHONE: 979-285-0712
NOTE: THESE PRINTS HAVE BEEN
REDUCED BY 50 PERCENT SCALE
WILL BE 50 PERCENT OF WHAT IS
NOTED ON PLANS

ELECTRICAL LIGHTING PLAN

DRAWING NUMBER:
E03.01

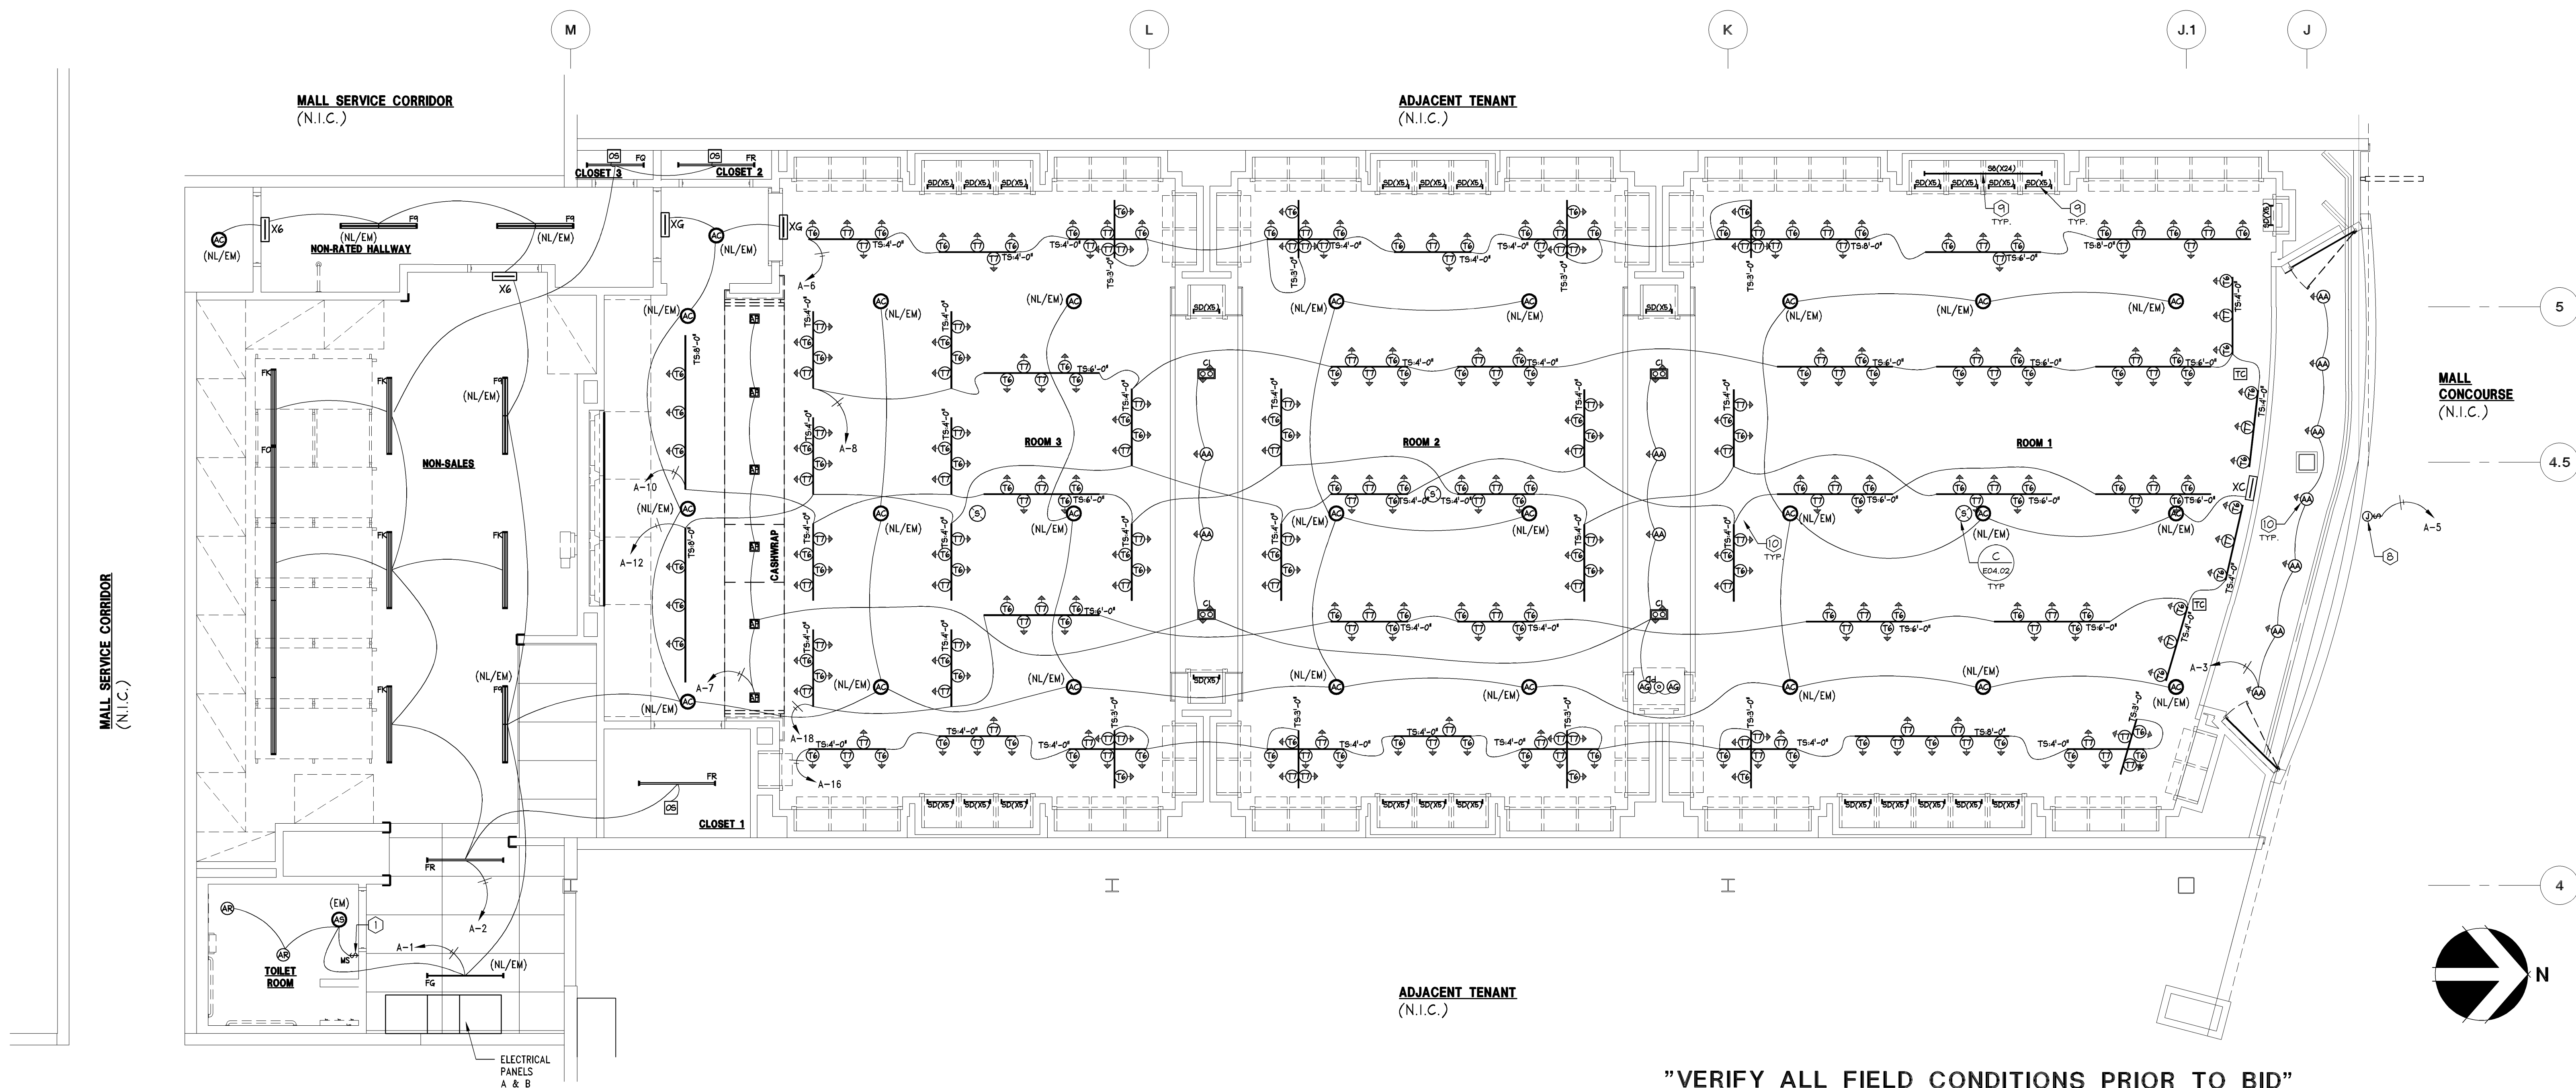

"VERIFY ALL FIELD CONDITIONS PRIOR TO BID"

1/4" = 1'-0"

A