

Limited brands

LIMITED STORE PLANNING, INC.
d/b/a STORE DESIGN & CONSTRUCTION
Three Limited Parkway • Columbus, Ohio 43230
Telephone: 614.415.7000 • Fax: 614.415.7349

[illegible]

BATH & BODY WORKS

MEMORIAL CITY MALL
303 MEMORIAL CITY WAY
SUITE 733
HOUSTON, TX 77024

PROJECT INFORMATION:

SCOPE: RELO DWN / NEW PACKAGE:
DESIGN TYPE: EASTON G
TOOPOGRAPHY: 14150

REVISIONS:

REQUIRED BY:	DATE:

ELITE CONSTRUCTION GROUP
LAKE JACKSON, TX
PHONE: 979-285-0712
NOTE: THESE PRINTS HAVE BEEN
REDUCED BY 50 PERCENT. SCALE
WILL BE 50 PERCENT OF WHAT IS
NOTED ON PLANS

DATE ISSUED: 04/11/201
DESIGNED BY: JO
DRAWN BY: JO
CHECKED BY: JMU

MECHANICAL DETAILS

DRAWING NUMBER:
M03.01



NTS



D
09/13/13



1" = 1'-0"




C
09/13/13



NTS



B
09/13/13

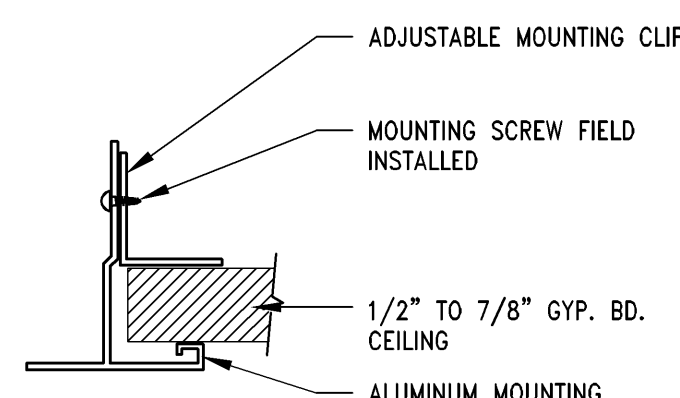

DRYWALL CEILING DIFFUSER MOUNTING FRAME DETAIL

" = 1'-0"



A
09/13/13