



SYMBOL	DESCRIPTION
	RECESSED DOWNLIGHT
	TRACK W/ TRACK HEADS
	FLUORESCENT STRIPS - SURFACE MOUNTED
	FLUORESCENT STRIPS - CHAIN-HUNG FROM STRUCTURE 12'-0" A.F.F.
	MULTI-LAMP RECESSED DOWNLIGHT
	SURFACE MOUNTED FLUORESCENT LIGHT W/ ACRYLIC LENS
	EGRESS SIGNAGE
	EMERGENCY LIGHT
	SPEAKER
	SUPPLY DIFFUSER
	RETURN AIR GRILLE
	CEILING ACCESS PANEL
	EXHAUST AIR REGISTER
	MARKETING RAIL
	PENDANT LIGHT - MOUNTED 7'-6" A.F.F.
	BILLBOARD LIGHT
	CCTV VIEWING MONITOR
	CCTV CAMERA - SUPPLIED AND INSTALLED BY SECURITY VENDOR
	TRAFFIC COUNTER
	SCENT AIR

- NOTES:
1. ALL CEILING HEIGHTS ARE FROM THE TOP OF FINISH FLOOR TO UNDERSIDE OF FINISH CEILING.
 2. PROVIDE ADEQUATE CLEARANCES FOR FIXTURES, DUCTS, CEILINGS, AND RELATED PERTINENT ITEMS NECESSARY TO MAINTAIN THE SPECIFIED HEIGHTS ABOVE FINISH FLOOR.
 3. ADDITIONAL HANGER AND SAFETY WIRES FOR LIGHT FIXTURES, SPEAKERS AND DUCTWORK, AS REQUIRED BY LOCAL CODES, TO BE THE RESPONSIBILITY OF THE CEILING SUBCONTRACTOR.
 4. SPRINKLER HEAD LAYOUT TO CONFORM TO LOCAL CODE, TAKING IN ACCOUNT LOCATIONS OF DUCTWORK, LIGHTING AND LOCATION OF TENANT'S CABINET, FIXTURE AND SHELVING UNITS.
 5. ARCHITECTURAL DRAWINGS DETERMINE LOCATION OF LUMINAIRES AND SUPERSEDE ALL OTHERS, U.O.N.
 6. AFTER INSTALLATION, ELECTRICAL CONTRACTOR IS TO TILT THE LAMP IN ALL "T" FIXTURES @ A 45 DEGREE ANGLE TOWARD WALL OR CABINETS.
 7. SEE LIGHT FIXTURE SCHEDULE ON ELECTRICAL DRAWINGS FOR FIXTURE MODEL NUMBERS KEYED TO THE LIGHTING AND CEILING LEGEND.
 8. NO EMERGENCY LIGHTS, EXIT LIGHTS OR SENSORS ARE TO BE PLACED ON THE PERIMETER SALES WALLS.


CEILING AND LIGHTING LEGEND	1/4" = 1'-0"	R
	42L-A041-L01-LGMD	04.26.10

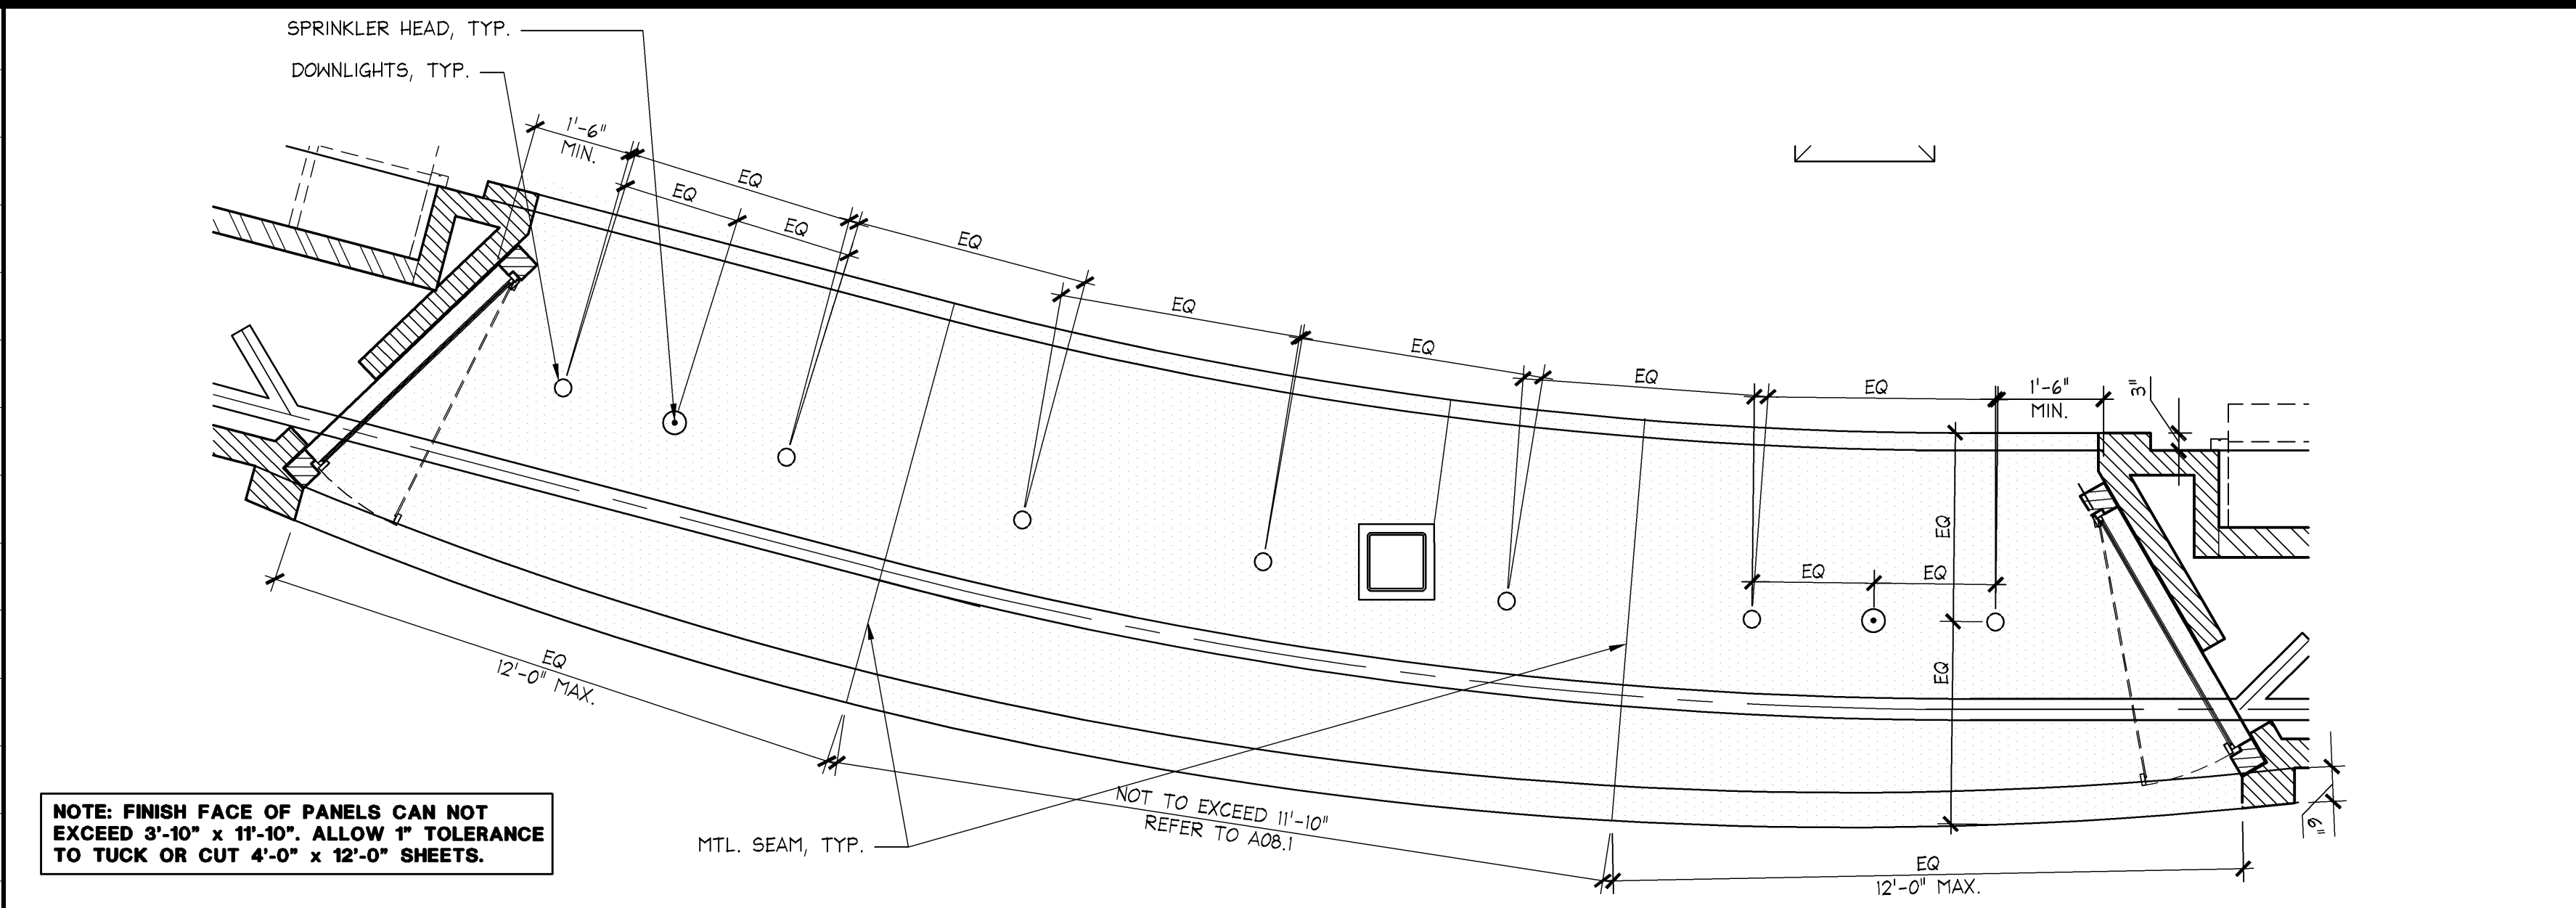

METAL SEAMS @ CANOPY CEILING	1/2" = 1'-0"	H
	42D-A041-C01-DETL	11.18.10

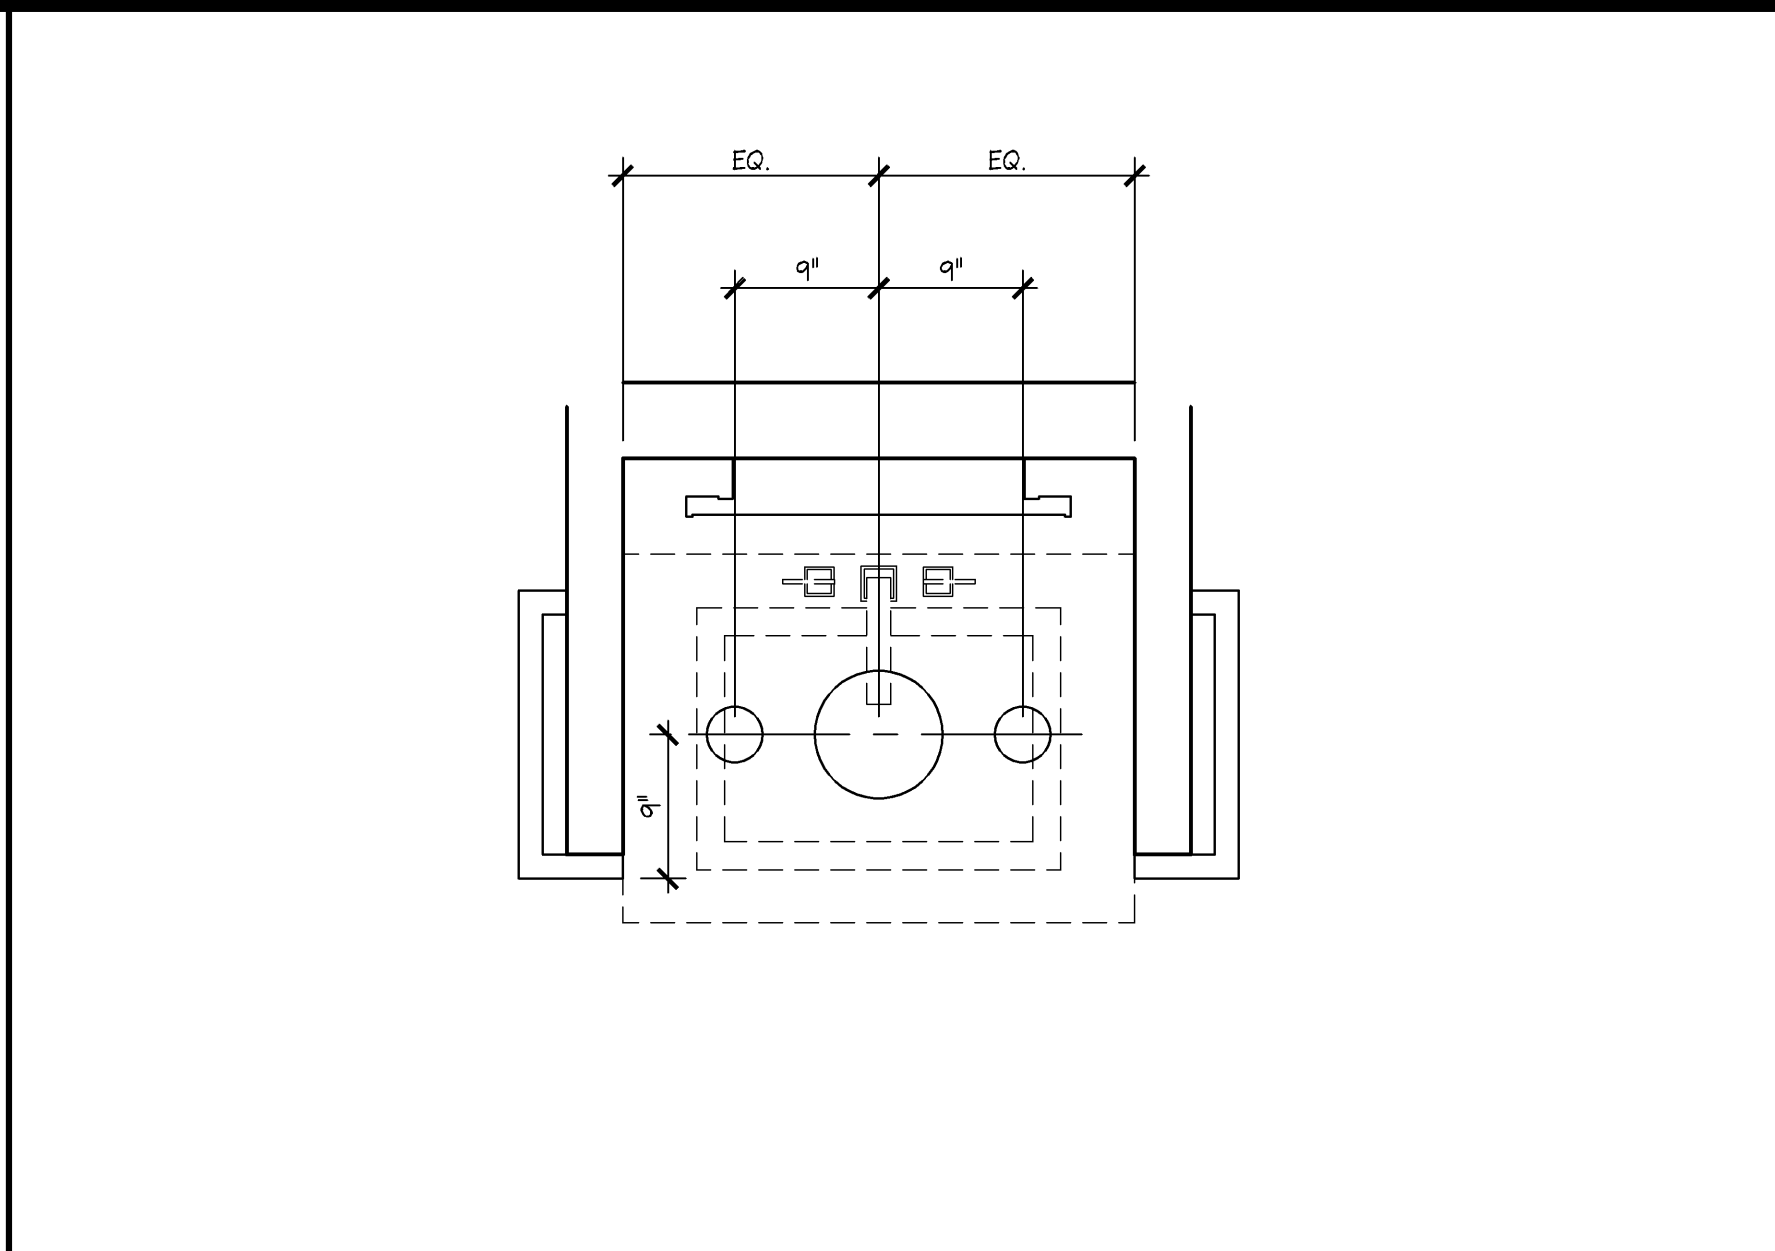

ENLARGED RCP AT ARCHITECTURAL NARROW DEMO SINK	1" = 1'-0"	D
	42D-A041-D01-DETL	03.16.12

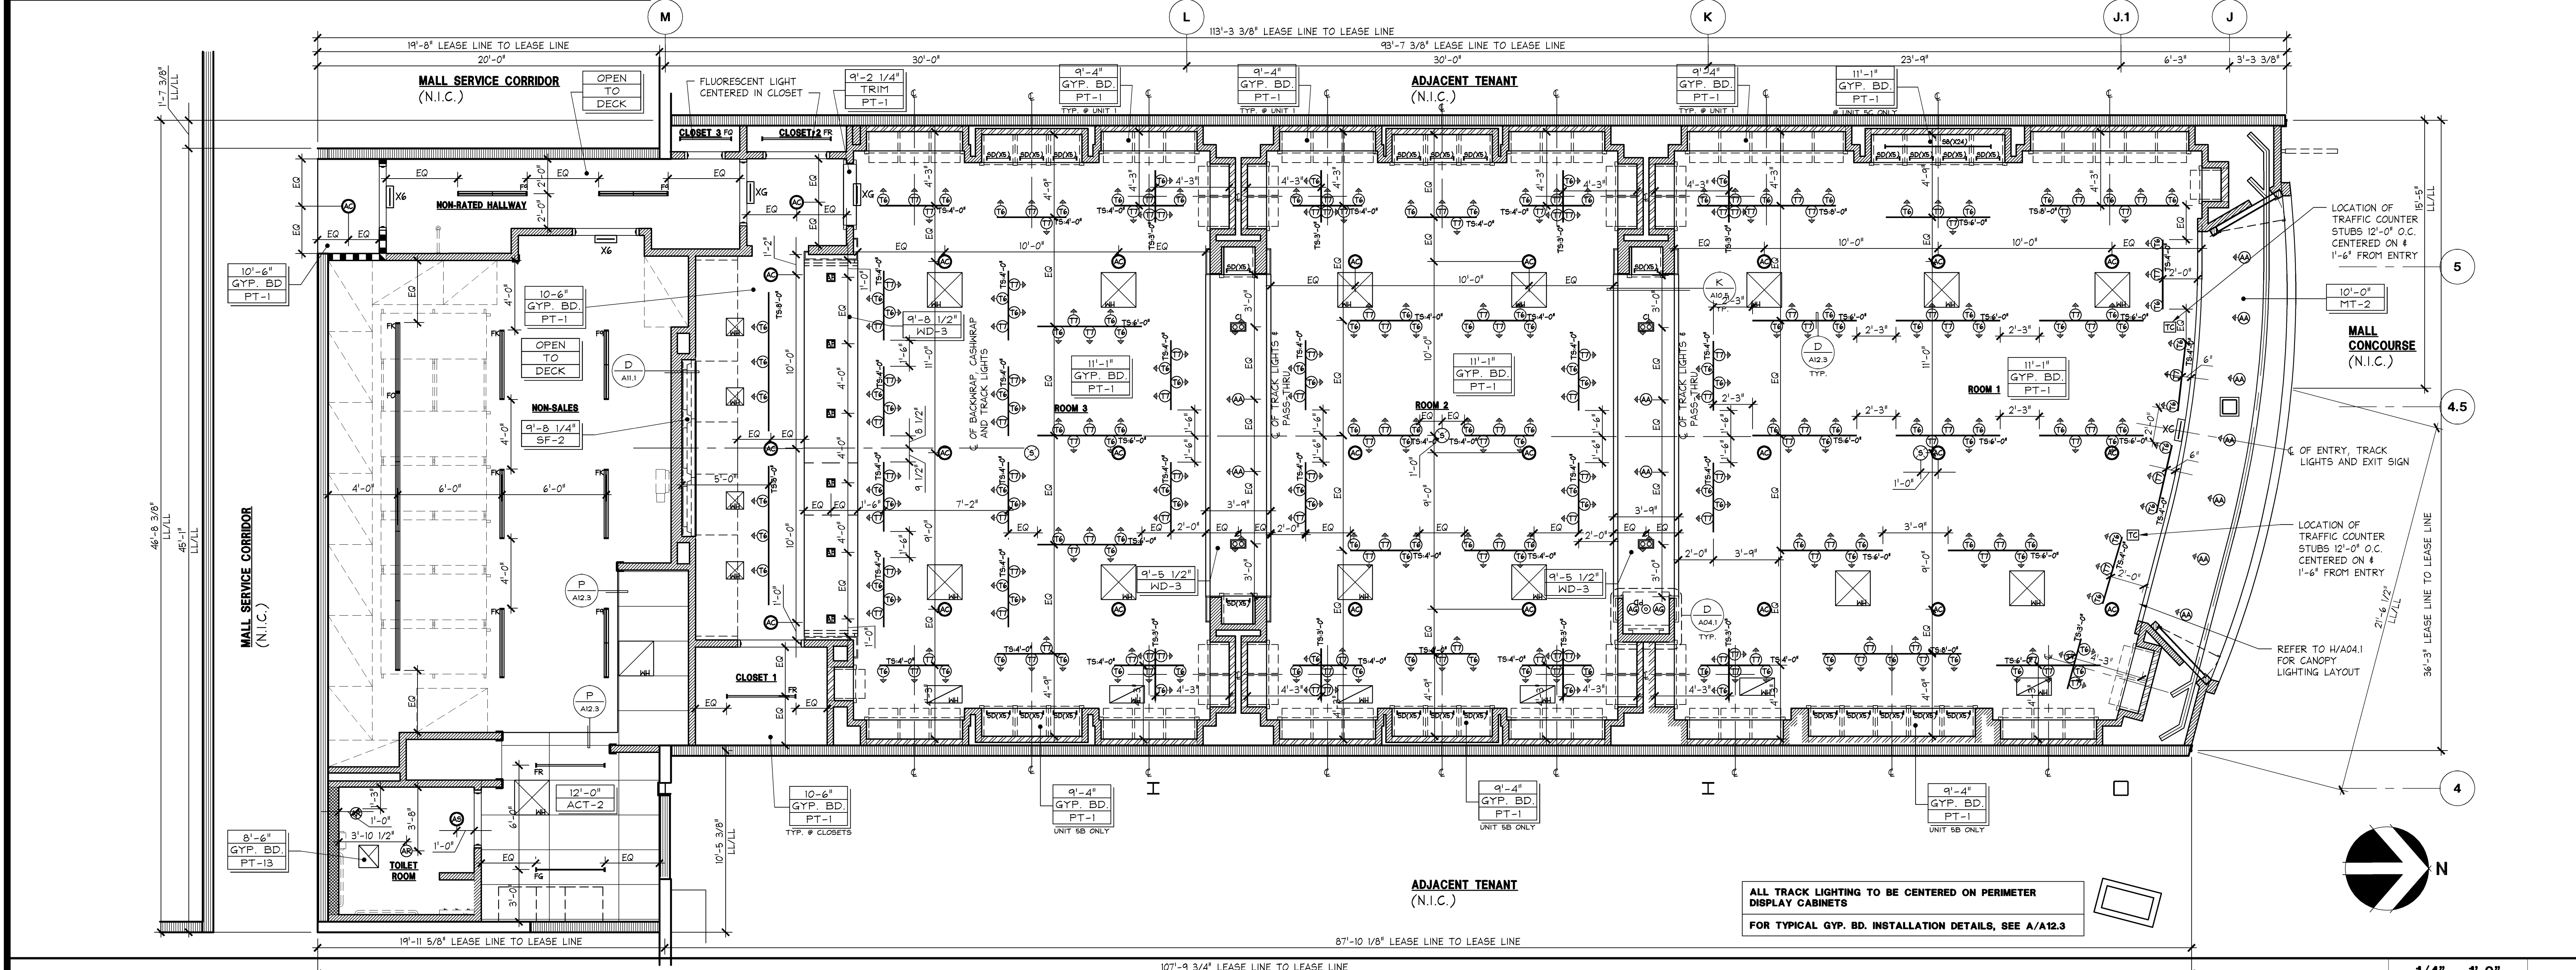

REFLECTED CEILING PLAN	1/4" = 1'-0"	A
	42P-A041-A01-PLAN	03.09.11

MOODY-NOLAN
responsive architecture
300 Spruce Street Suite 300
Columbus, Ohio 43215
Phone: (614) 461-4664
Fax: (614) 280-8881
www.moodynolan.com

Limited brands
LIMITED STORE PLANNING, INC.
d/b/a STORE DESIGN & CONSTRUCTION
Three Limited Parkway • Columbus, Ohio 43230
Telephone: 614.415.7000 • Fax: 614.415.7349

PROJECT INFORMATION:
024200396
BATH & BODY WORKS
MEMORIAL CITY MALL
303 MEMORIAL CITY WAY
HOUSTON, TX 77024
RELO DOWN / NEW PACKAGE:
EASTON-G GENERATION:
60685 A/E PROJECT #:

REVISIONS:
REQUIRED BY: DATE:
ELITE CONSTRUCTION GROUP
LAKE JACKSON, TX
PHONE: 979-285-0712
NOTE: THESE PRINTS HAVE BEEN
REWORKED BY 50 PERCENT SCALE
WILL BE 50 PERCENT OF WHAT IS
NOTED ON PLANS.

DATE ISSUED: 04/11/2014
DESIGNED BY: SF
DRAWN BY: TSG
CHECKED BY: TBD

REFLECTED CEILING PLAN

DRAWING NUMBER:
A04.1