




**GAS PIPING SUPPORT DETAIL** 1" = 1'-0" S 00D-P0301-S00-GPSP 09/03/2015

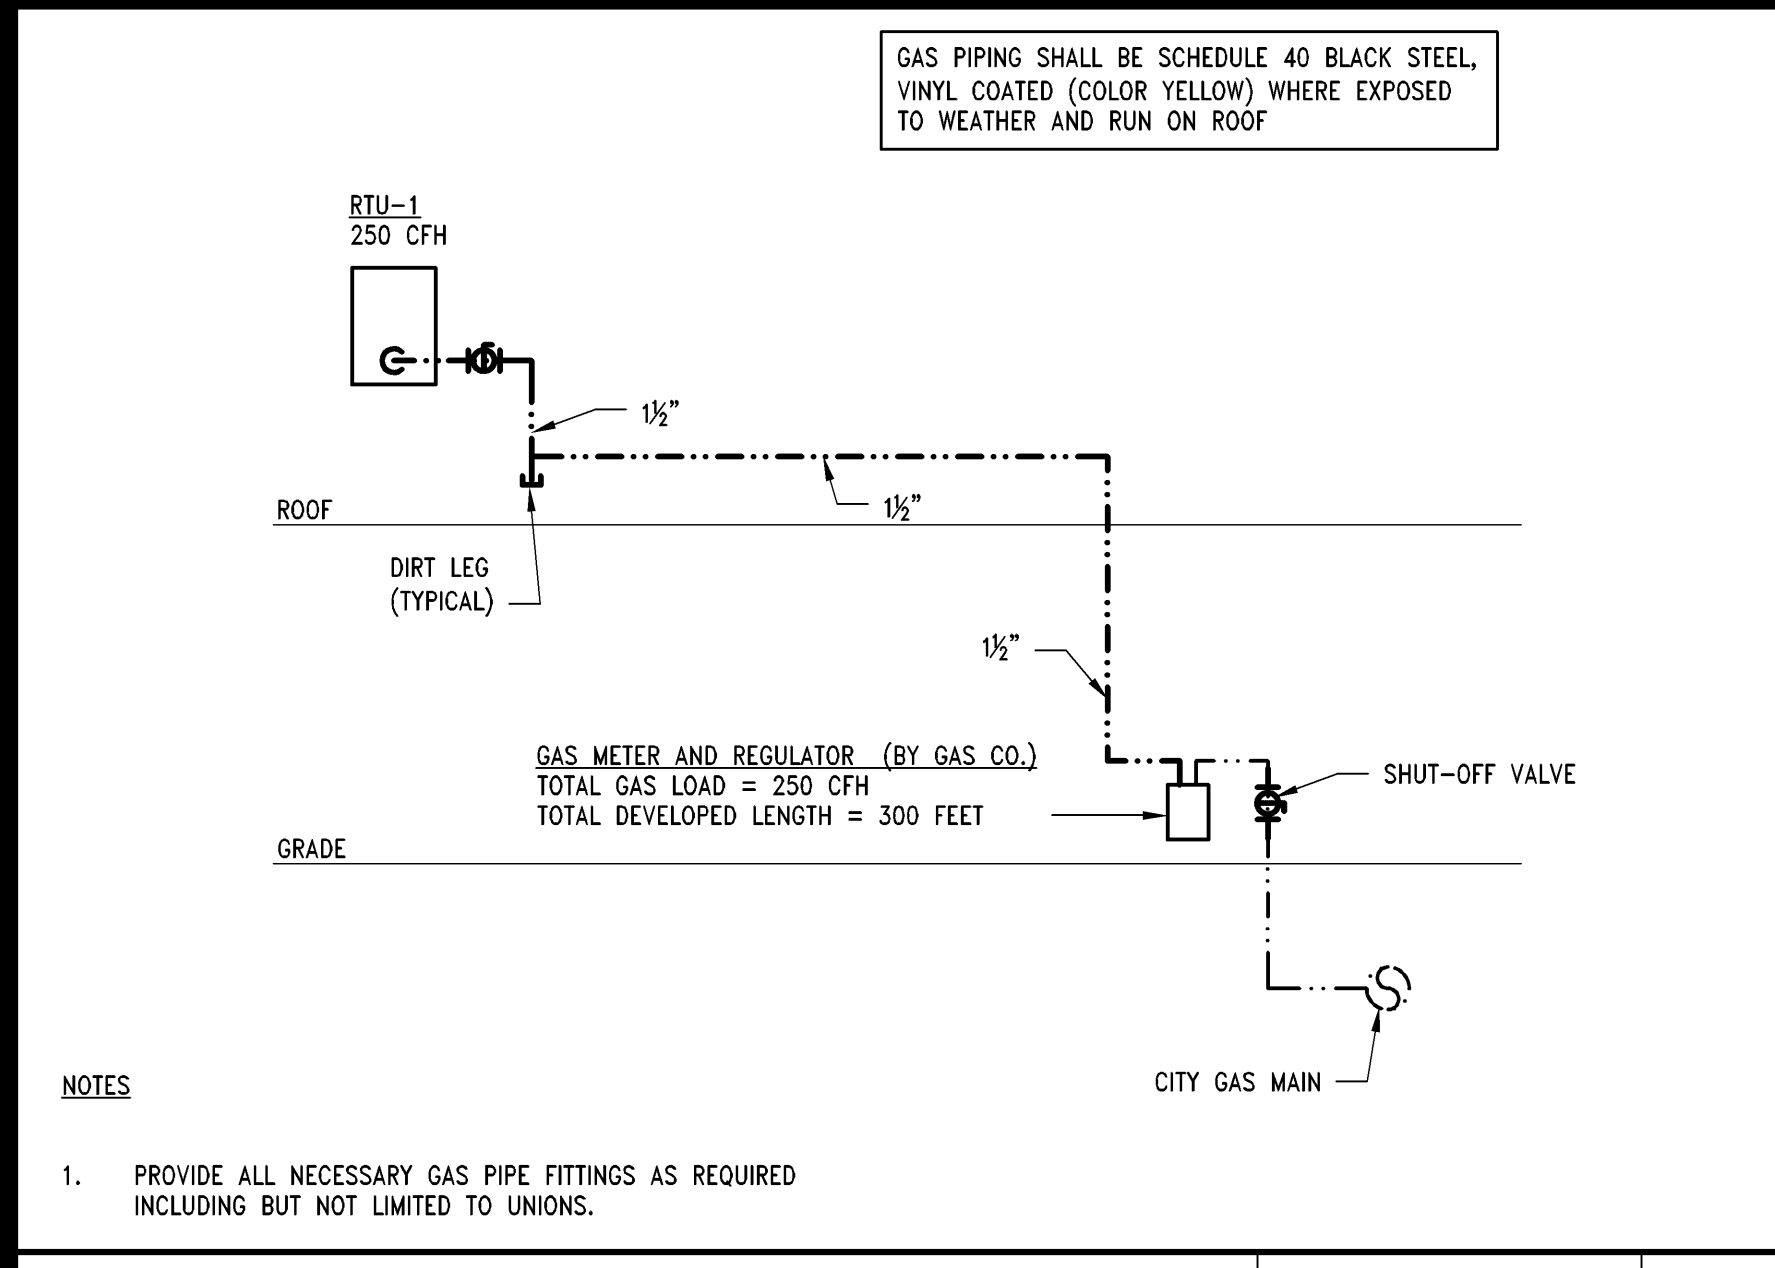


**GAS PIPING DIAGRAM** NTS 00D-P0301-M00-GSPD 09/03/2015

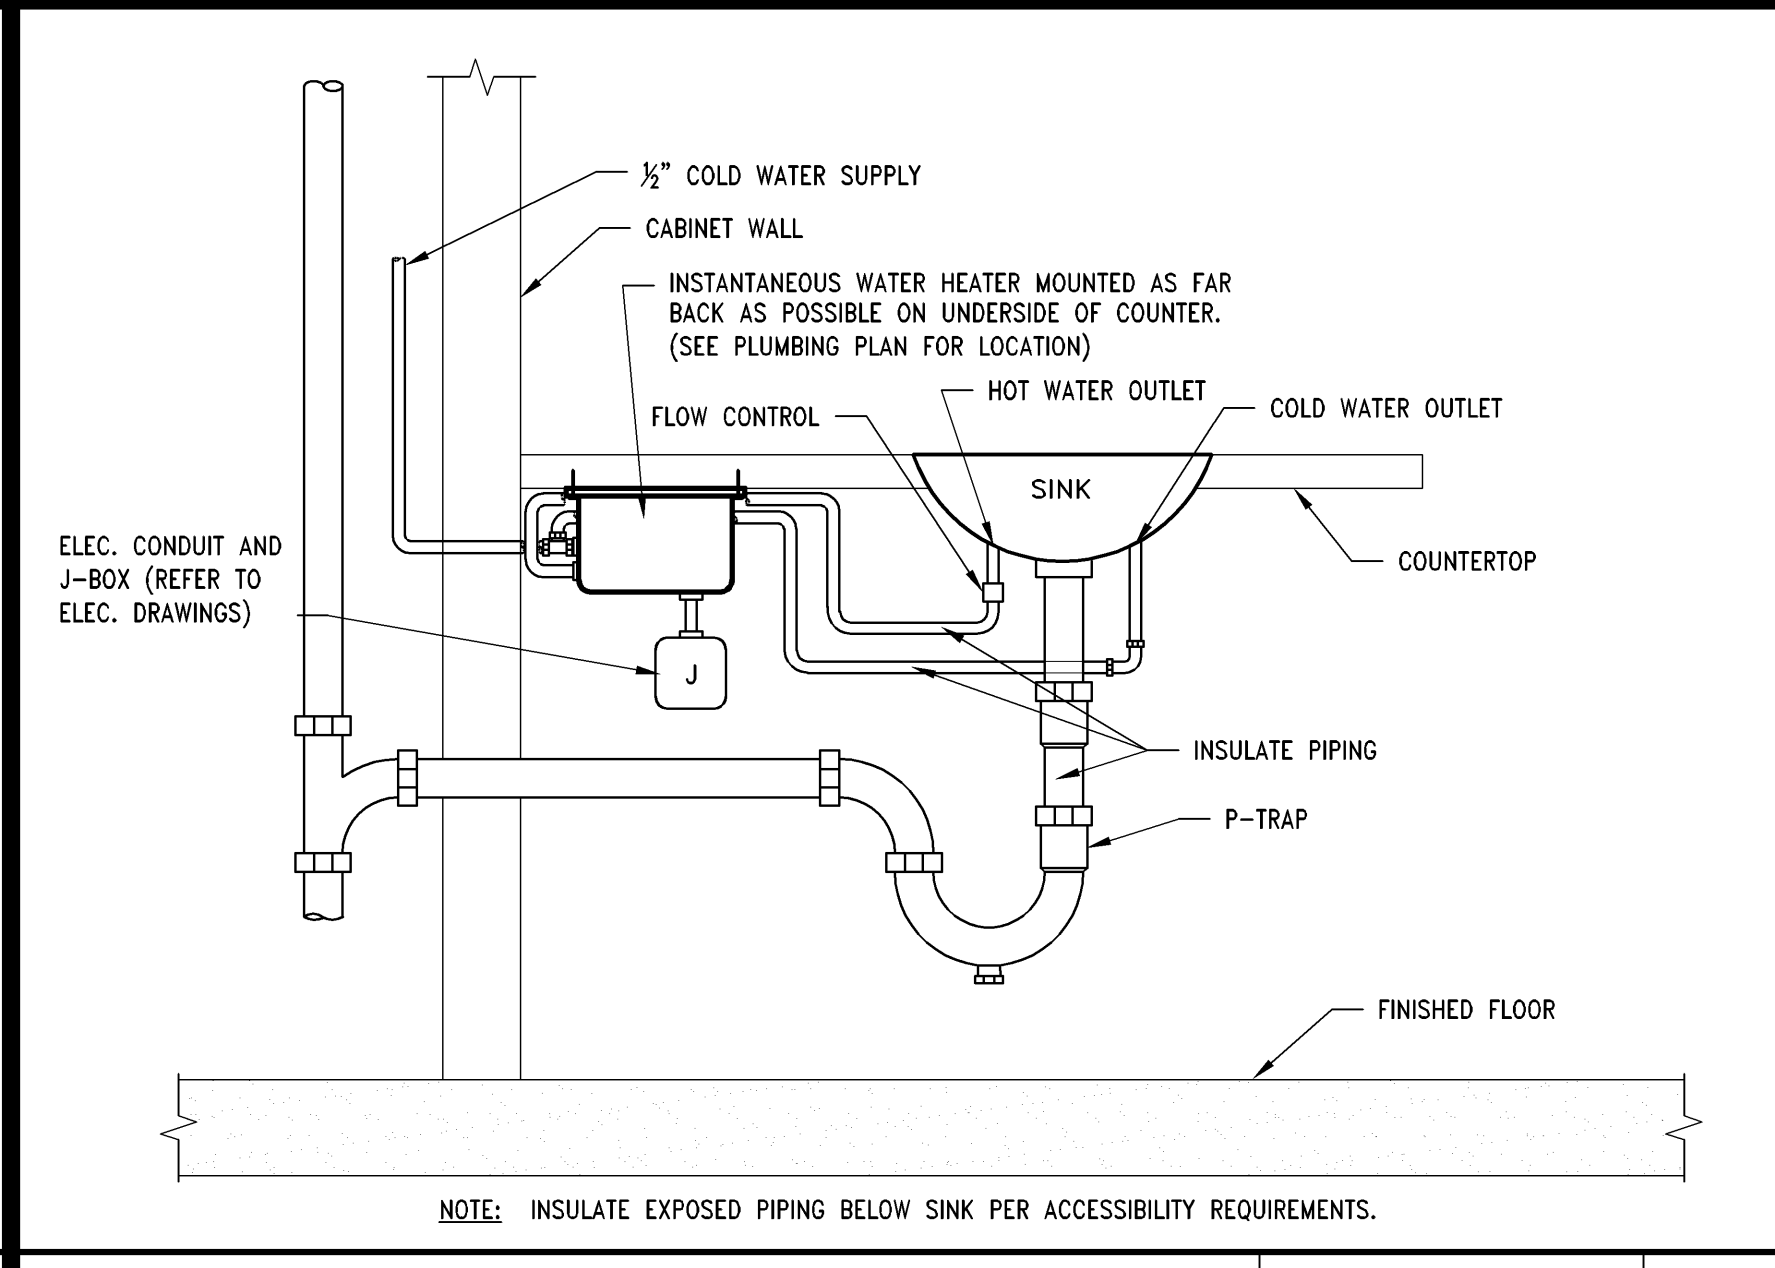


**DEMONSTRATION SINK DETAIL** NTS 42D-P0301-H02-DEMO 09/03/2015

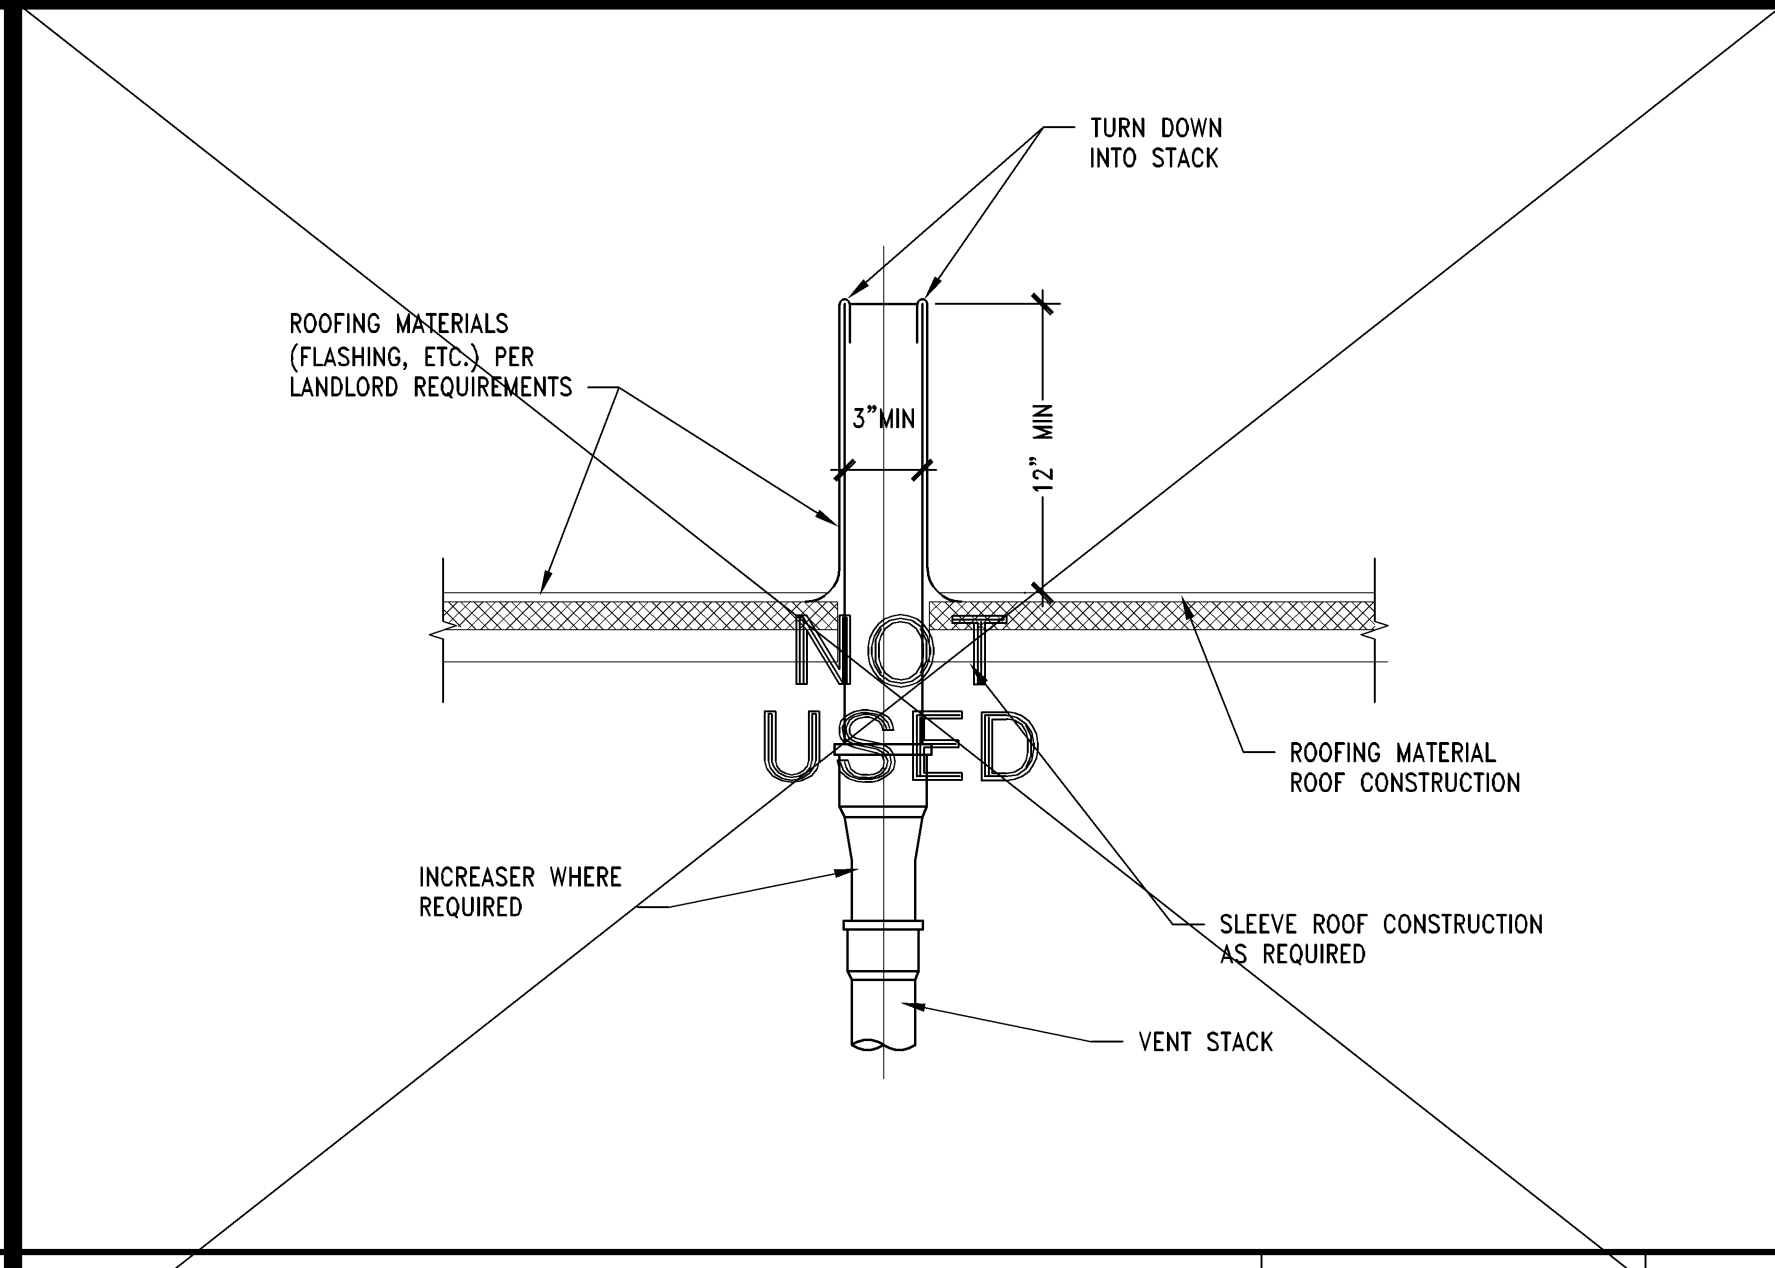


**VENT THRU ROOF DETAIL** 1-1/2"=1'-0" D 00D-P0301-D00-VTR 09/03/2015

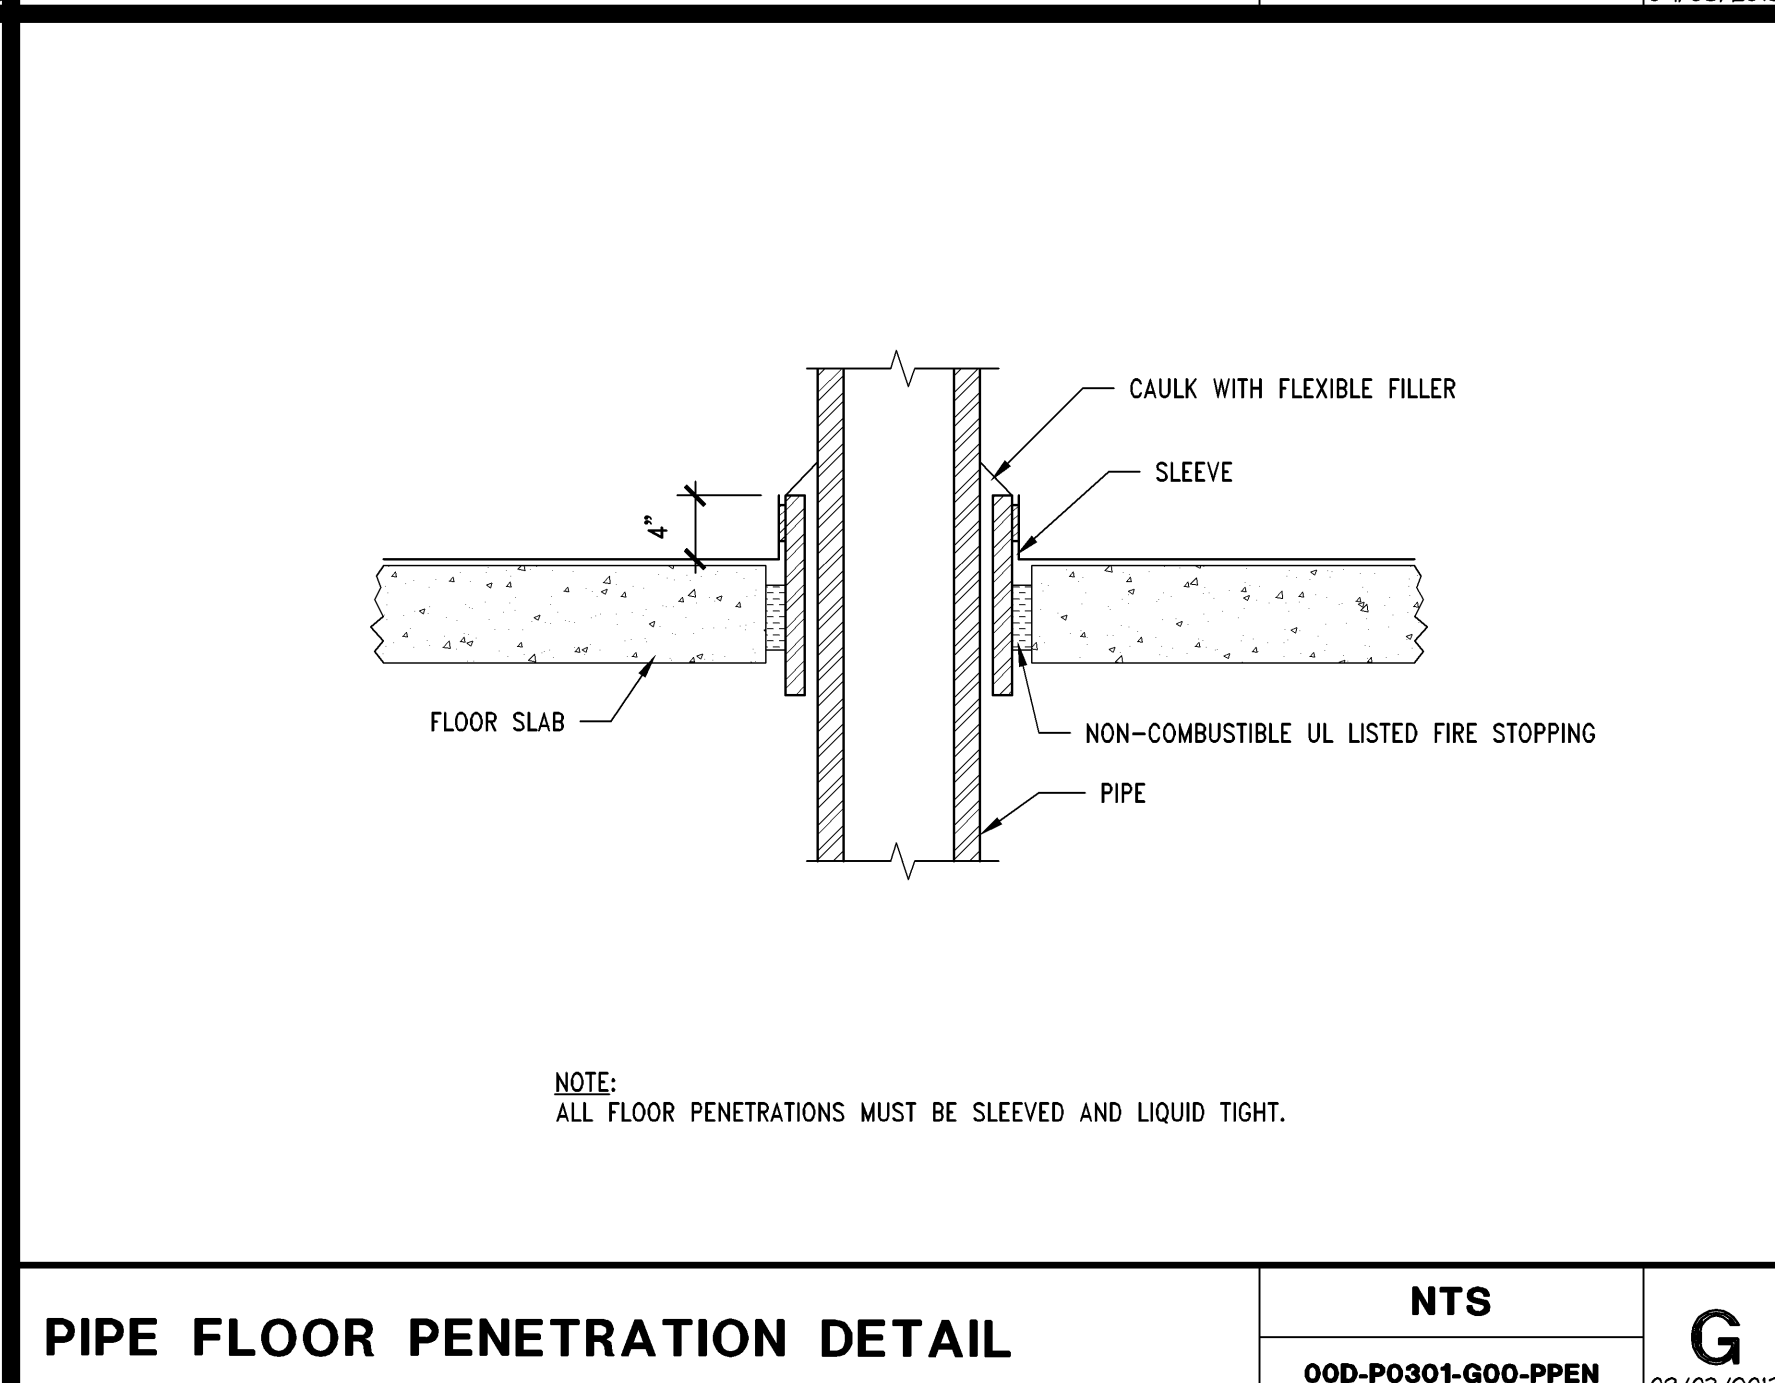


**PIPE FLOOR PENETRATION DETAIL** NTS 00D-P0301-G00-PPEN 09/03/2015

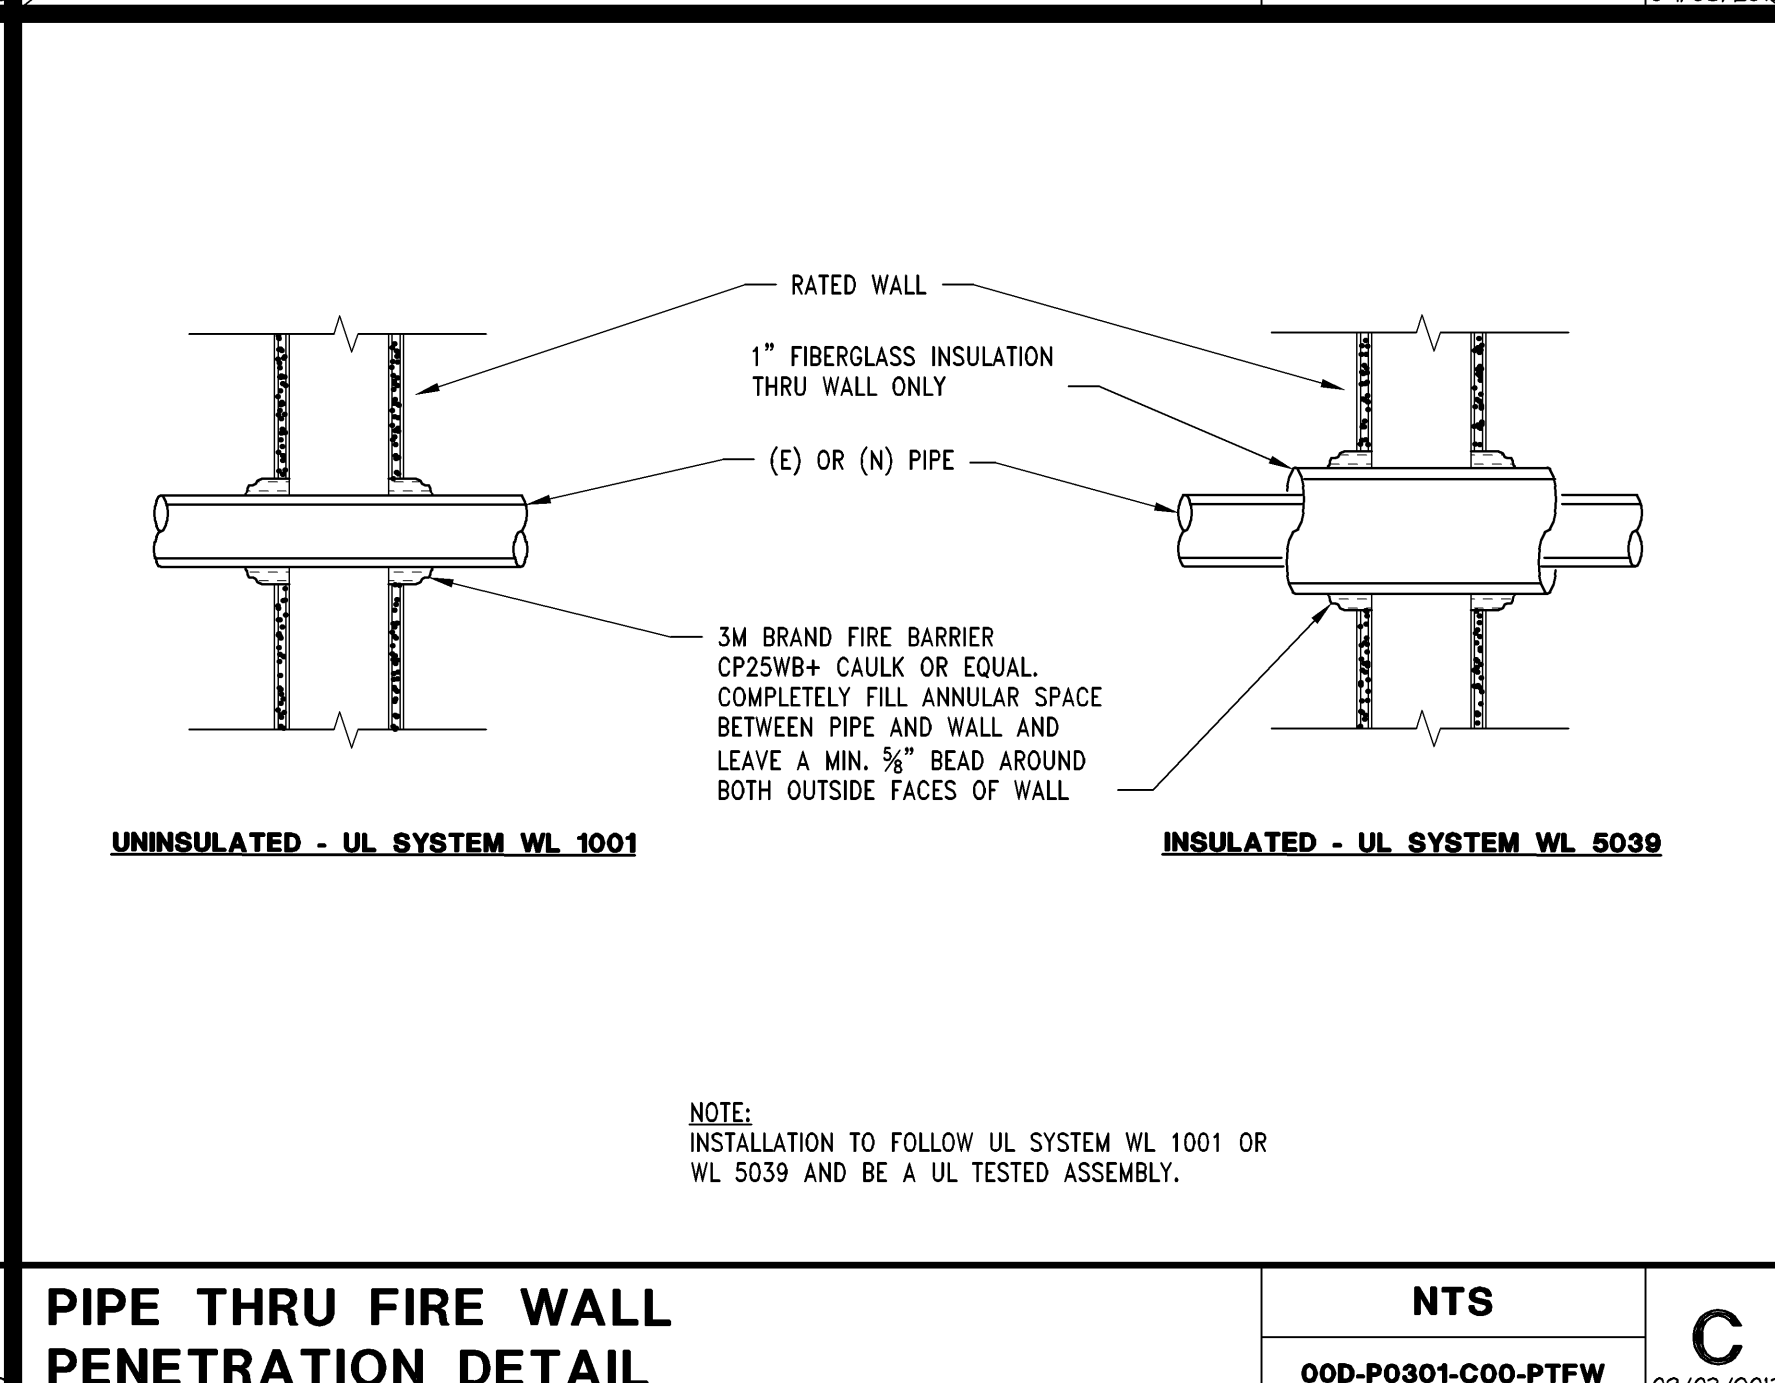


**PIPE THRU FIRE WALL PENETRATION DETAIL** NTS 00D-P0301-C00-PTFW 09/03/2015

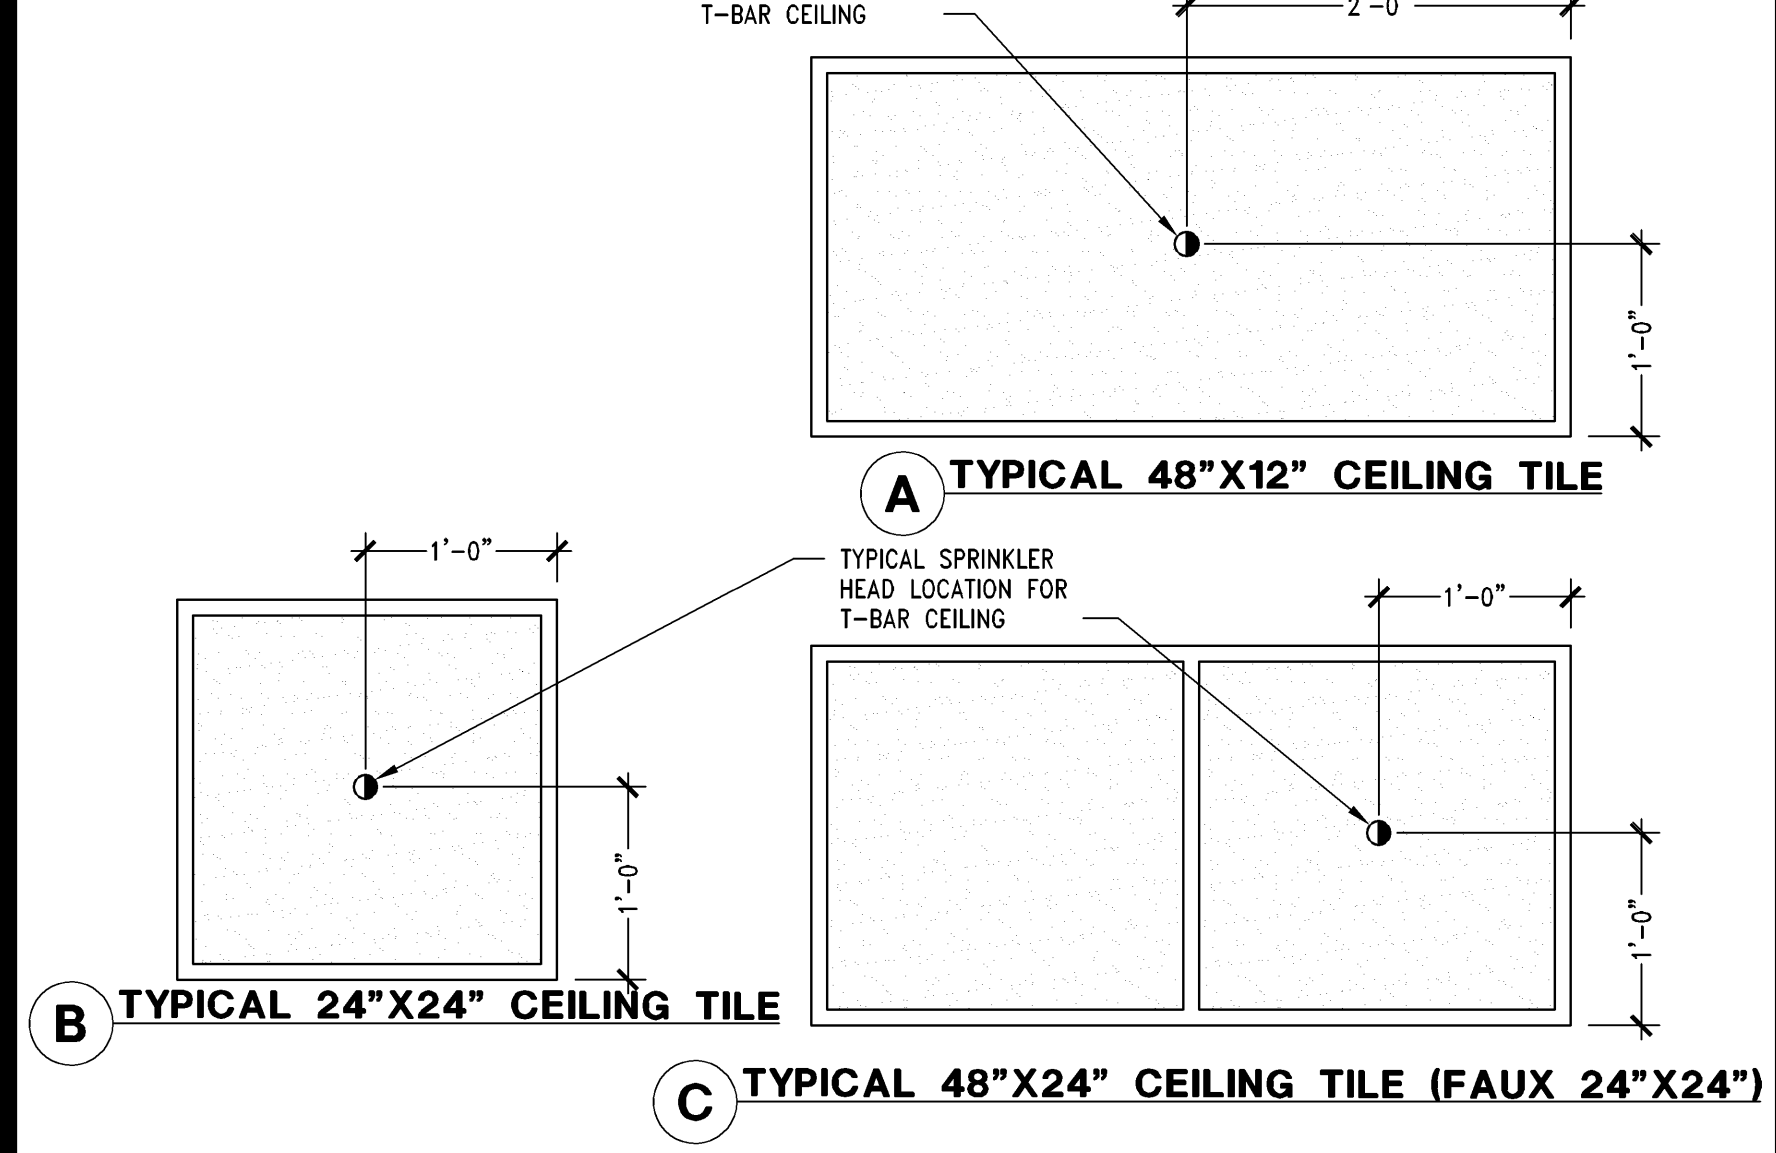


**FIRE SPRINKLER HEAD LOCATION DETAILS** 1" = 1'-0" P 00D-P0301-P00-FSHL 09/03/2015

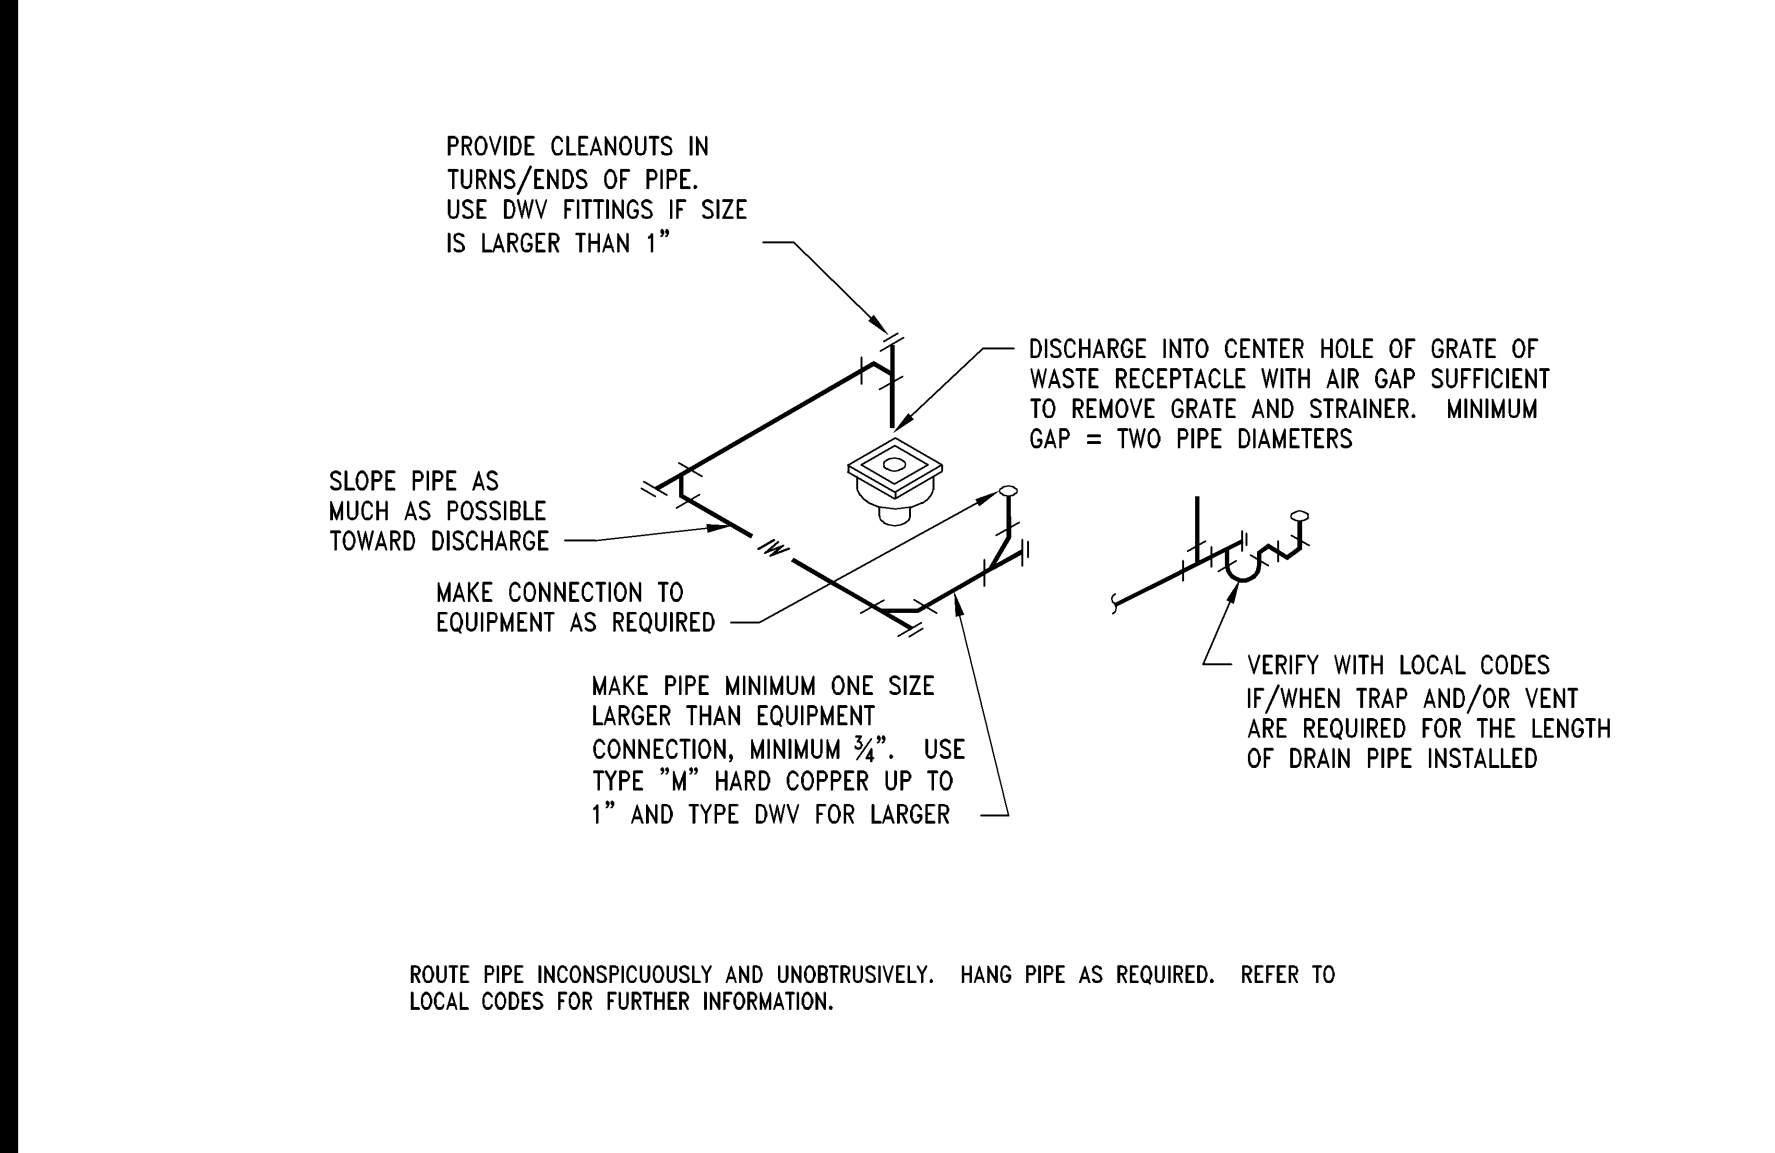


**CONDENSATE DRAIN DETAIL** NTS 00D-P0301-K01-COND 09/03/2015

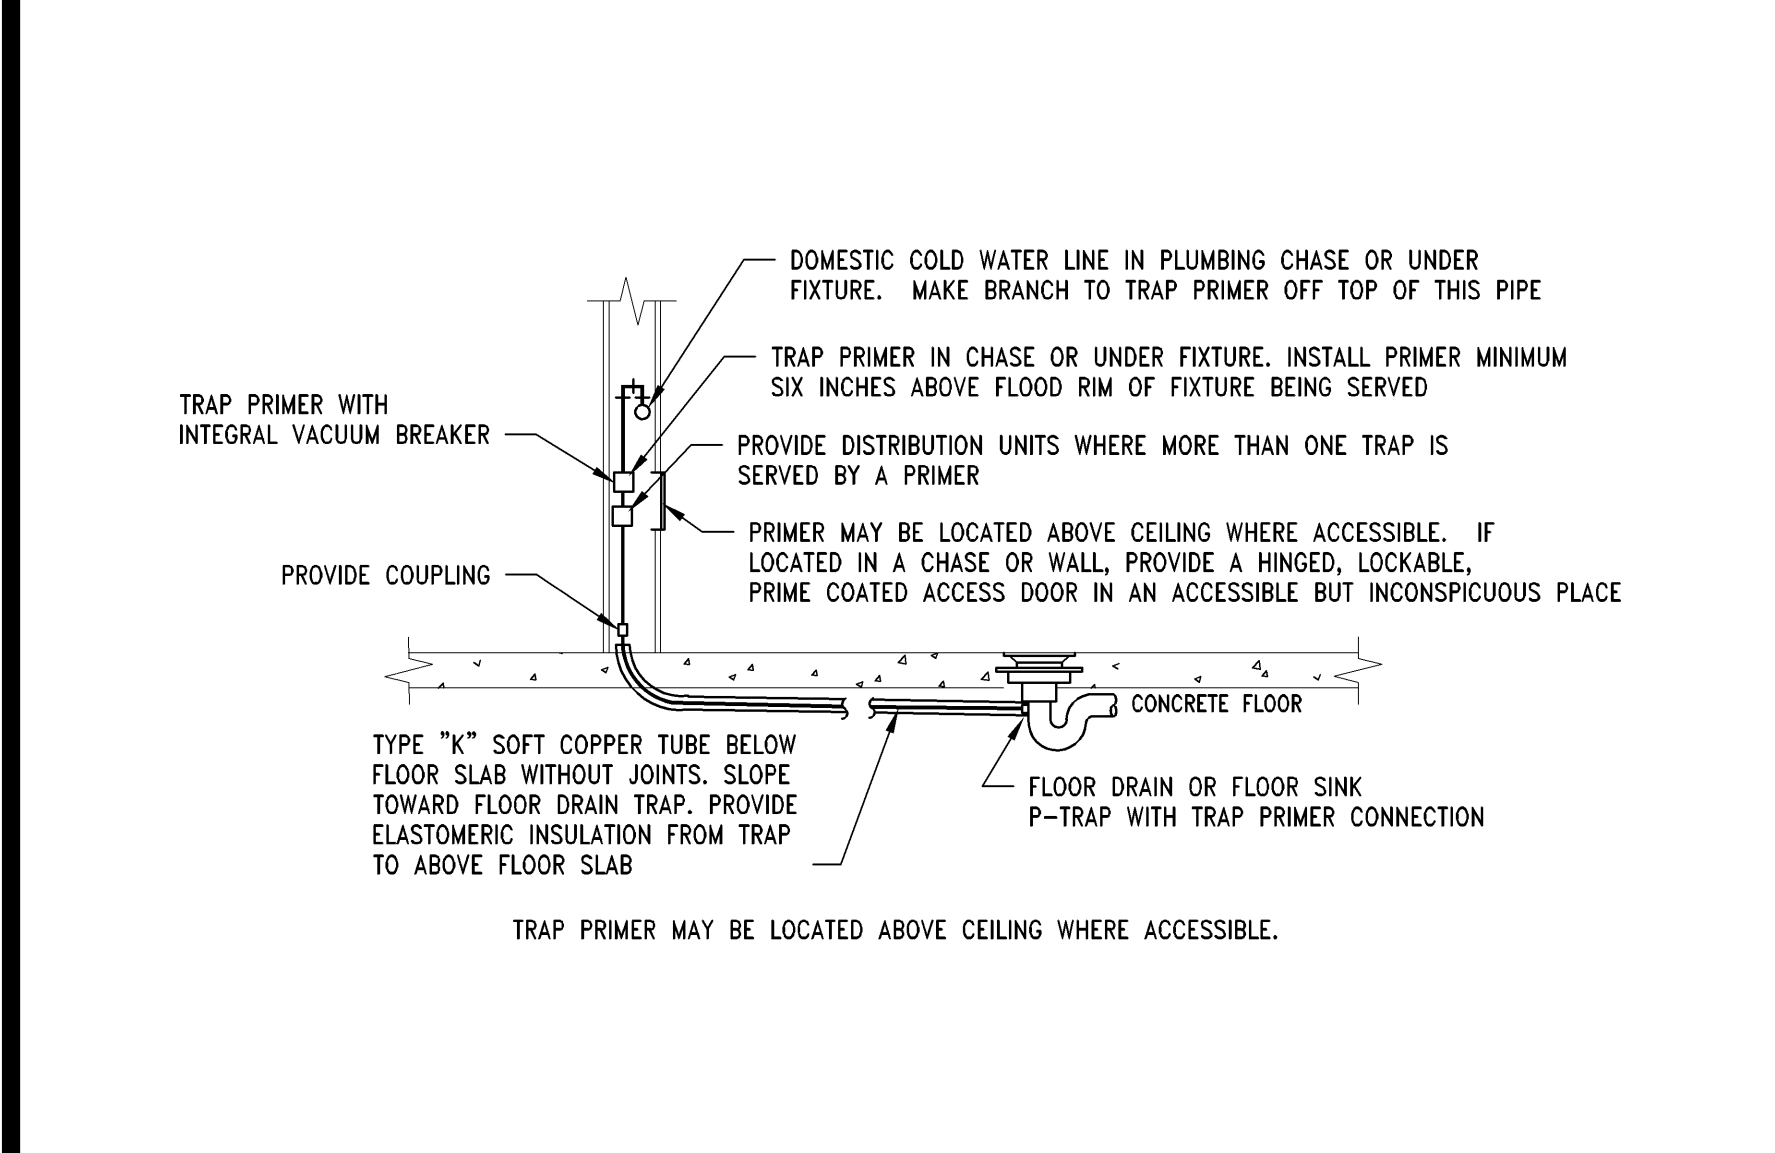


**TRAP PRIMER** 1" = 1'-0" F 00D-P0301-F01-TRAP 09/03/2015

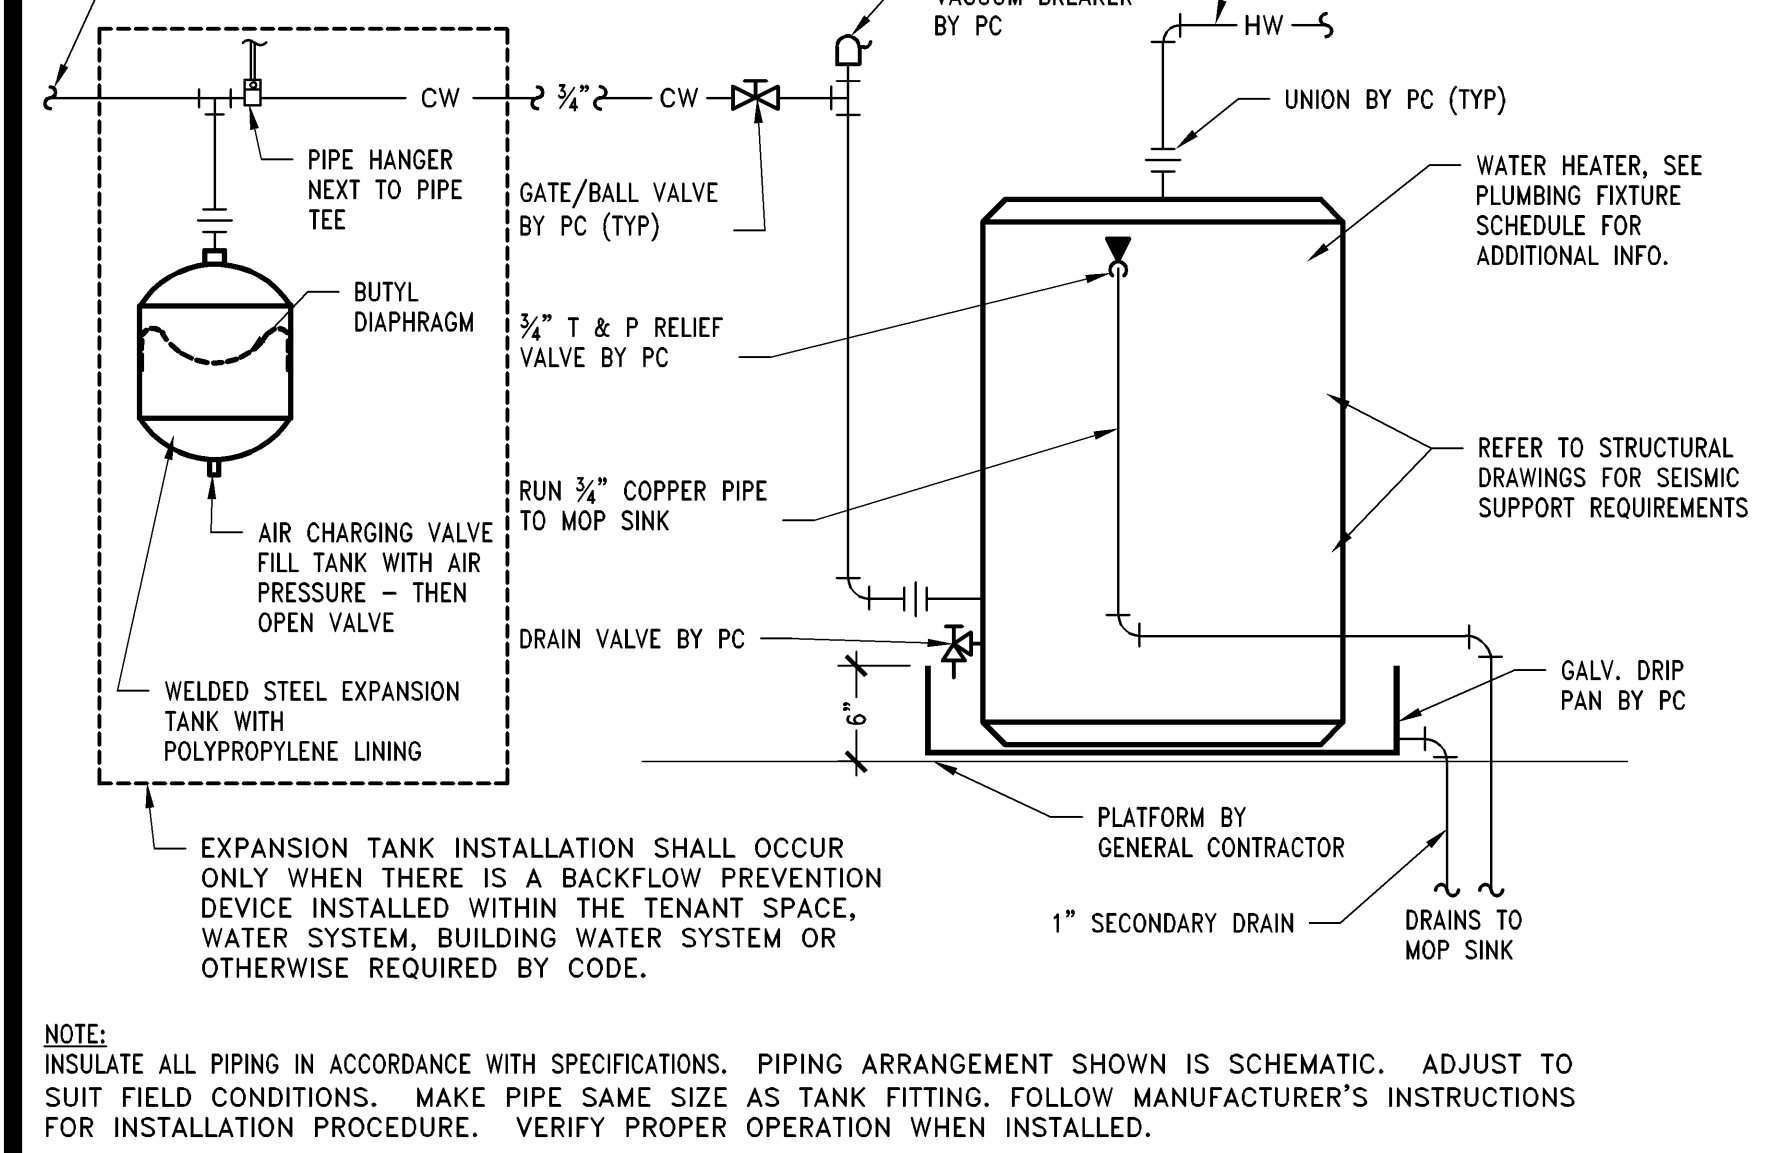


**WATER HEATER DETAIL** 1" = 1'-0" B 00D-P0301-B00-WTHR 09/03/2015

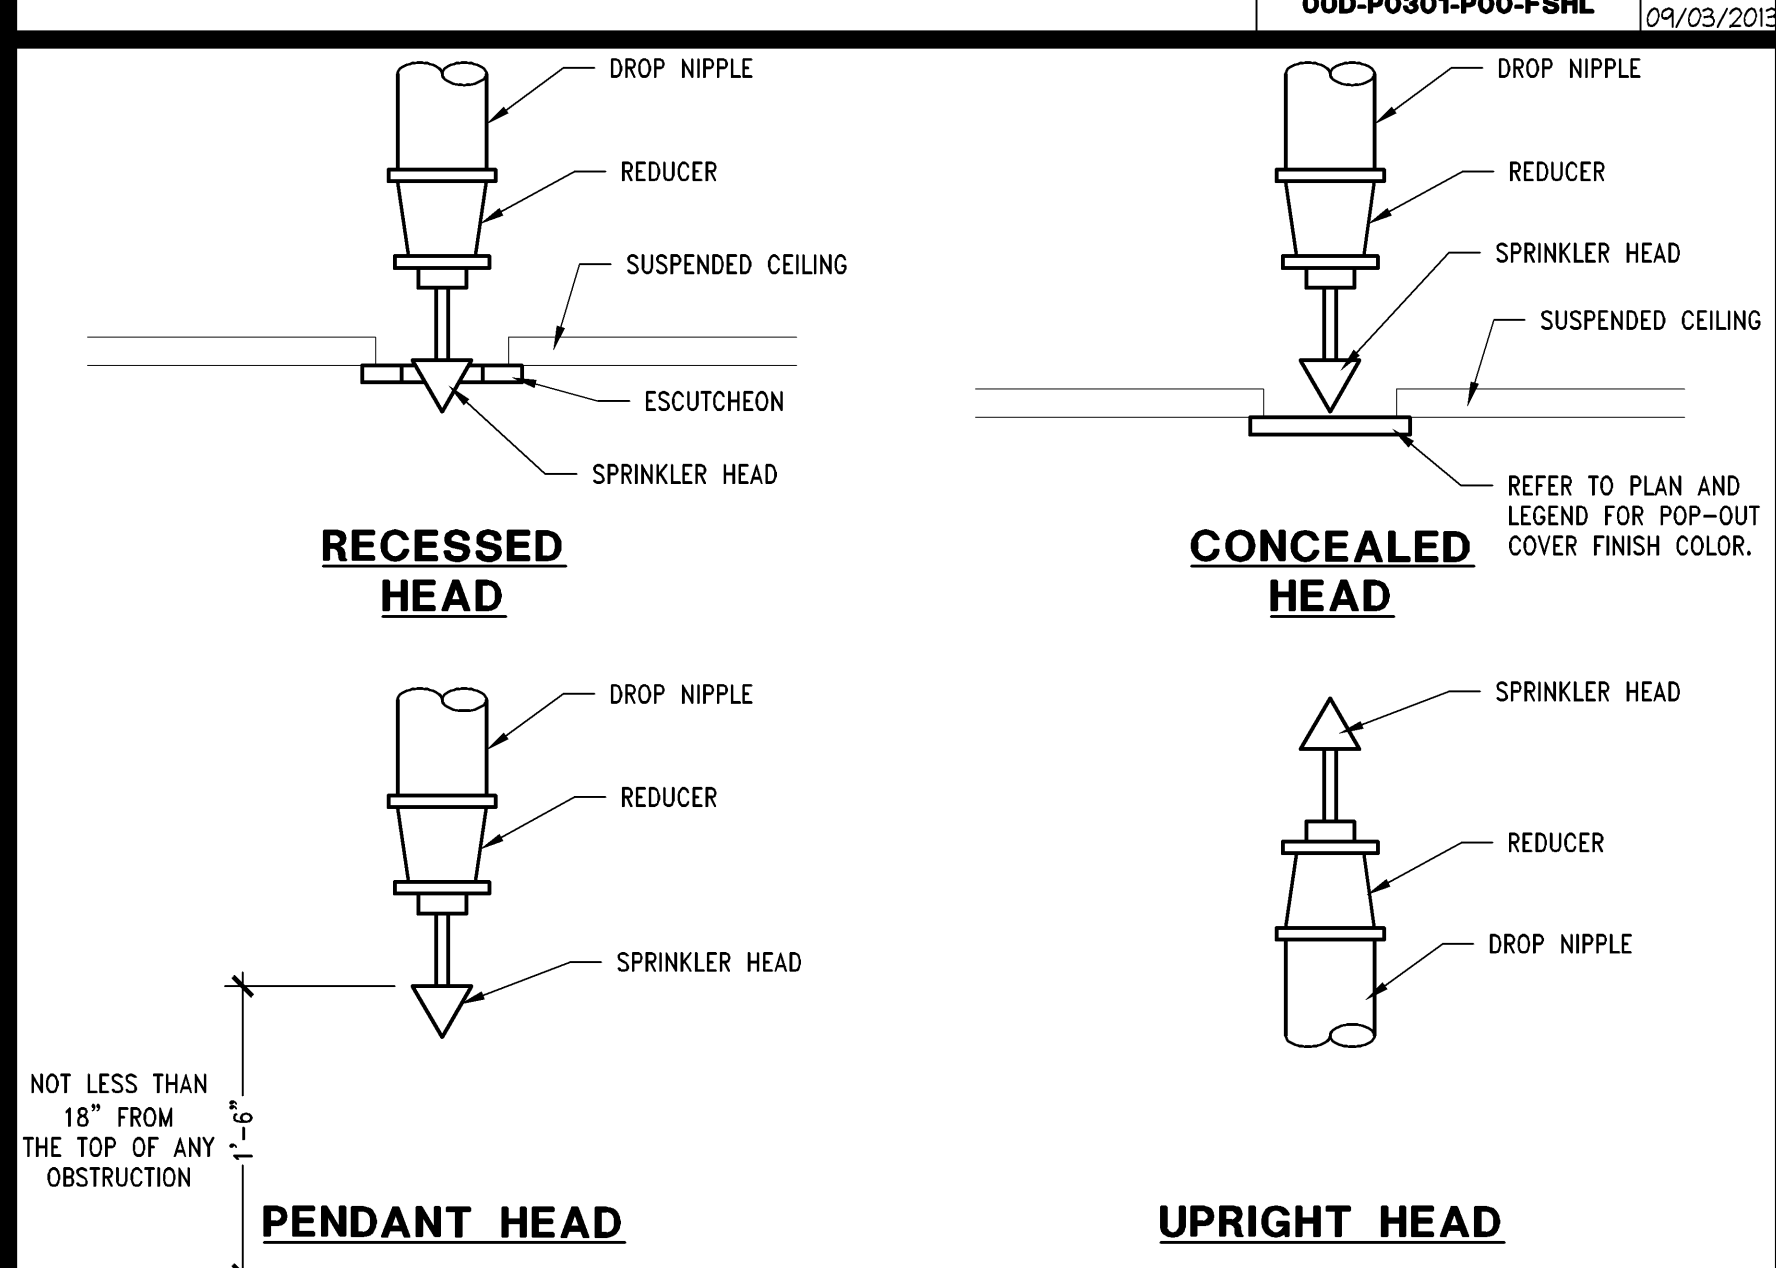


**FIRE SPRINKLER HEAD DETAILS** NTS 00D-P0301-N00-FSHD 02/14/2016

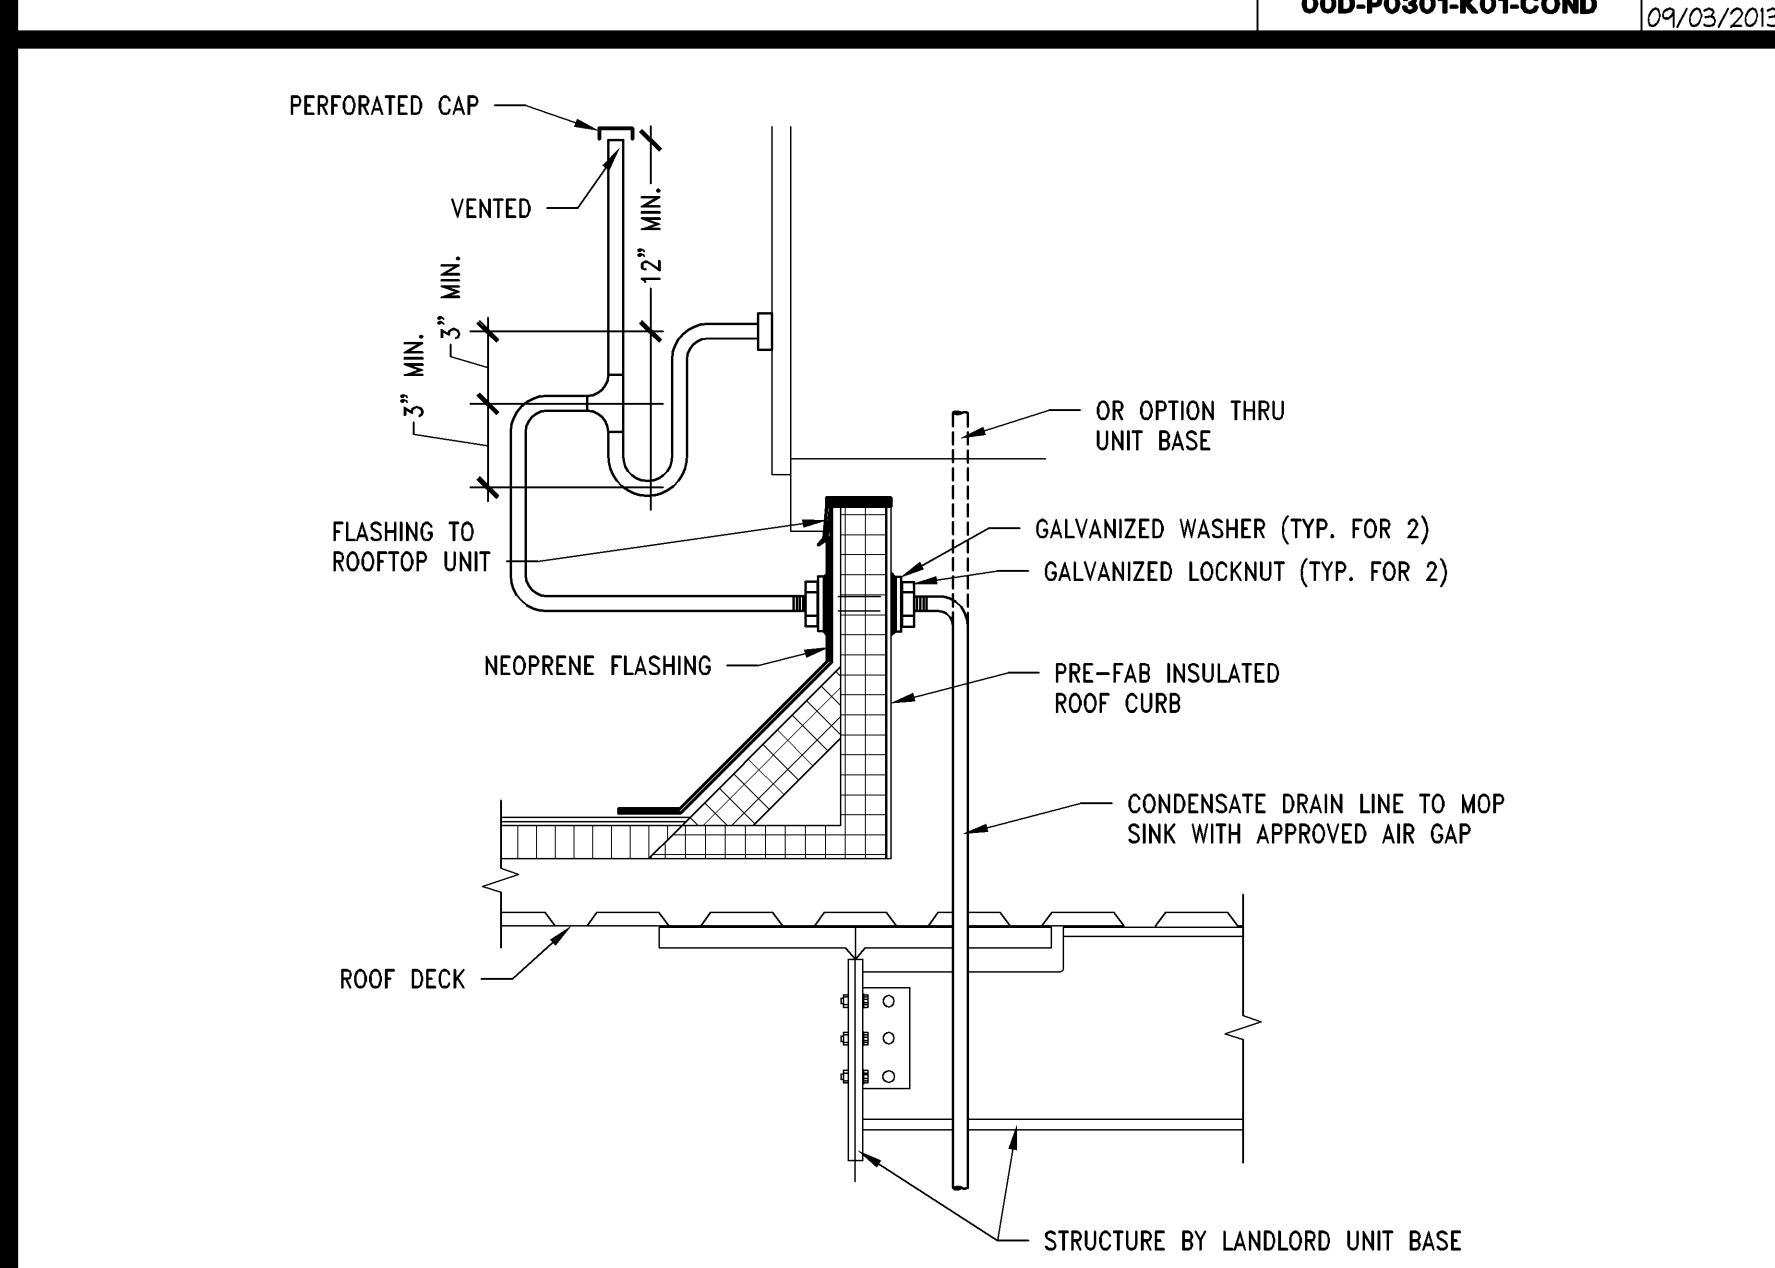

**CONDENSATE DRAIN LINE** 1" = 1'-0" J 00D-P0301-F00-COCD 09/03/2015

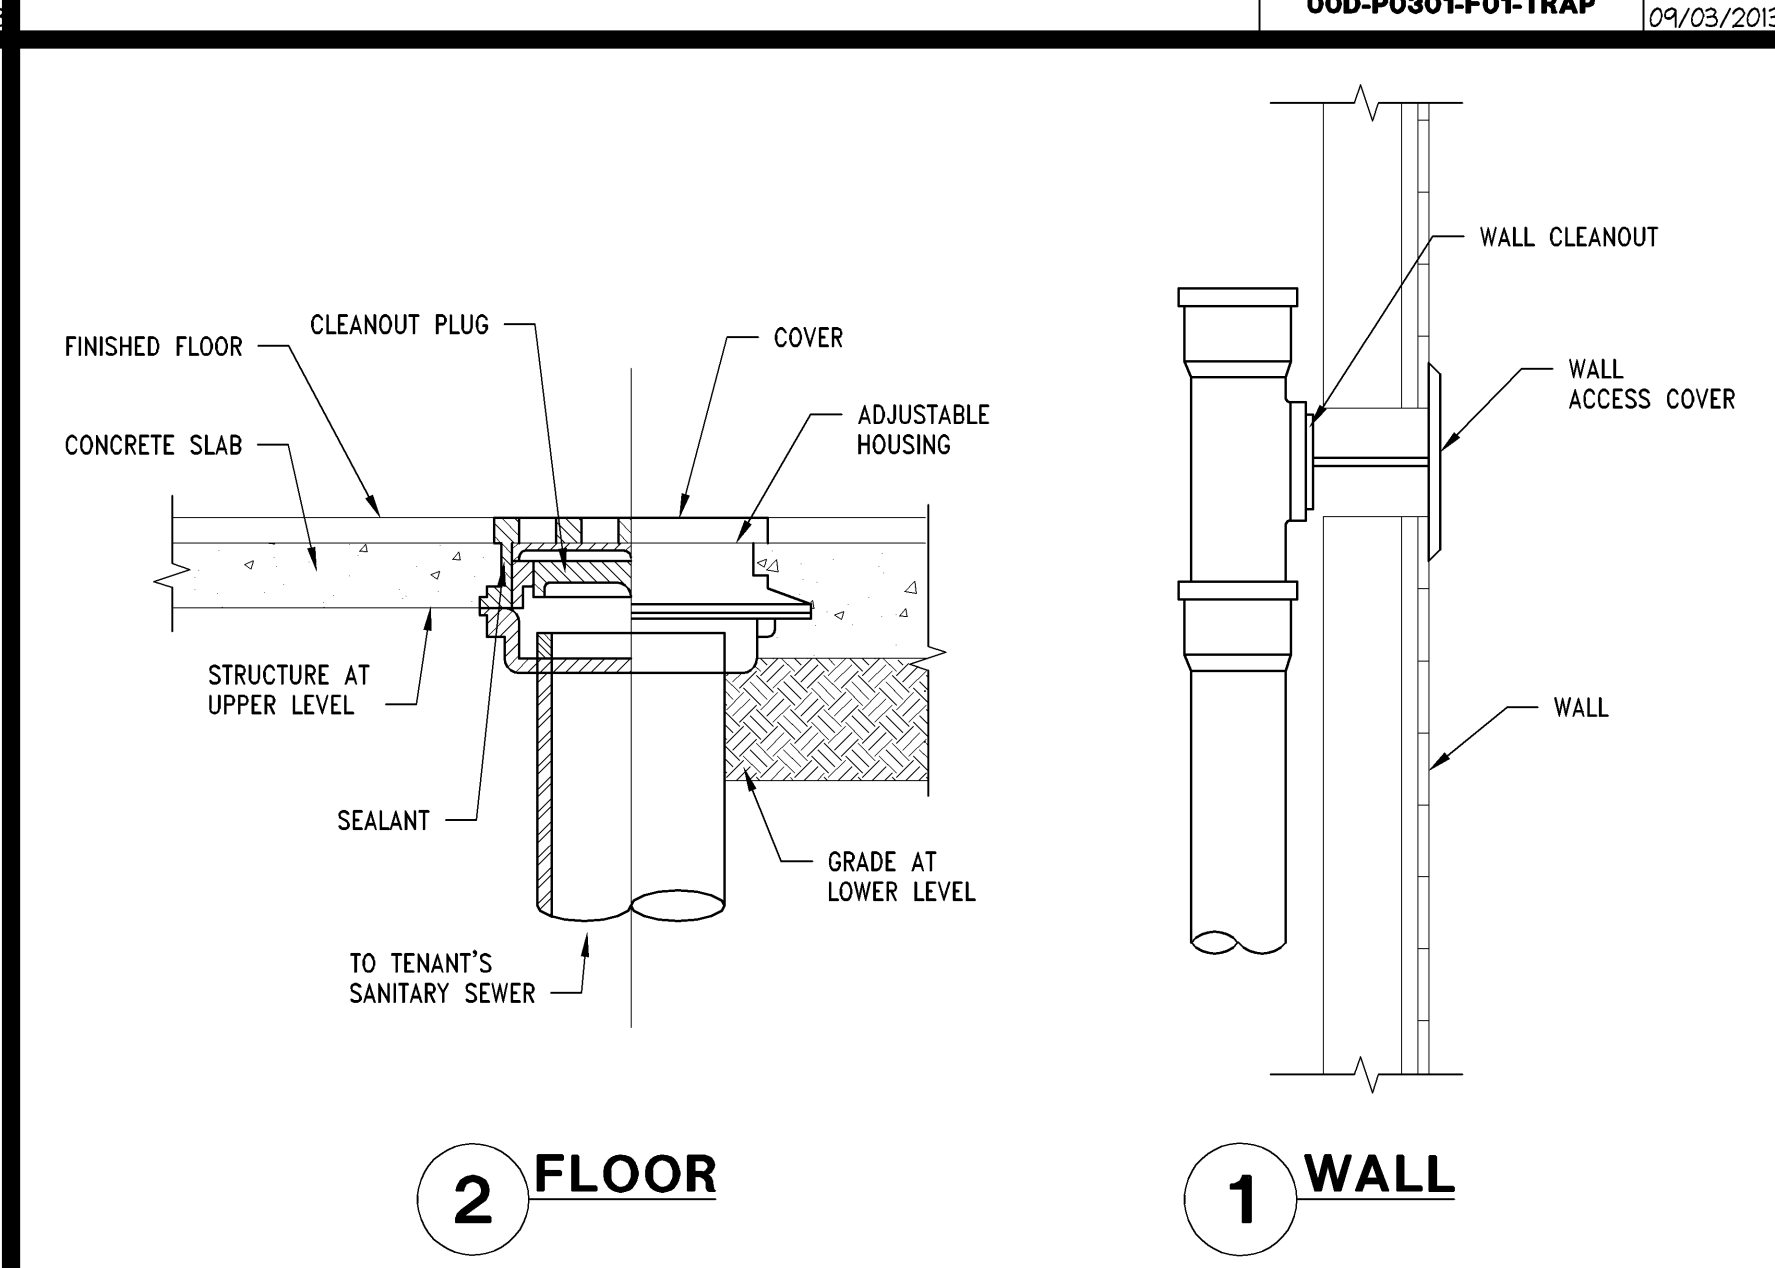

**CLEANOUT DETAILS** NTS 00D-P0301-E00-FWCO 09/03/2015

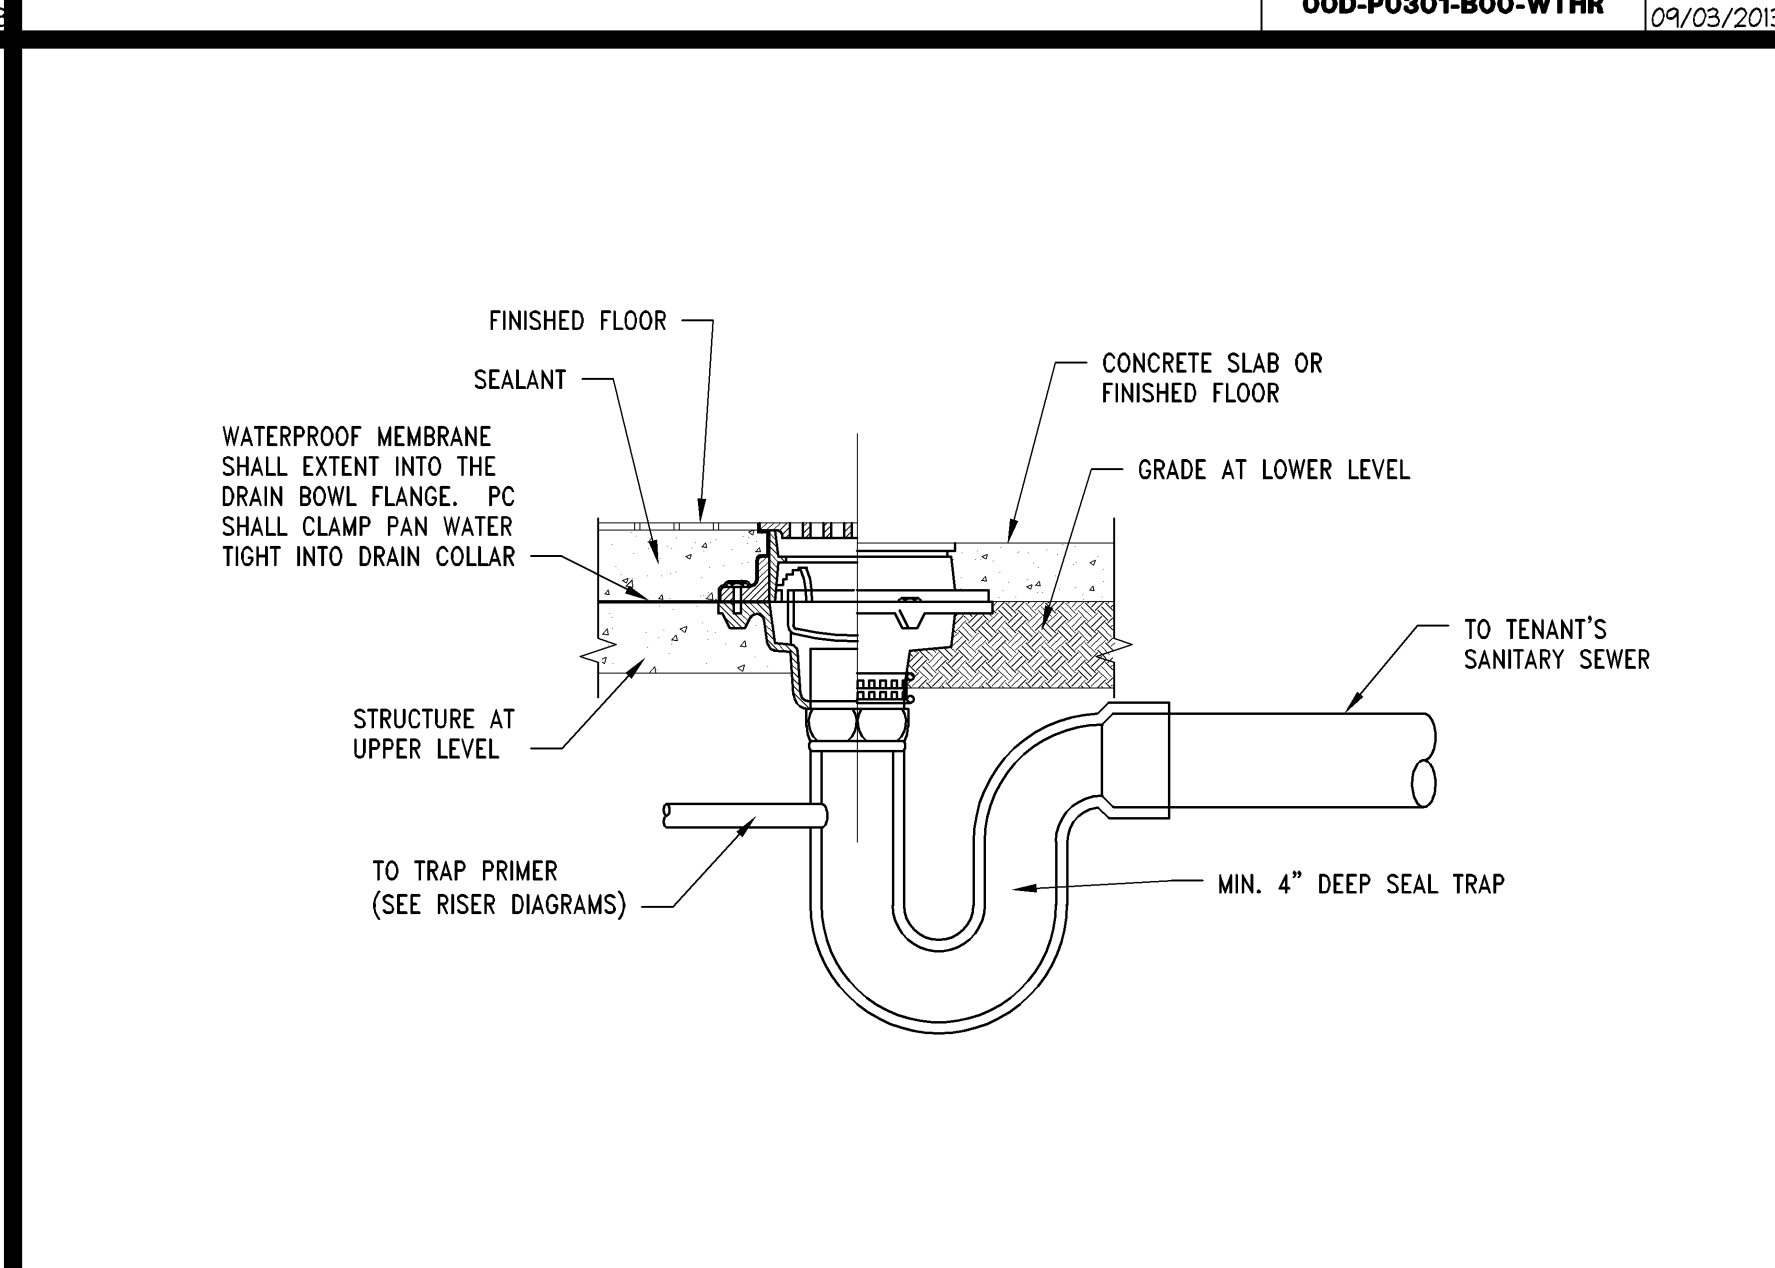

**FLOOR DRAIN DETAIL** NTS 00D-P0301-A00-FDRN 09/03/2015

LARSON BINKLEY  
Larson Binkley, Inc.  
310 W 20th Street, Suite 200  
Kansas City, Missouri 64108  
Texas Certificate of  
Authorization Number P-1367  
T 816-967-9601  
F 816-967-9602  
larsorbinkley.com

Limitedbrands  
LIMITED STORE PLANNING, INC.  
d/b/a STORE DESIGN & CONSTRUCTION  
Three Limited Parkway • Columbus, Ohio 43230  
Telephone: 614.415.7000 • Fax: 614.415.7349

0242003996

**BATH & BODY WORKS**

MEMORIAL CITY MALL  
303 SUITE 735  
HOUSTON, TX 77024

RELO DWN / NEW PACKAGE:  
SCOPE: EASTON-C GENERATION:  
150M2 A/E PROJECT #: 60685

14159  
13643

PROJECT INFORMATION:

REVISIONS:

DATE ISSUED: 04/11/2014  
DESIGNED BY: JES  
DRAWN BY: JES  
CHECKED BY: NRP

PLUMBING AND FIRE PROTECTION DETAILS

DRAWING NUMBER:  
**P03.01**