

Limited brands

LIMITED STORE PLANNING, INC.
d/b/a STORE DESIGN & CONSTRUCTION
Three Limited Parkway • Columbus, Ohio 43230
Telephone: 614.415.7000 • Fax: 614.415.7349

PROJECT INFORMATION: **PINK VICTORIA'S SECRET**
FAYETTE MALL
 3401 NICHOLASVILLE RD
 SPACE # 1-904
 LEXINGTON, KY 40503


REVISIONS:

REQUIRED BY:	DATE
ELITE CONSTRUCTION GROUP LAKE JACKSON, TX PHONE: 979-285-0712	
NOTE: THESE PRINTS HAVE BEEN REDUCED BY 50 PERCENT. SCALE WILL BE 50 PERCENT OF WHAT IS NOTED ON PLANS	


DATE ISSUED: 09-05-201
DESIGNED BY: RG
DRAWN BY: RG
CHECKED BY: JM

MECHANICAL DETAILS


DRAWING NUMBER:
M03.01

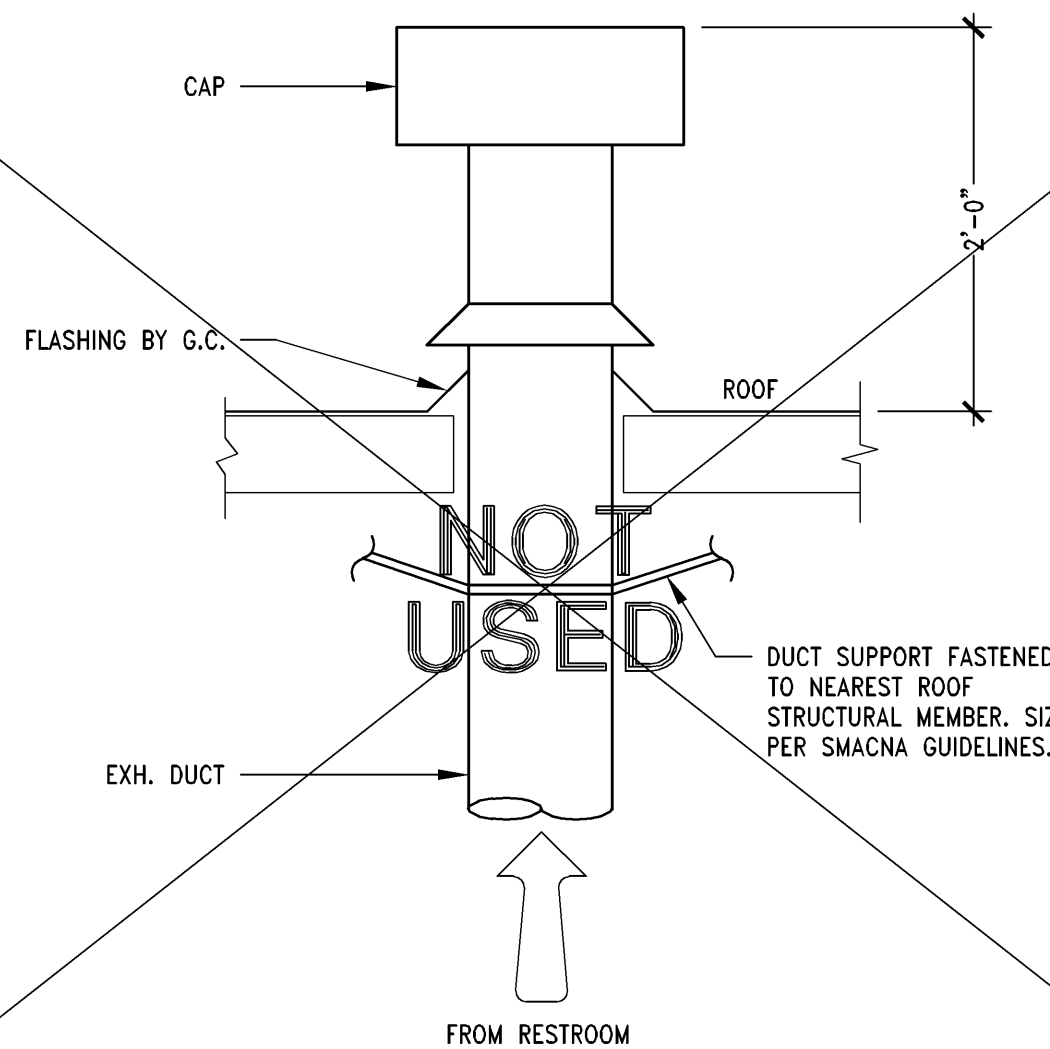




~~D~~

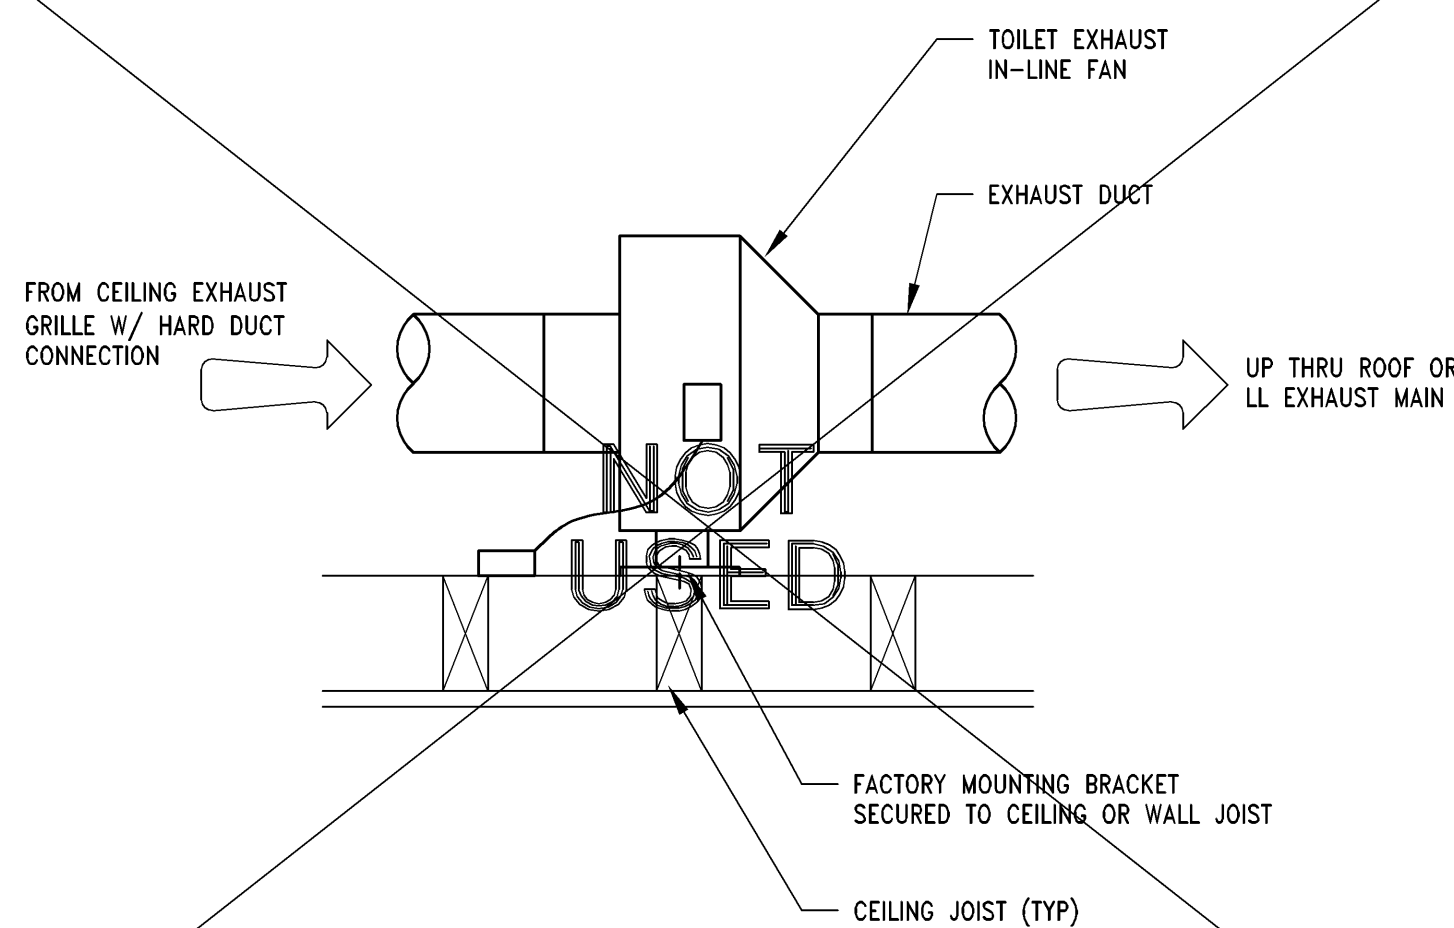


C
09/13/18

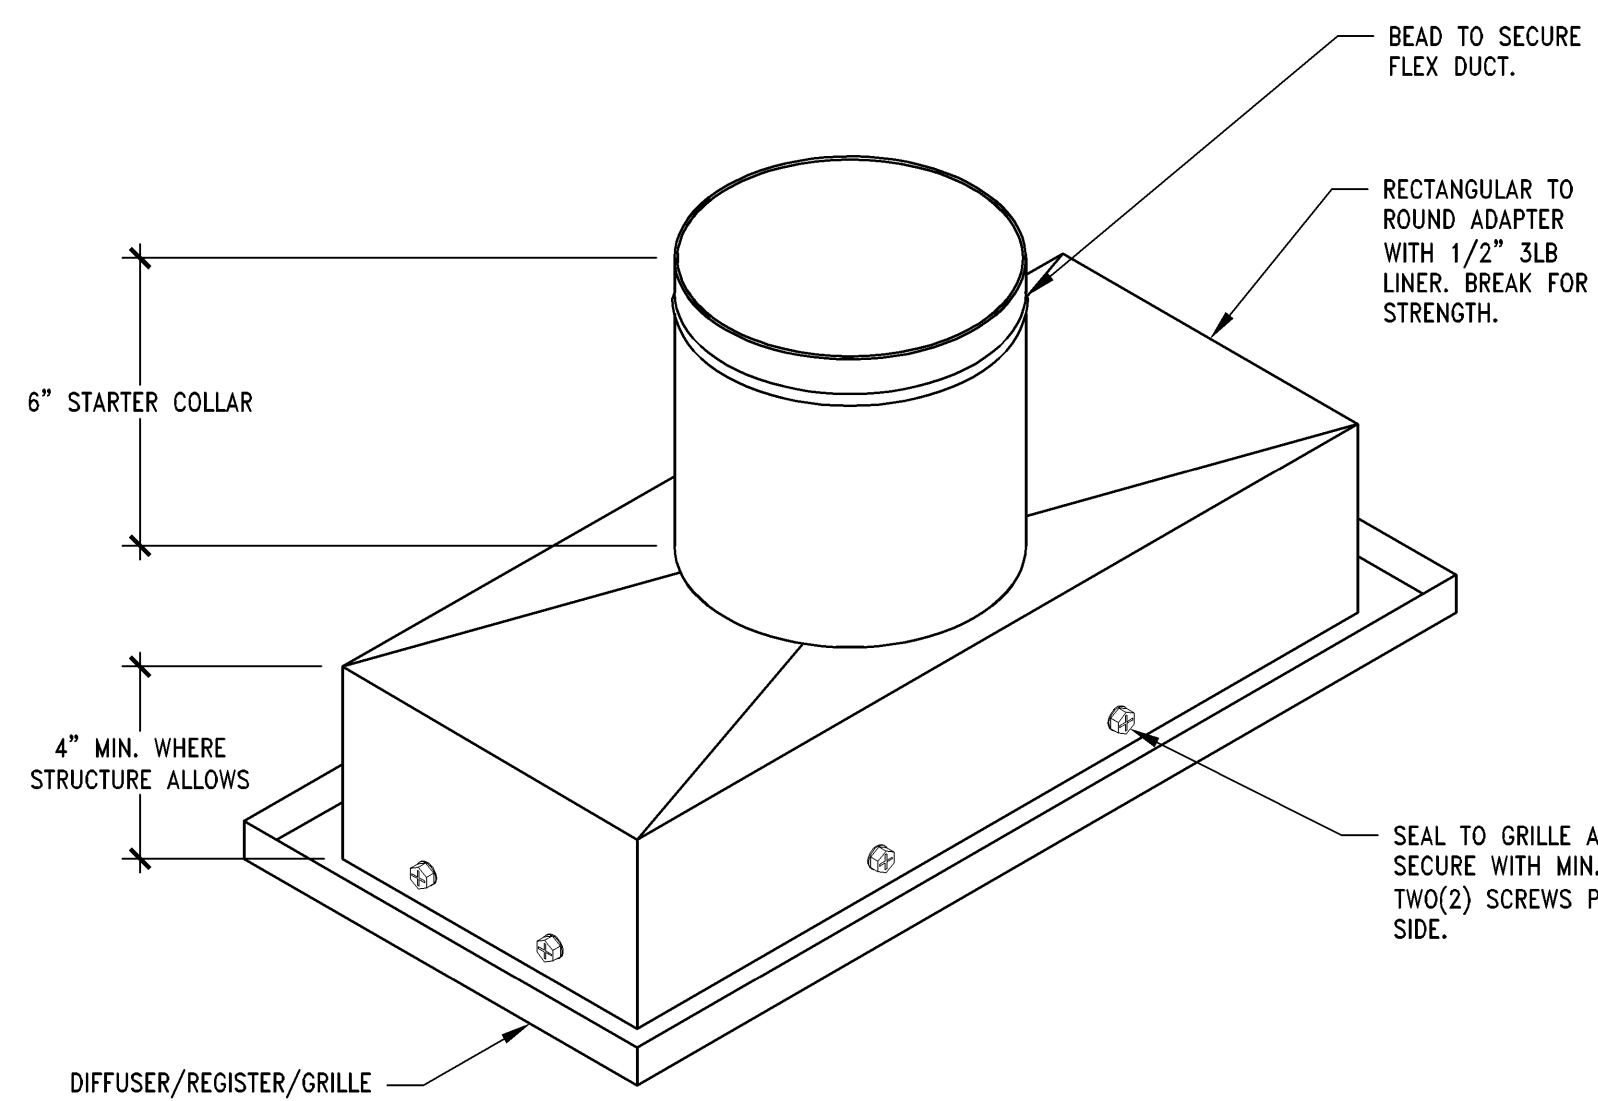

G
09/13/13

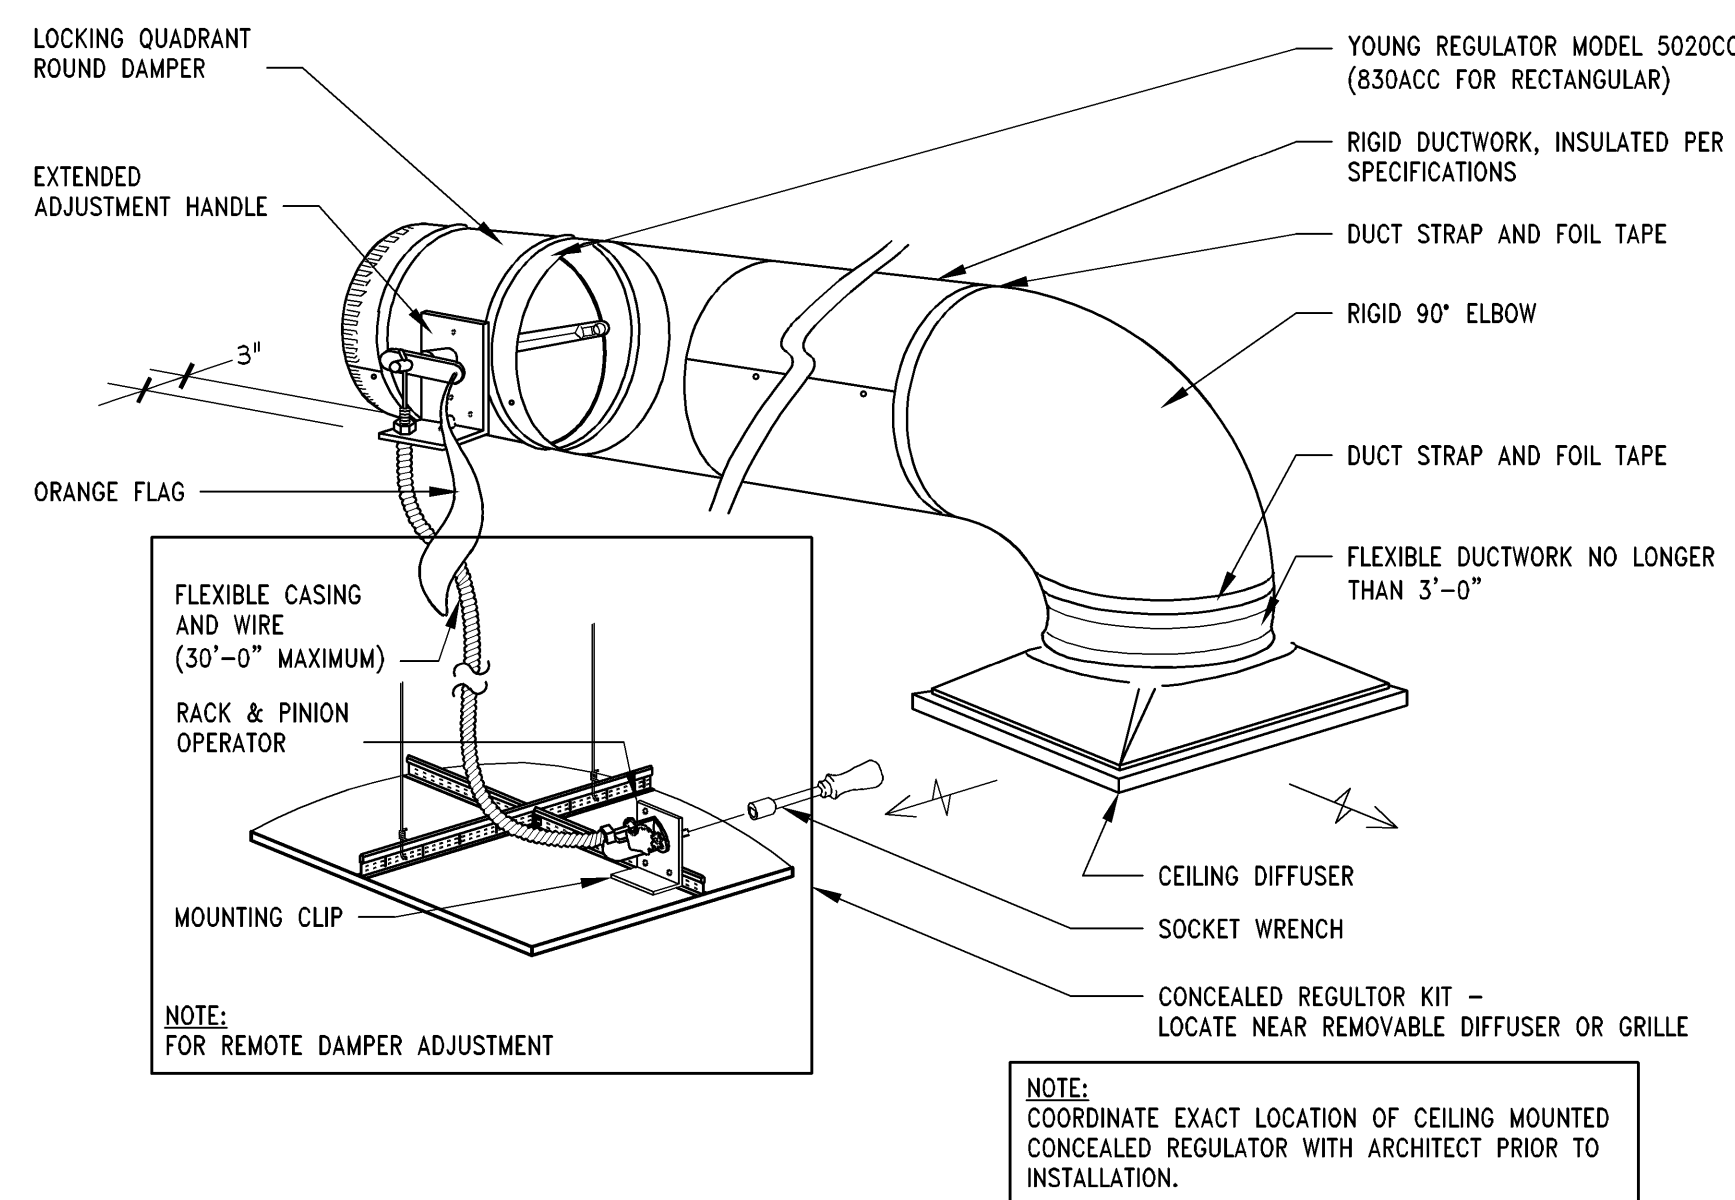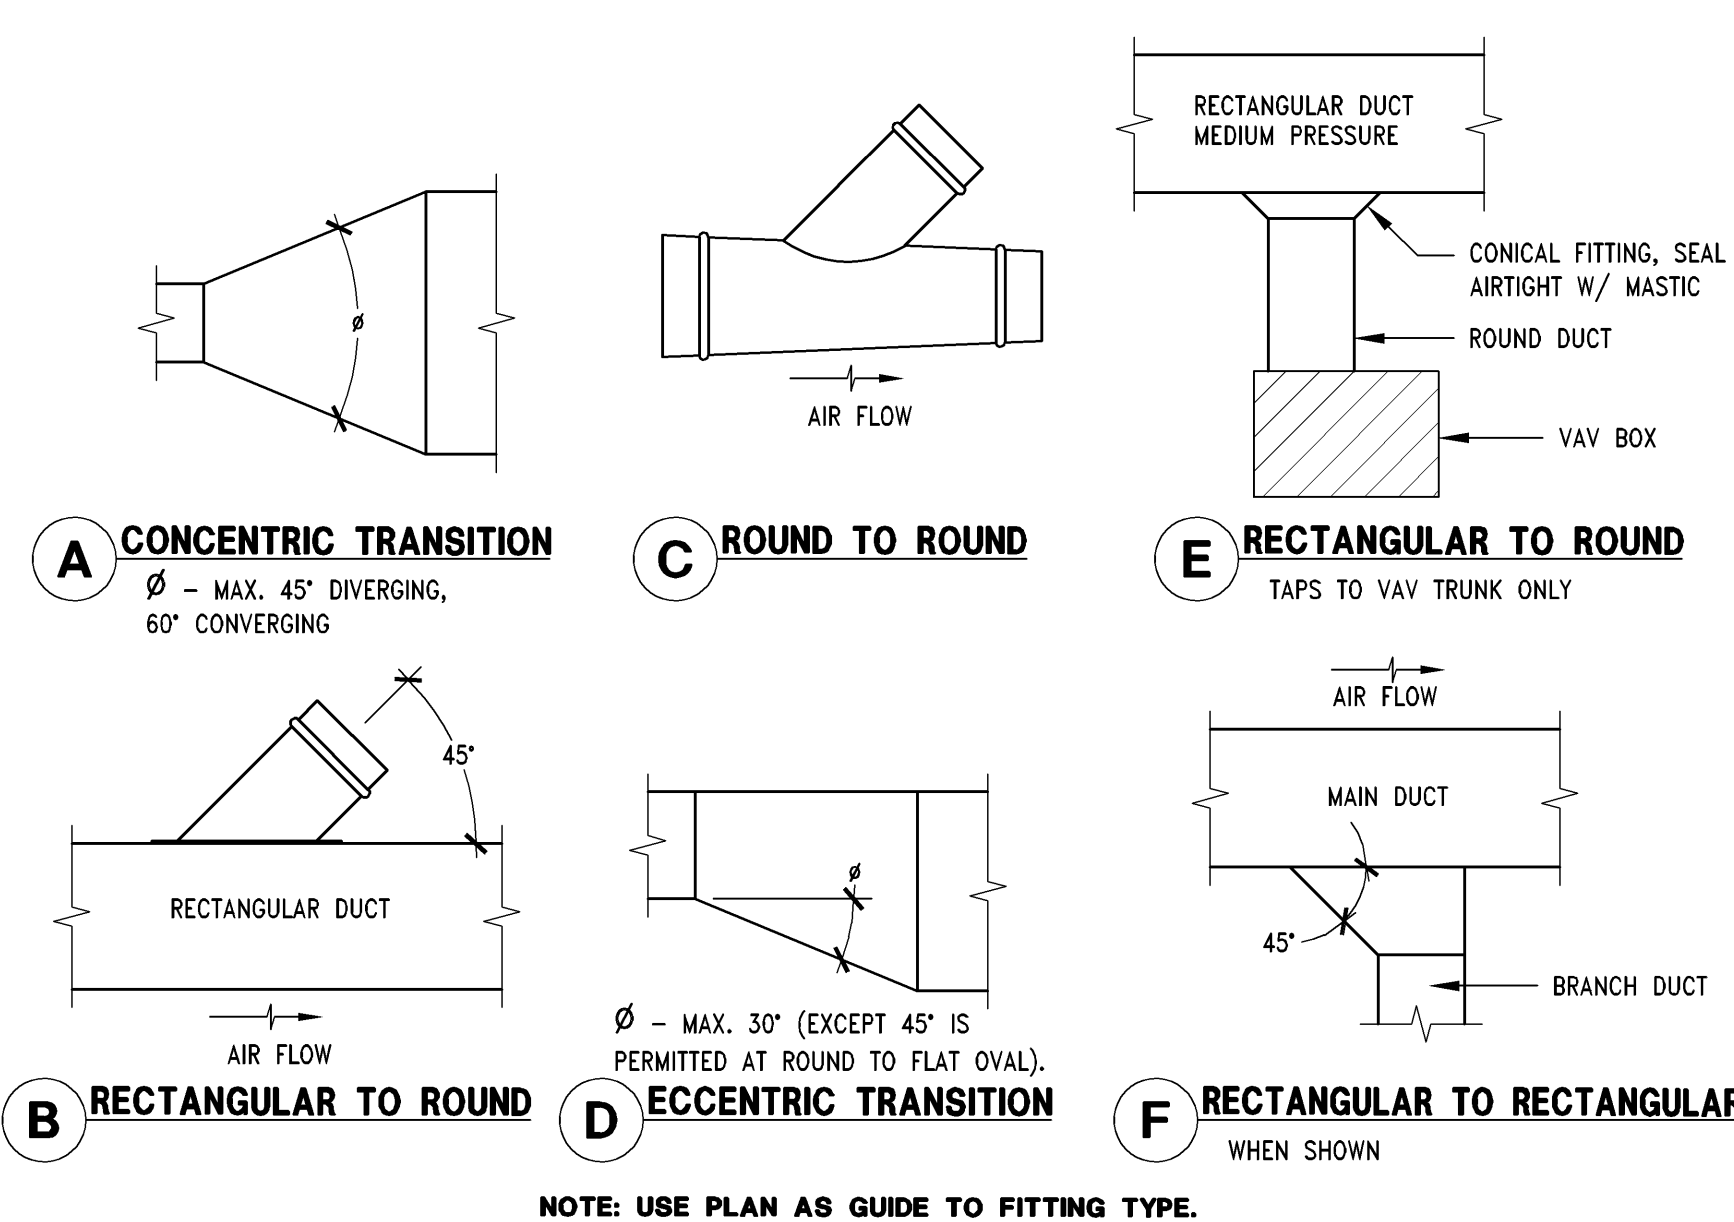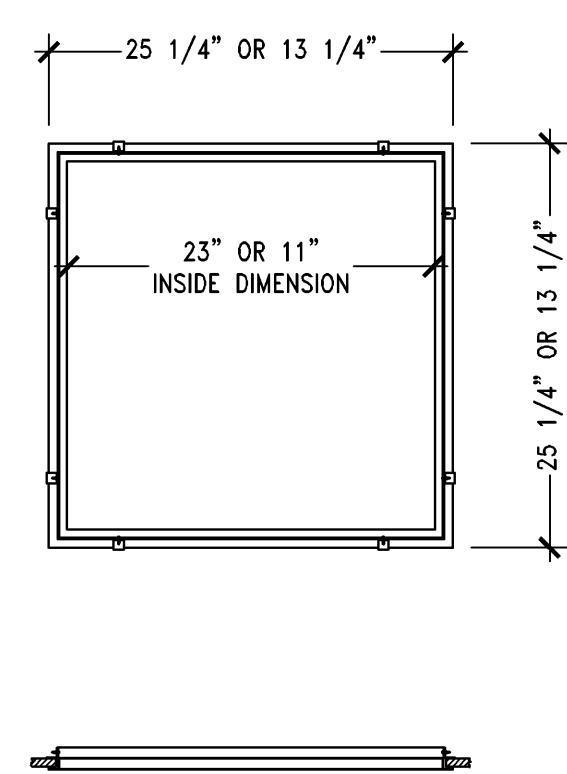**F****B**

E
02/18/14

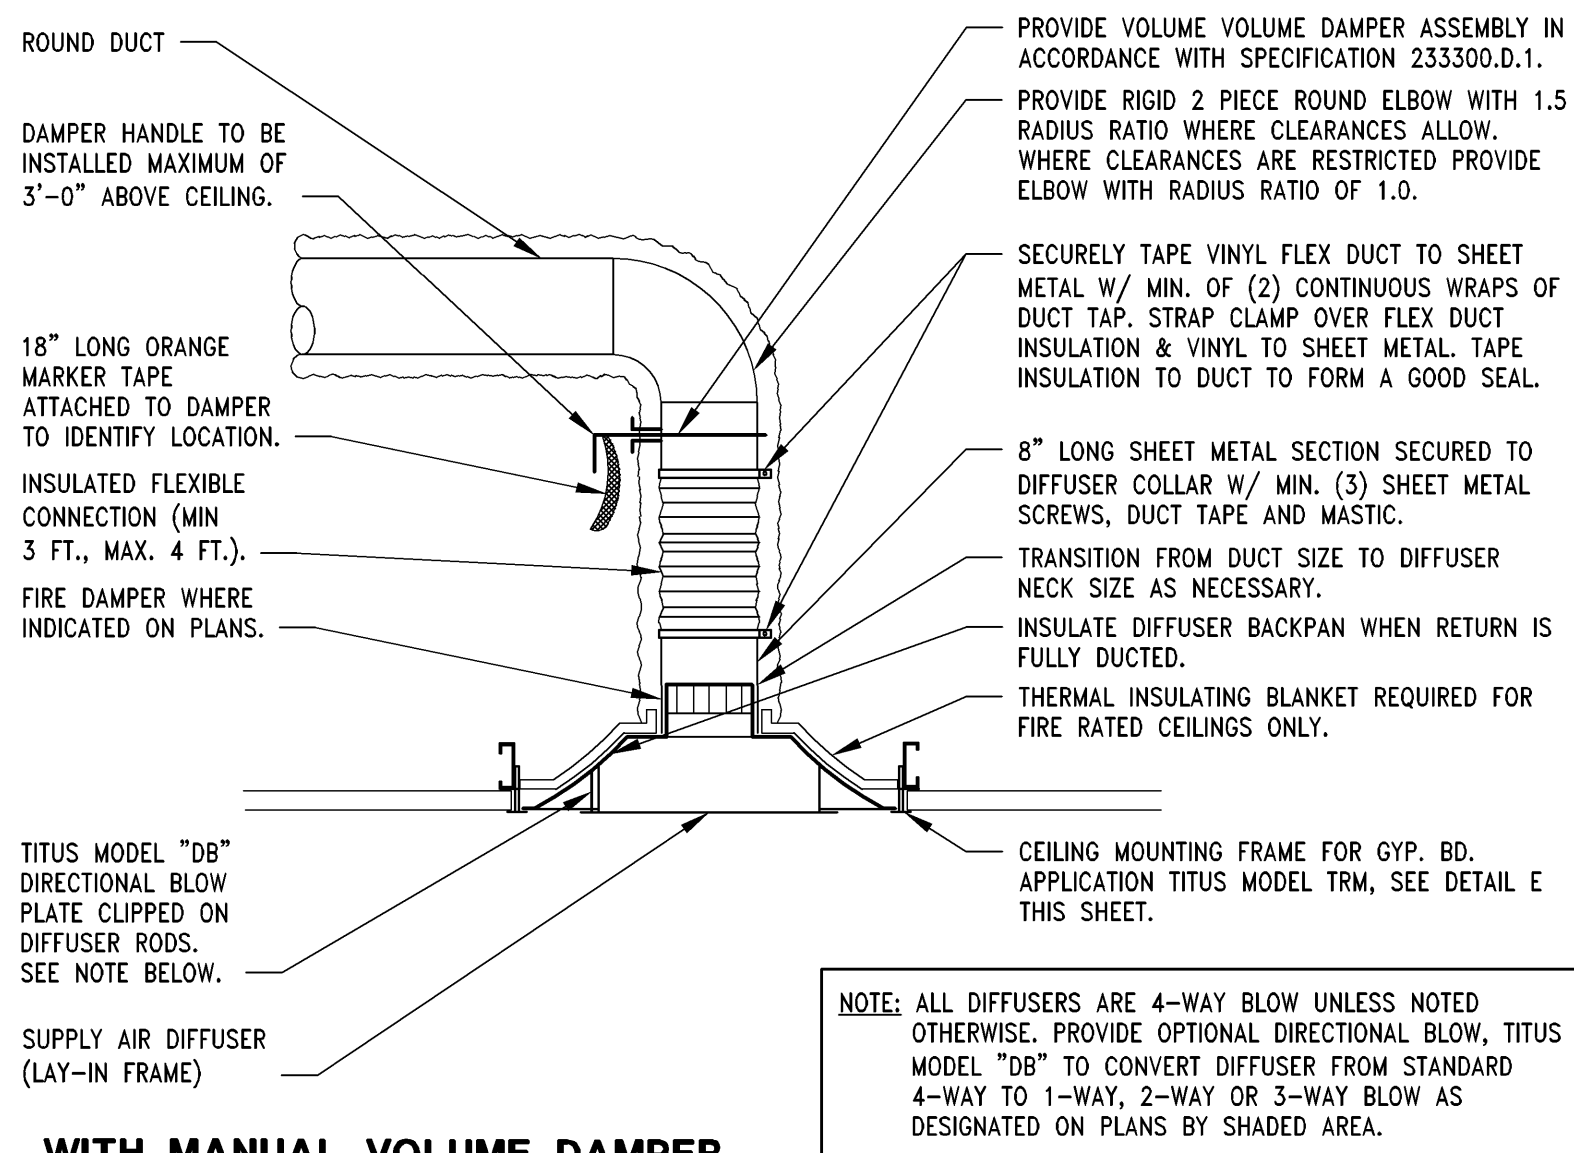

A
02/12/12