
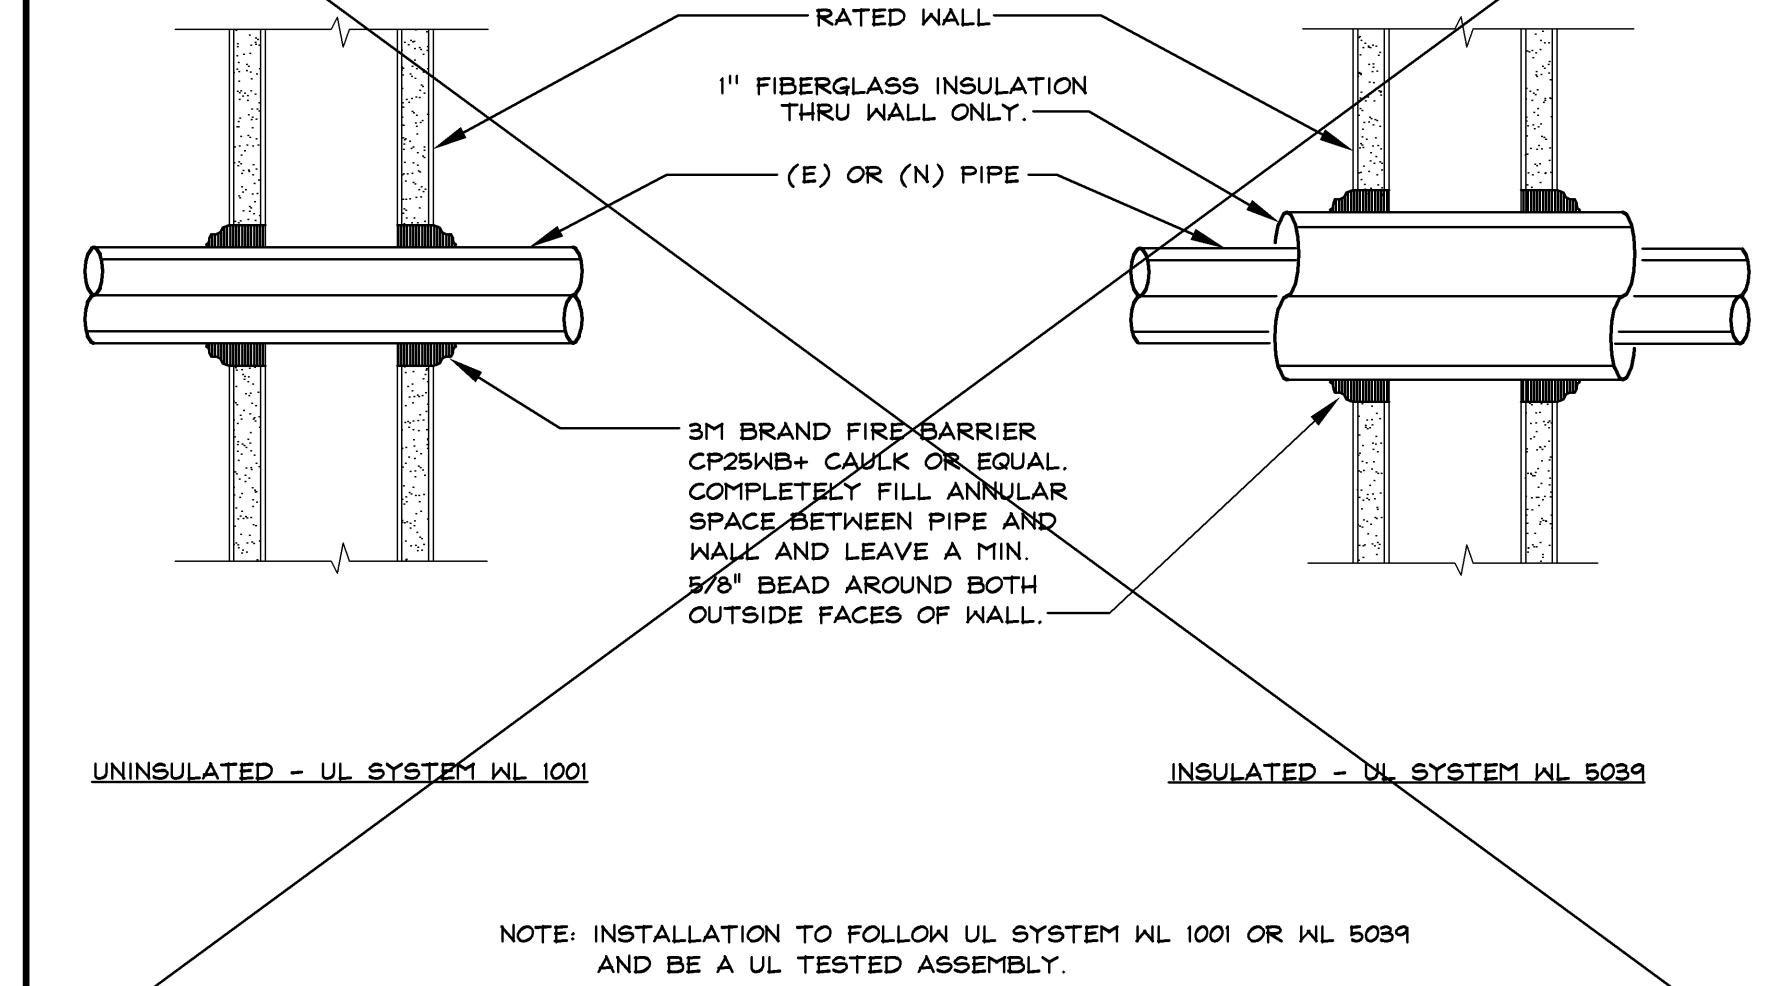




DREAMSTEAMER CONNECTIONS

VENT THRU ROOF

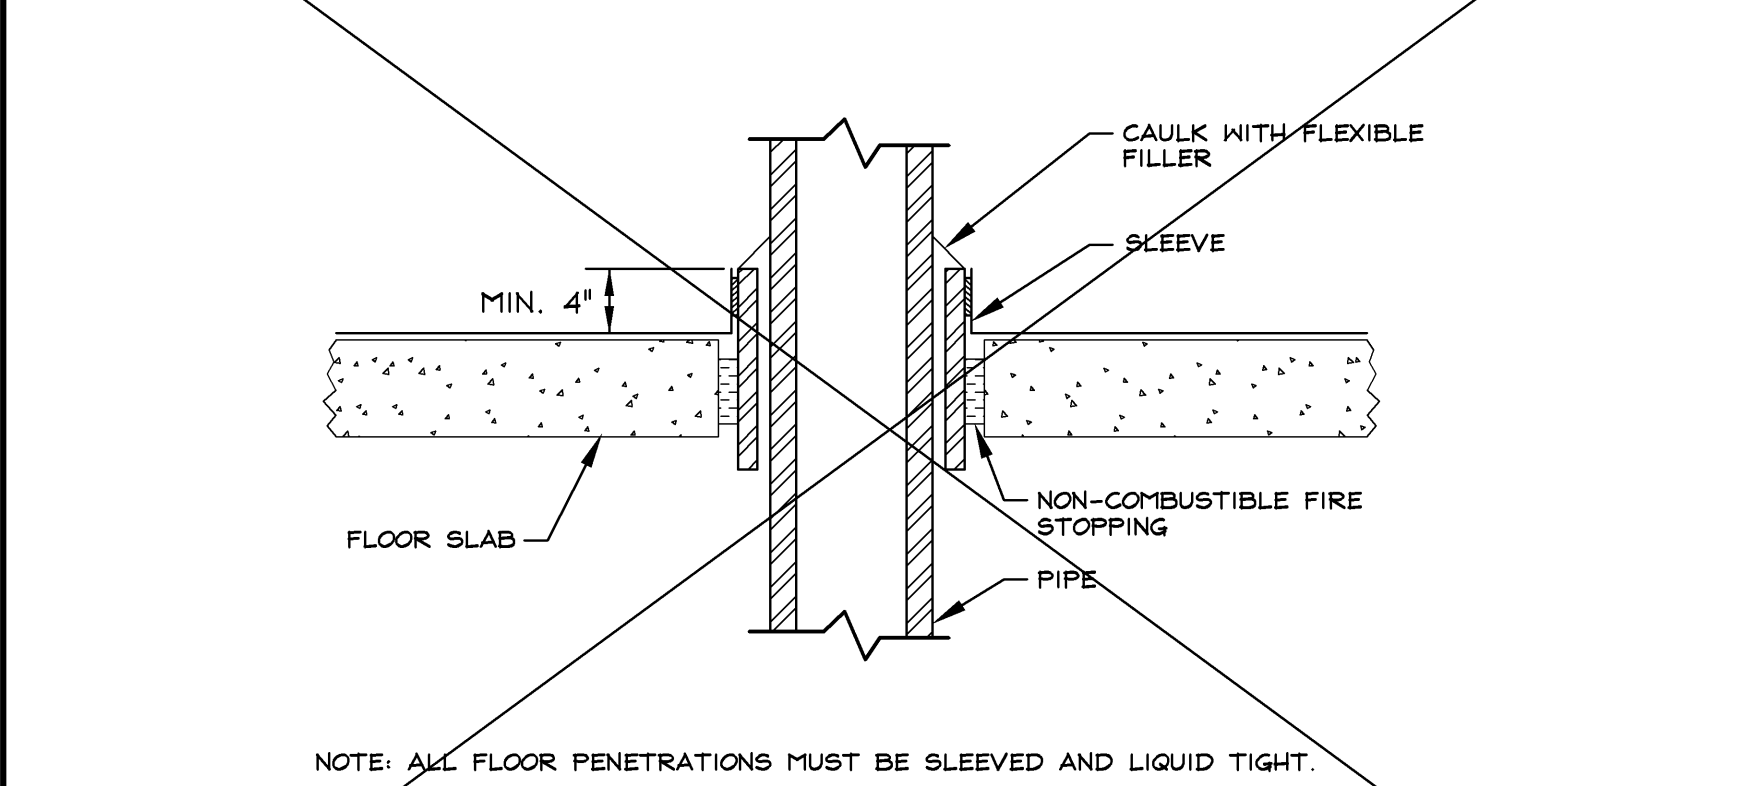




PIPE PENETRATION AT FLOOR

PIPE PENETRATION AT RATED WALL

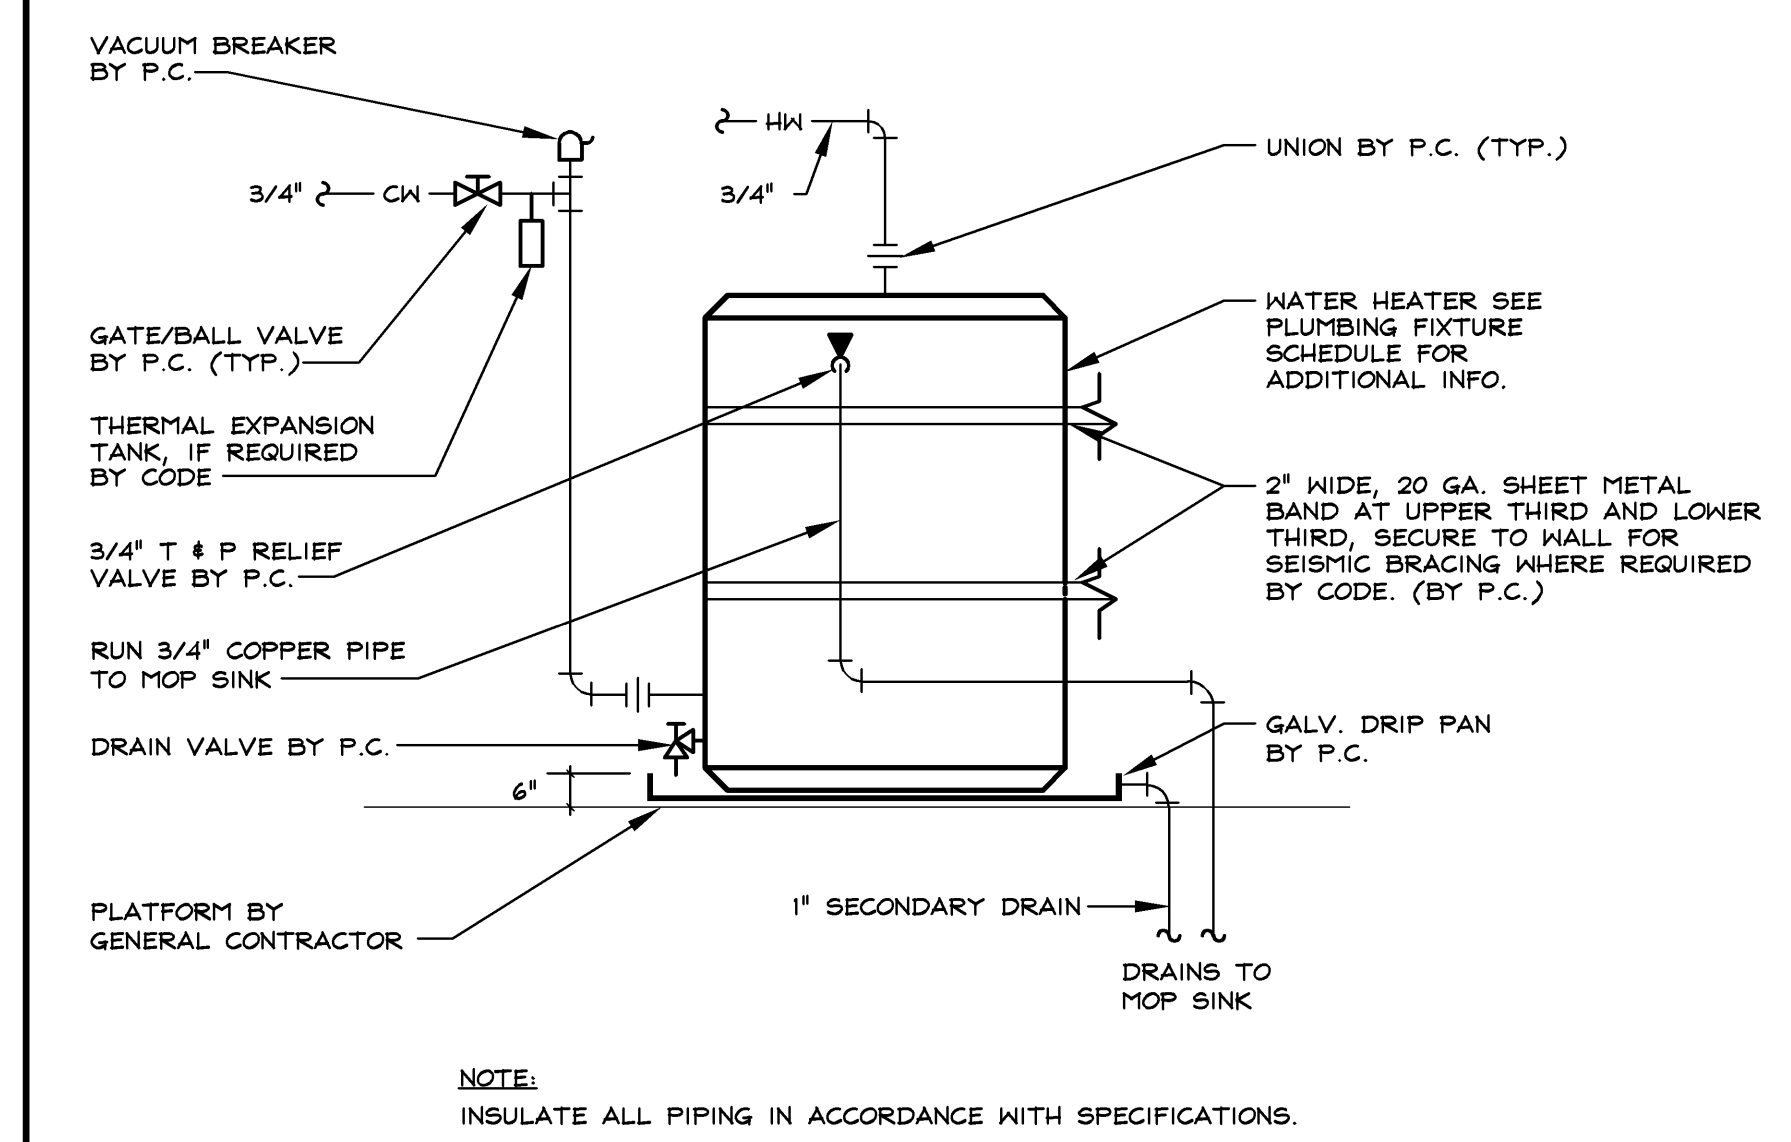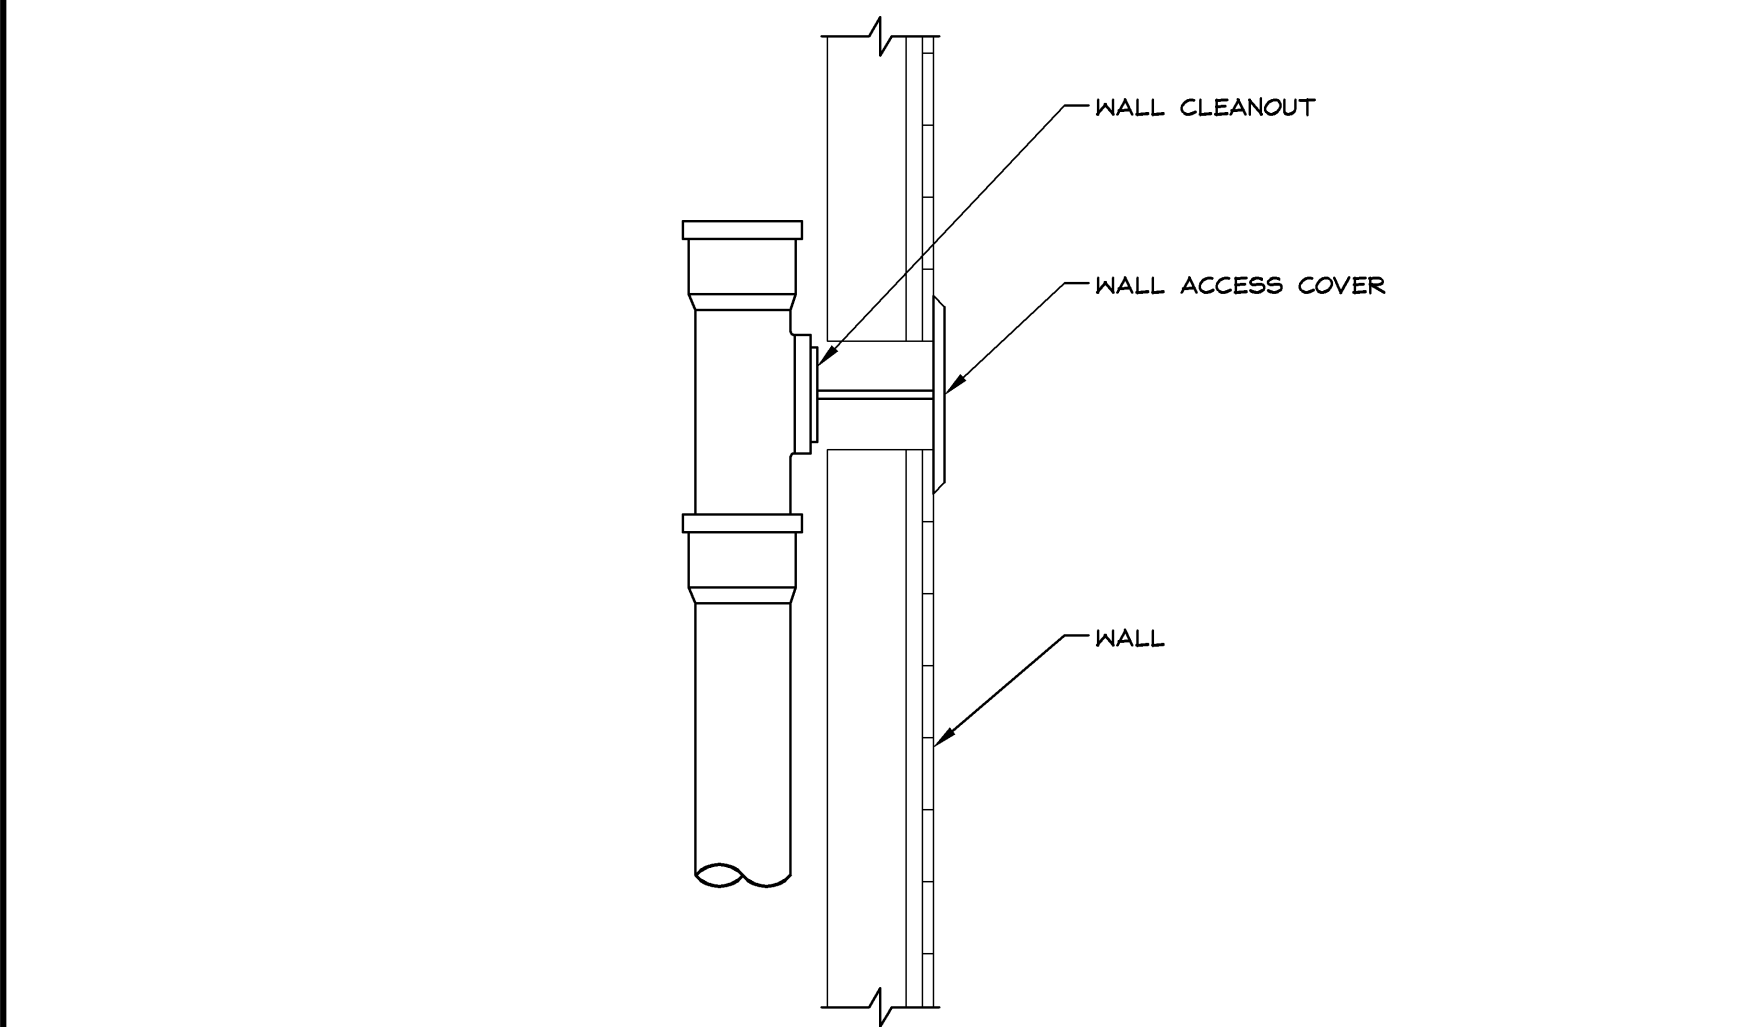

WALL CLEANOUT

WATER HEATER

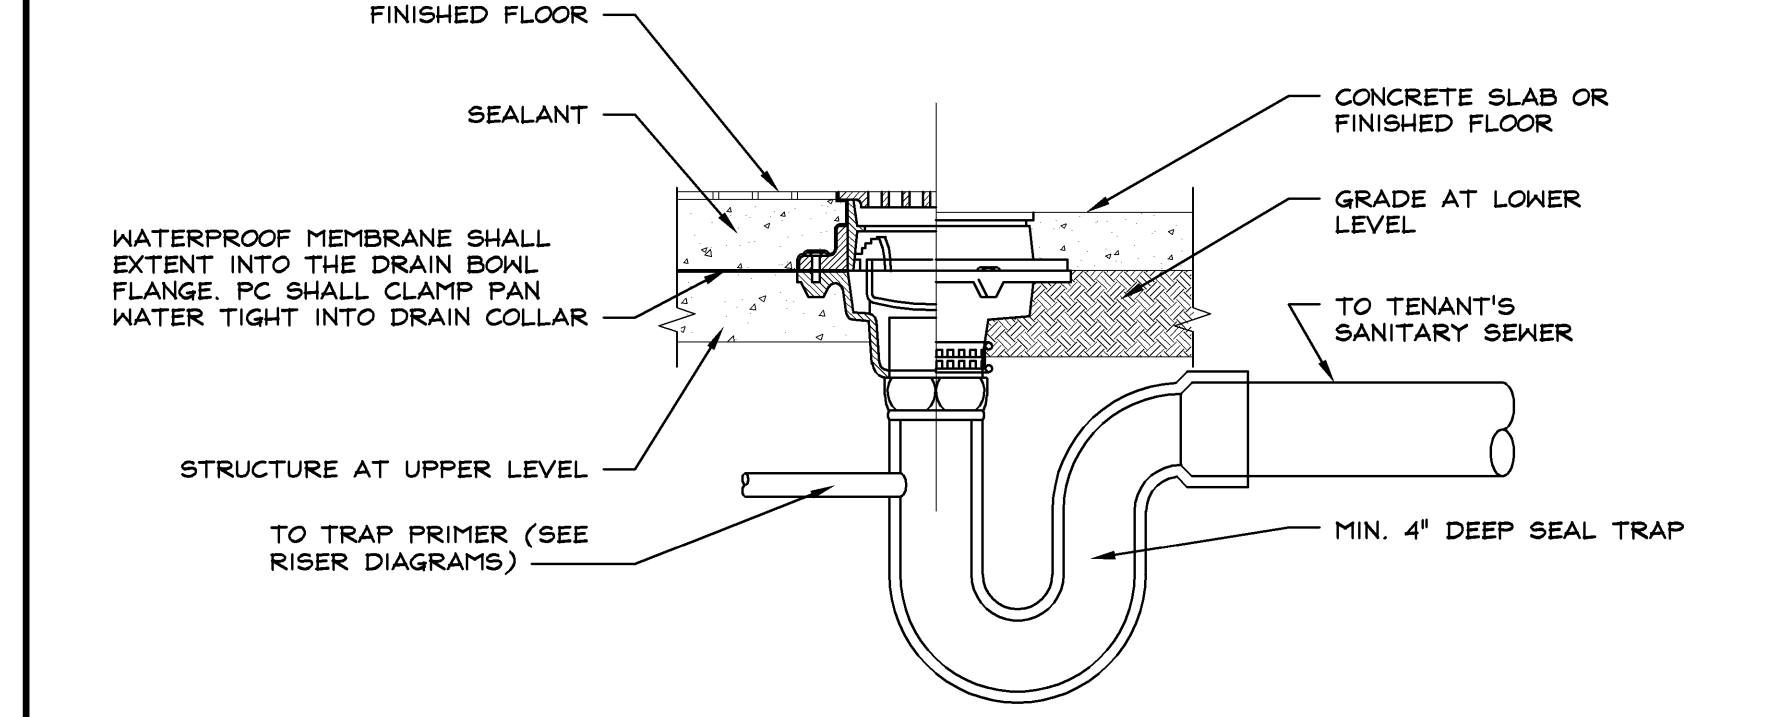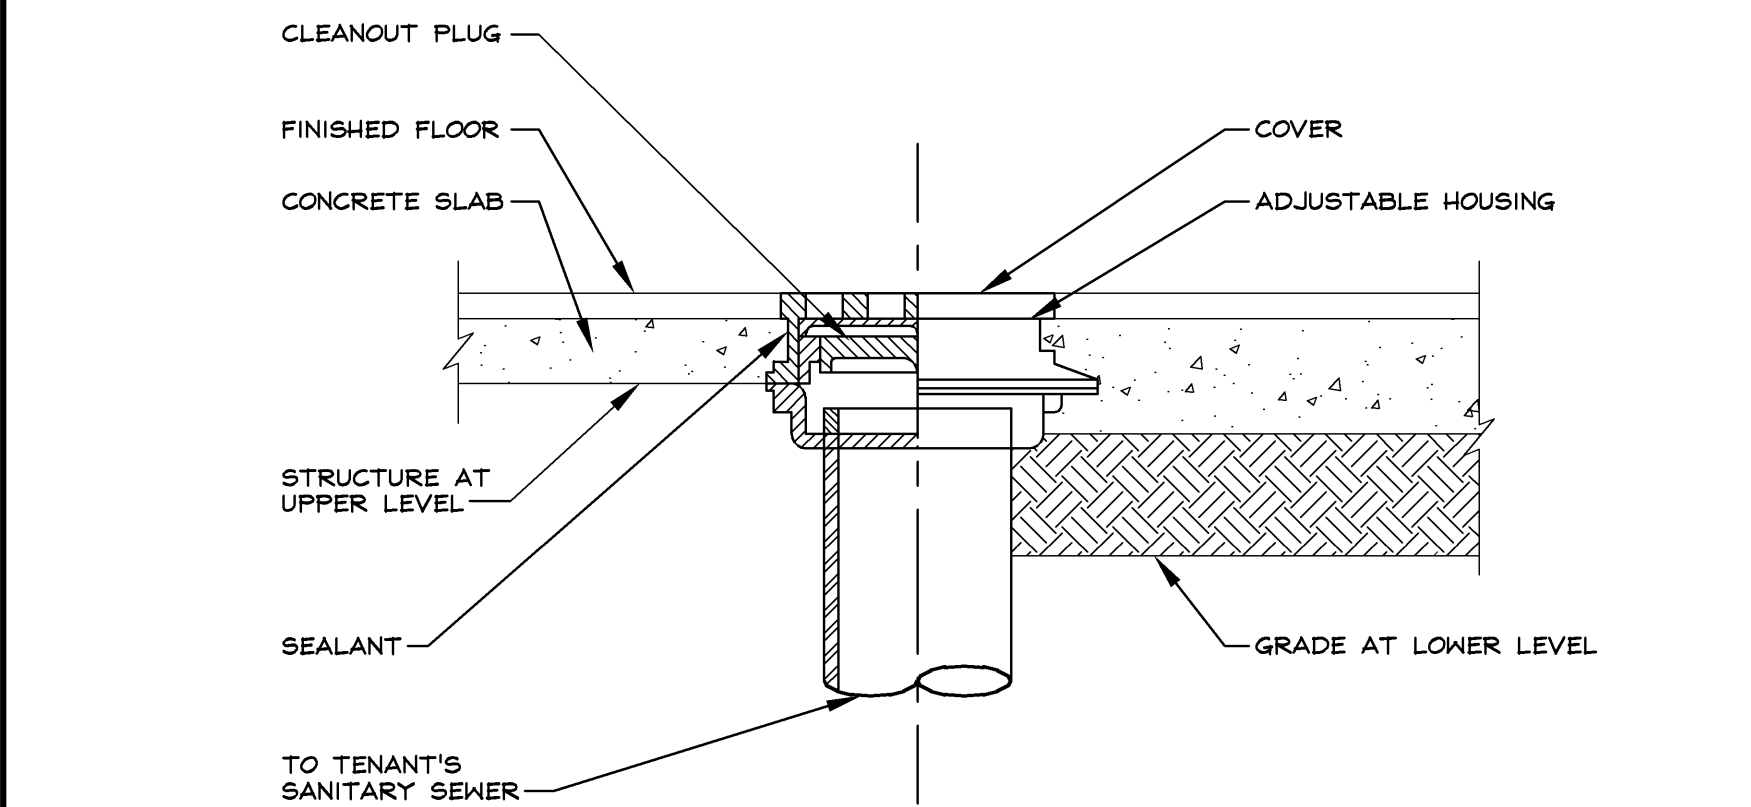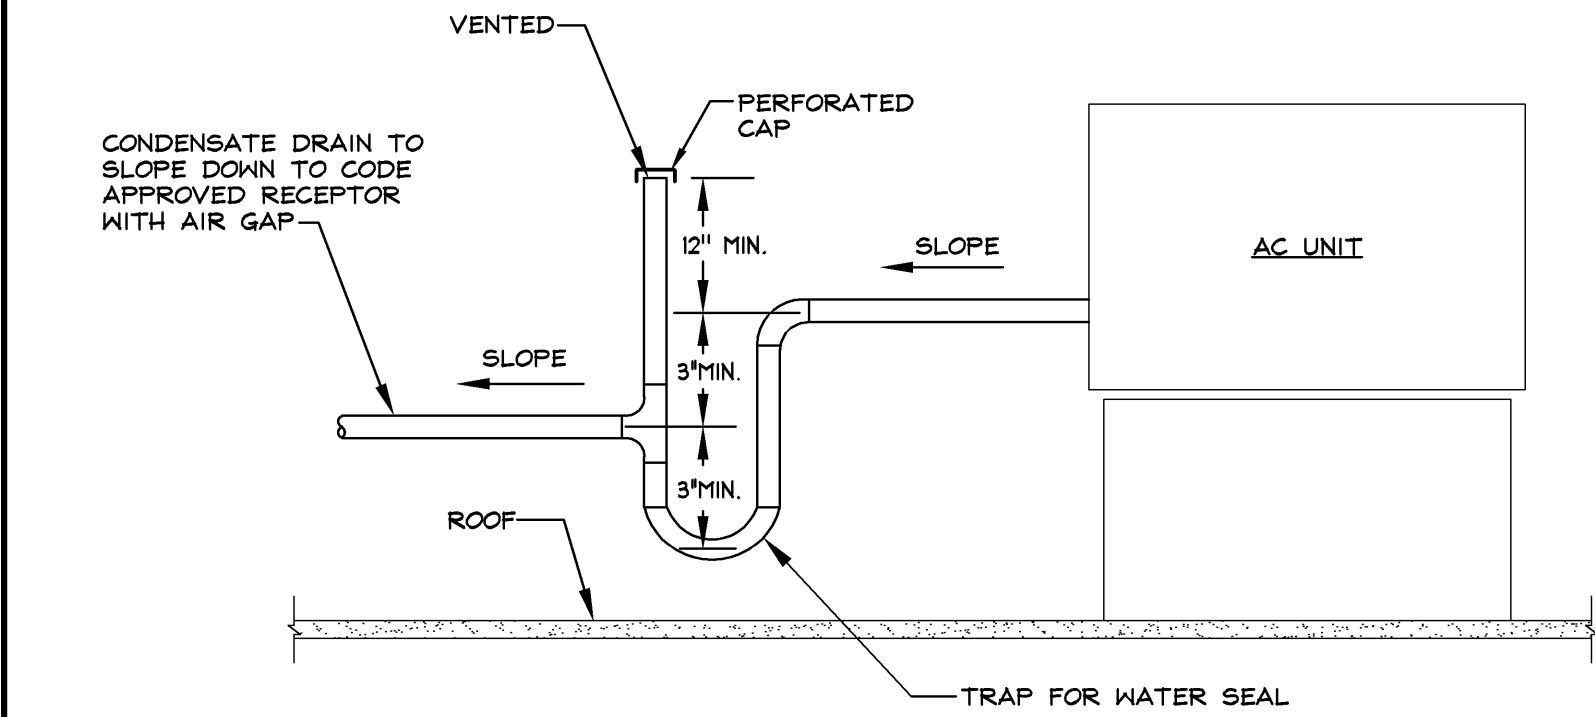

CONDENSATE DRAIN

FLOOR CLEANOUT

FLOOR DRAIN WITH TRAP PRIMER

1718

EXPRESS
OUTLET MALL OF SAVANNAH
200 TANKER OUTLET BLVD.
SPACE NO. 521
POOLER, GA 31322

PROJECT INFORMATION:
REQUIRED BY: DATE:
DESIGNED BY: GS
CHECKED BY: RD

REVISIONS:
1 INDICATES NO REVISION TO THIS SHEET

DATE ISSUED: 09/26/14
DESIGNED BY: GS
DRAWN BY: GS
CHECKED BY: RD

PLUMBING DETAILS

DRAWING NUMBER:
P03.1