

**Lbrands**  
STORE DESIGN & CONSTRUCTION  
Three Limited Parkway • Columbus, Ohio 43230  
Telephone: 614.415.7000 • Fax: 614.415.7349

PROJECT INFORMATION: 014200814  
**BATH & BODY WORKS**  
**WHITE BARN CANDLE CO.**  
**THE GARDENS MALL**  
 3101 PGA BOULEVARD  
 PALM BEACH GARDENS, FL 33410

ELITE CONSTRUCTION GROUP  
LAKE JACKSON, TX  
PHONE: 979-285-0712  
NOTE: THESE PRINTS HAVE BEEN  
REDUCED BY 50 PERCENT. SCALE  
WILL BE 50 PERCENT OF WHAT IS  
NOTED ON PLANS

## MECHANICAL DETAILS

DRAWING NUMBER:  
**M03.01**



**1 1/2" = 1'-0"**

00D-M0301-H00-GRIL



**1" = 1'-0"**

00D-M0301-D00-EXDT 09/13



NTS

10301-F01-DAMP 09/13/13



**3" = 1'-0"**

00D-M0301-G00-GRIL



NTS

00D-M0301-C00-EFAN 09/13



NTS

M0301-K01-PIPE 08/08/14



NTS

00D-M0301-F00-DAMP




NTS

00D-M0301-B00-DUCT



NTS

M0301-J03-UNIT

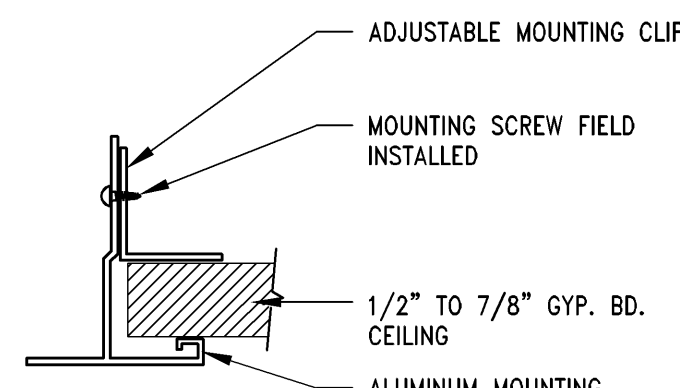

### DRYWALL CEILING DIFFUSER MOUNTING FRAME DETAIL

$$1'' = 1'-0''$$

00D-M0301-E00-FRME 02/18



NTS

00D-M0301-A00-DIFF