



SYMBOL	DESCRIPTION
	RECESSED DOWNLIGHT
	TRACK W/ TRACK HEADS
	FLUORESCENT STRIPS - SURFACE MOUNTED
	FLUORESCENT STRIPS - CHAIN-HUNG FROM STRUCTURE 12'-0" A.F.F.
	MULTI-LAMP RECESSED DOWNLIGHT
	SURFACE MOUNTED FLUORESCENT LIGHT W/ ACRYLIC LENS
	EGRESS SIGNAGE
	BBW EMERGENCY LIGHT
	SPEAKER
	SUPPLY DIFFUSER
	RETURN AIR GRILLE
	CEILING ACCESS PANEL
	EXHAUST AIR REGISTER
	PENDANT LIGHT - MOUNTED 7'-6" A.F.F.
	BILLBOARD LIGHT
	CCTV VIEWING MONITOR
	CCTV CAMERA - SUPPLIED AND INSTALLED BY SECURITY VENDOR
	TRAFFIC COUNTER
	SCENT AIR - WBC ORDERED IN BLACK WITH 10'-0" CORD SET ON TOP OF WBC-ABY
	WBC EMERGENCY LIGHT - PAINTED PT-92

- NOTES:
- ALL CEILING HEIGHTS ARE FROM THE TOP OF FINISH FLOOR TO UNDERSIDE OF FINISH CEILING.
  - PROVIDE ADEQUATE CLEARANCES FOR FIXTURES, DUCTS, CEILINGS, AND RELATED PERTINENT ITEMS NECESSARY TO MAINTAIN THE SPECIFIED HEIGHTS ABOVE FINISH FLOOR.
  - ADDITIONAL HANGER AND SAFETY WIRES FOR LIGHT FIXTURES, SPEAKERS AND DUCTWORK, AS REQUIRED BY LOCAL CODES, TO BE THE RESPONSIBILITY OF THE CEILING SUBCONTRACTOR.
  - SPRINKLER HEAD LAYOUT TO CONFORM TO LOCAL CODE, TAKING IN ACCOUNT LOCATIONS OF DUCTWORK, LIGHTING AND LOCATION OF TENANT'S CABINET, FIXTURE AND SHELVING UNITS.
  - SPRINKLER HEAD COLORS AT WHITE BARN.
  - 4.1.1. CEILING SF-90: SPRINKLER TO MATCH BENJAMIN MOORE NO AF-5 FROSTINE
  - 4.1.2. CEILING SF-90: SPRINKLER HEAD TO MATCH SHERWIN WILLIAMS SW6258 TRICORN BLACK
  - 4.1.3. CEILING SF-90: SPRINKLER HEAD TO MATCH BENJAMIN MOORE AF-716 DOLPHIN
  - ARCHITECTURAL DRAWINGS DETERMINE LOCATION OF LUMINAIRES AND SUPERSEDE ALL OTHERS' U.O.N.
  - AFTER INSTALLATION, ELECTRICAL CONTRACTOR IS TO TILT THE LAMPS PER LIGHT AIMING GUIDELINES TOWARD WALL OR CABINETS.
  - SEE LIGHT FIXTURE SCHEDULE ON ELECTRICAL DRAWINGS FOR FIXTURE MODEL NUMBERS KEYED TO THE LIGHTING AND CEILING LEGEND.
  - NO EMERGENCY LIGHTS, EXIT LIGHTS OR SENSORS ARE TO BE PLACED ON THE PERIMETER SALES WALLS.
  - "PAINT TRIM EQ, BH-1, BH-2, SPEAKERS DIFFUSERS, EMERGENCY LIGHT AND EXIT SIGN MOUNTING PLATES TO MATCH ADJACENT CEILING FINISHES.


CEILING AND LIGHTING LEGEND	1/4" = 1'-0"	R
	42D-A041-L01-LGND	04.26.10

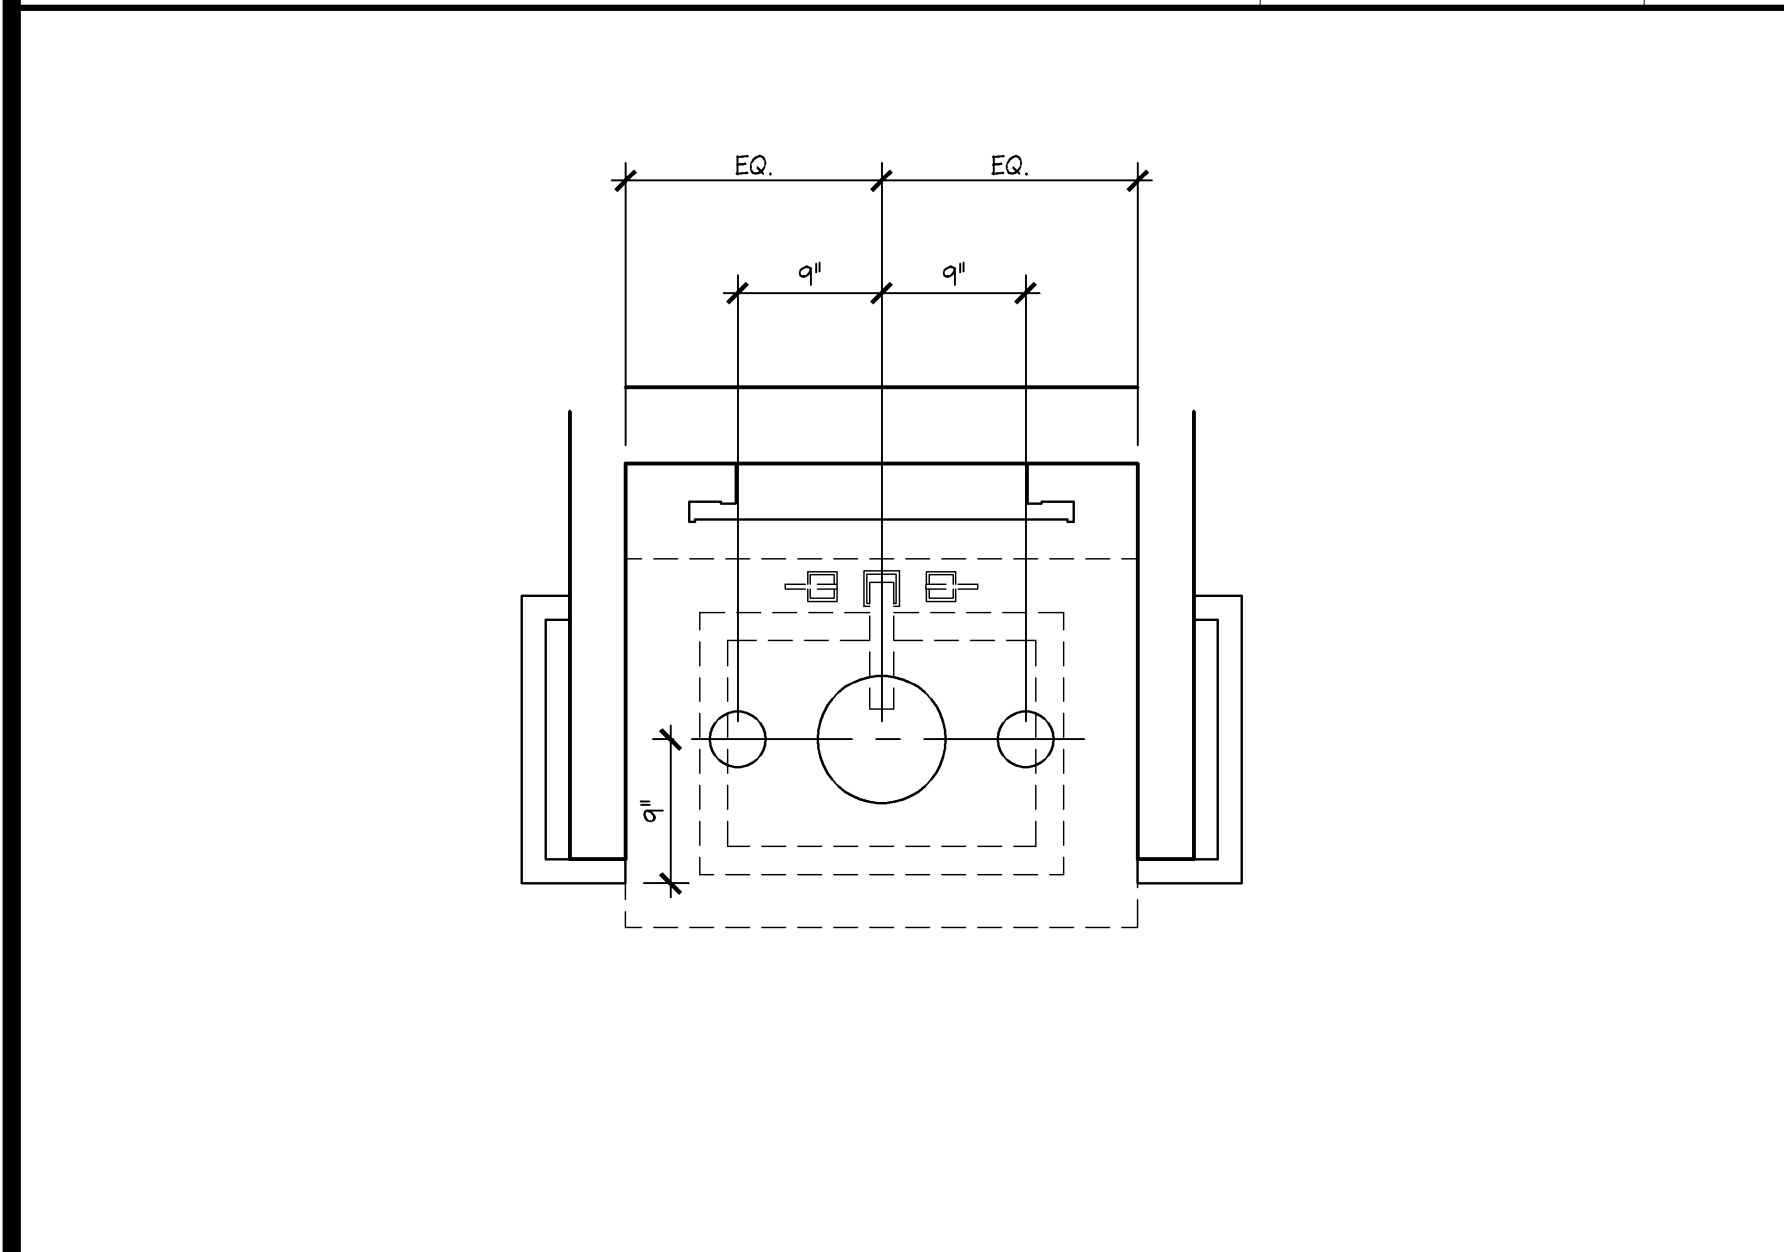


ENLARGED RCP AT ARCHITECTURAL NARROW DEMO SINK	1" = 1'-0"	P
	42D-A041-D01-DETL	03.16.12

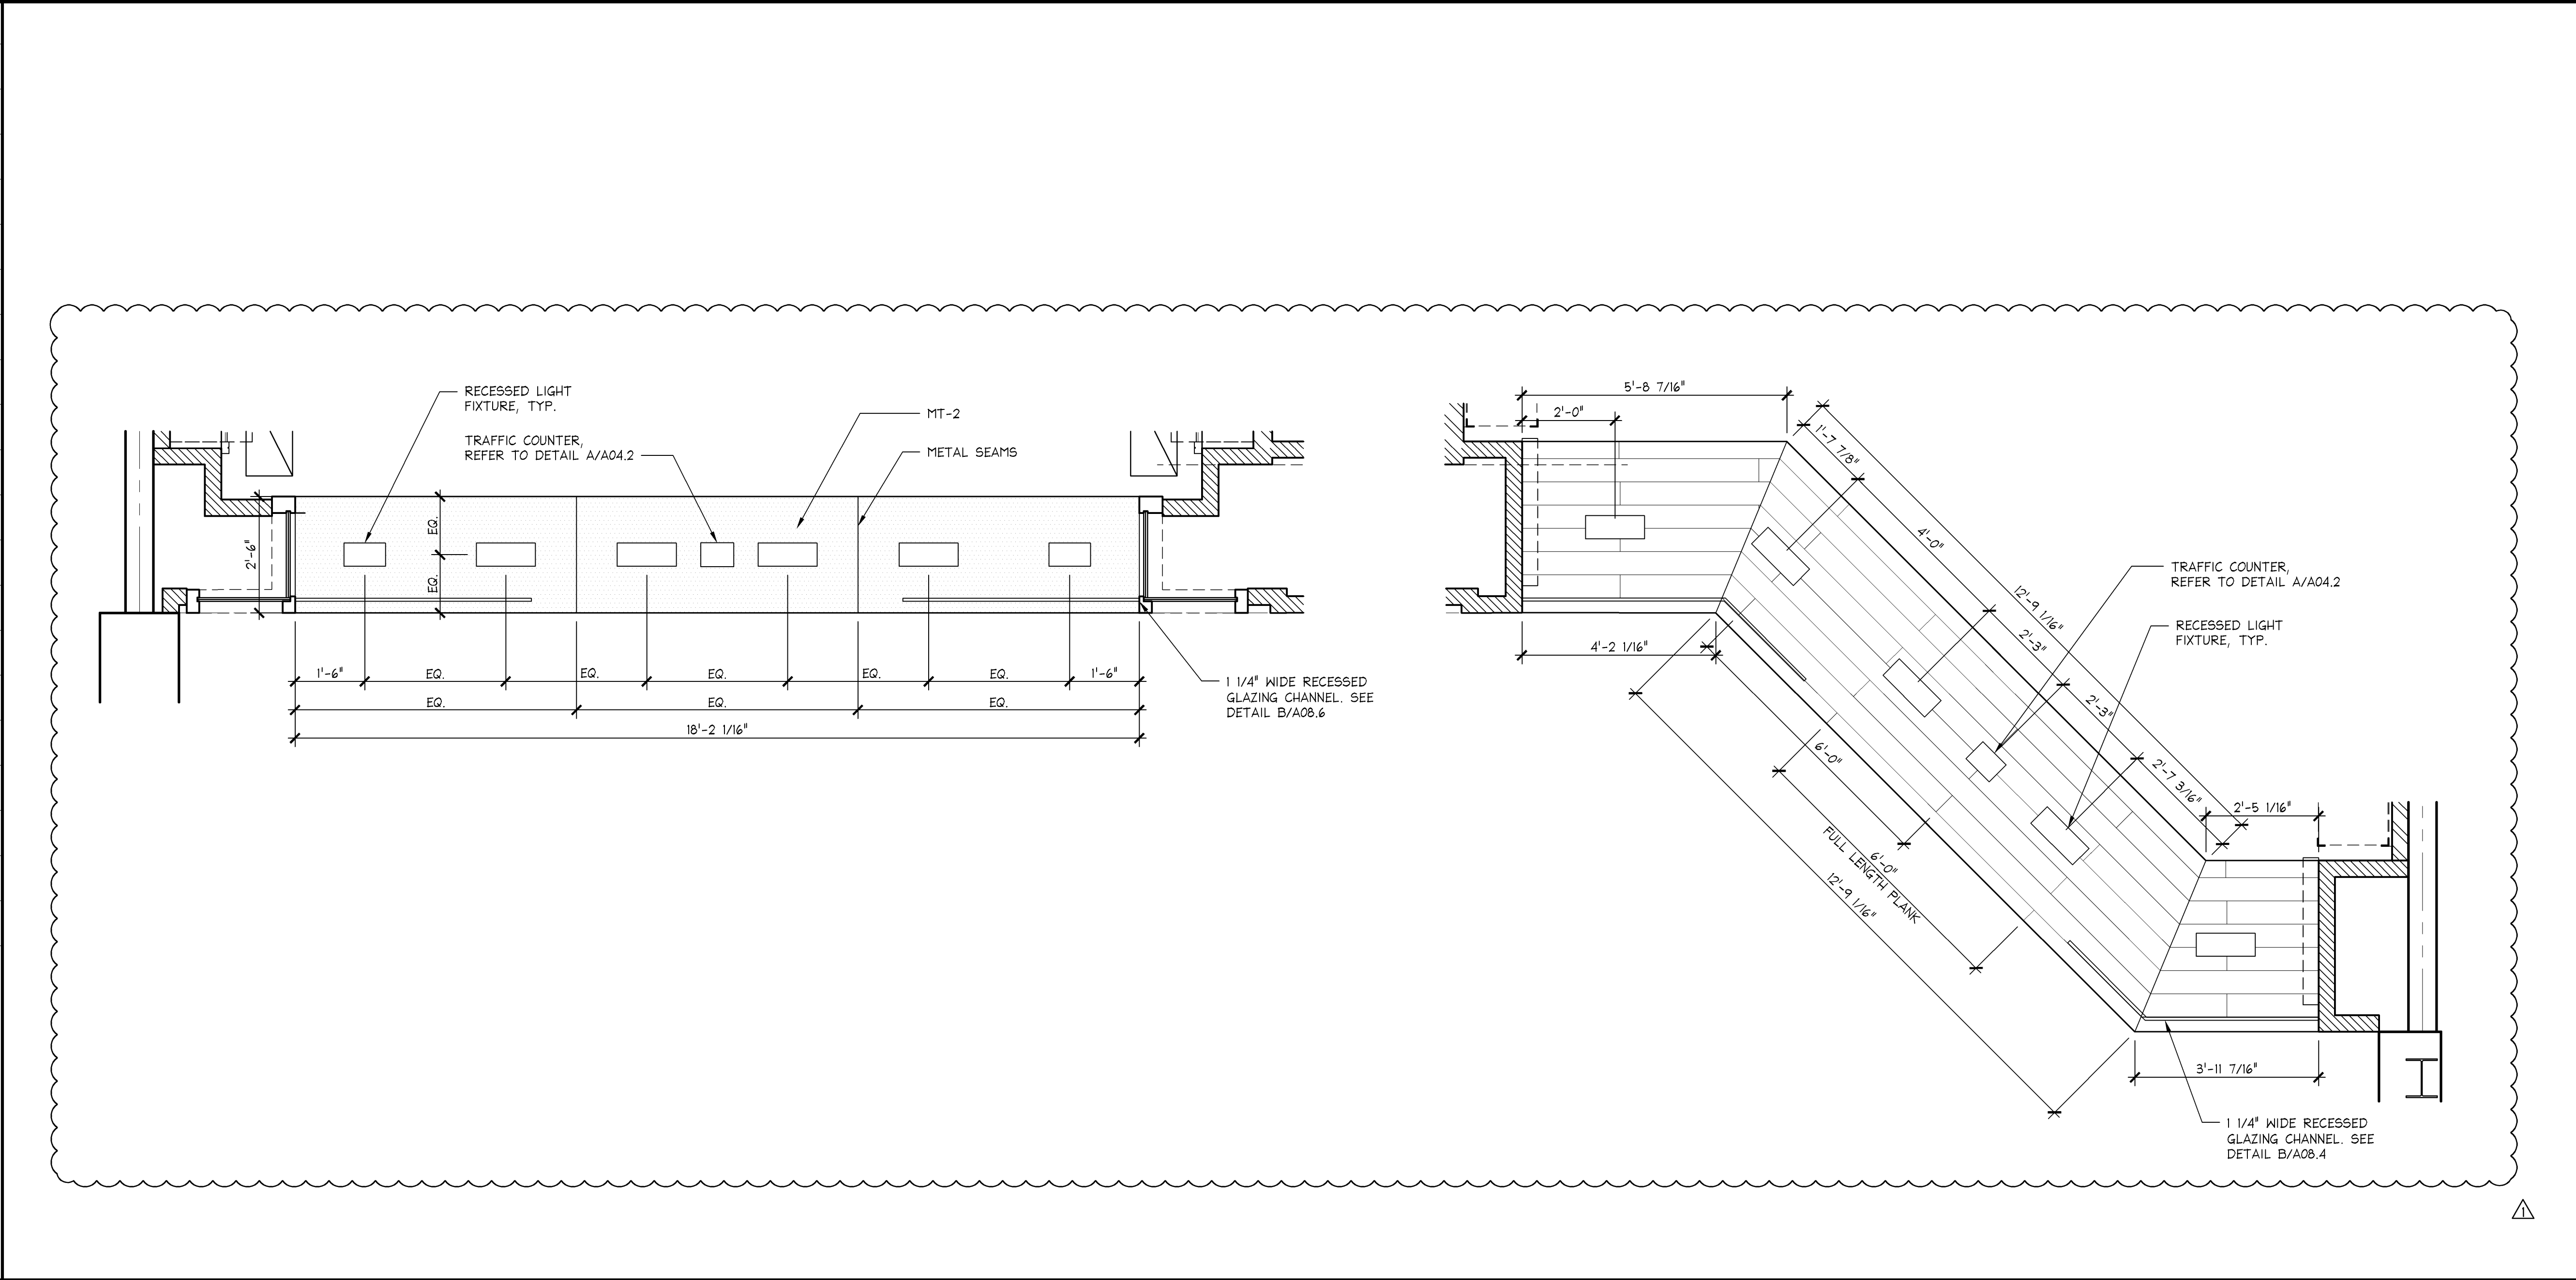

METAL SEAMS @ CANOPY CEILING	1/2" = 1'-0"	C
	42D-A041-C01-DETL	11.18.10

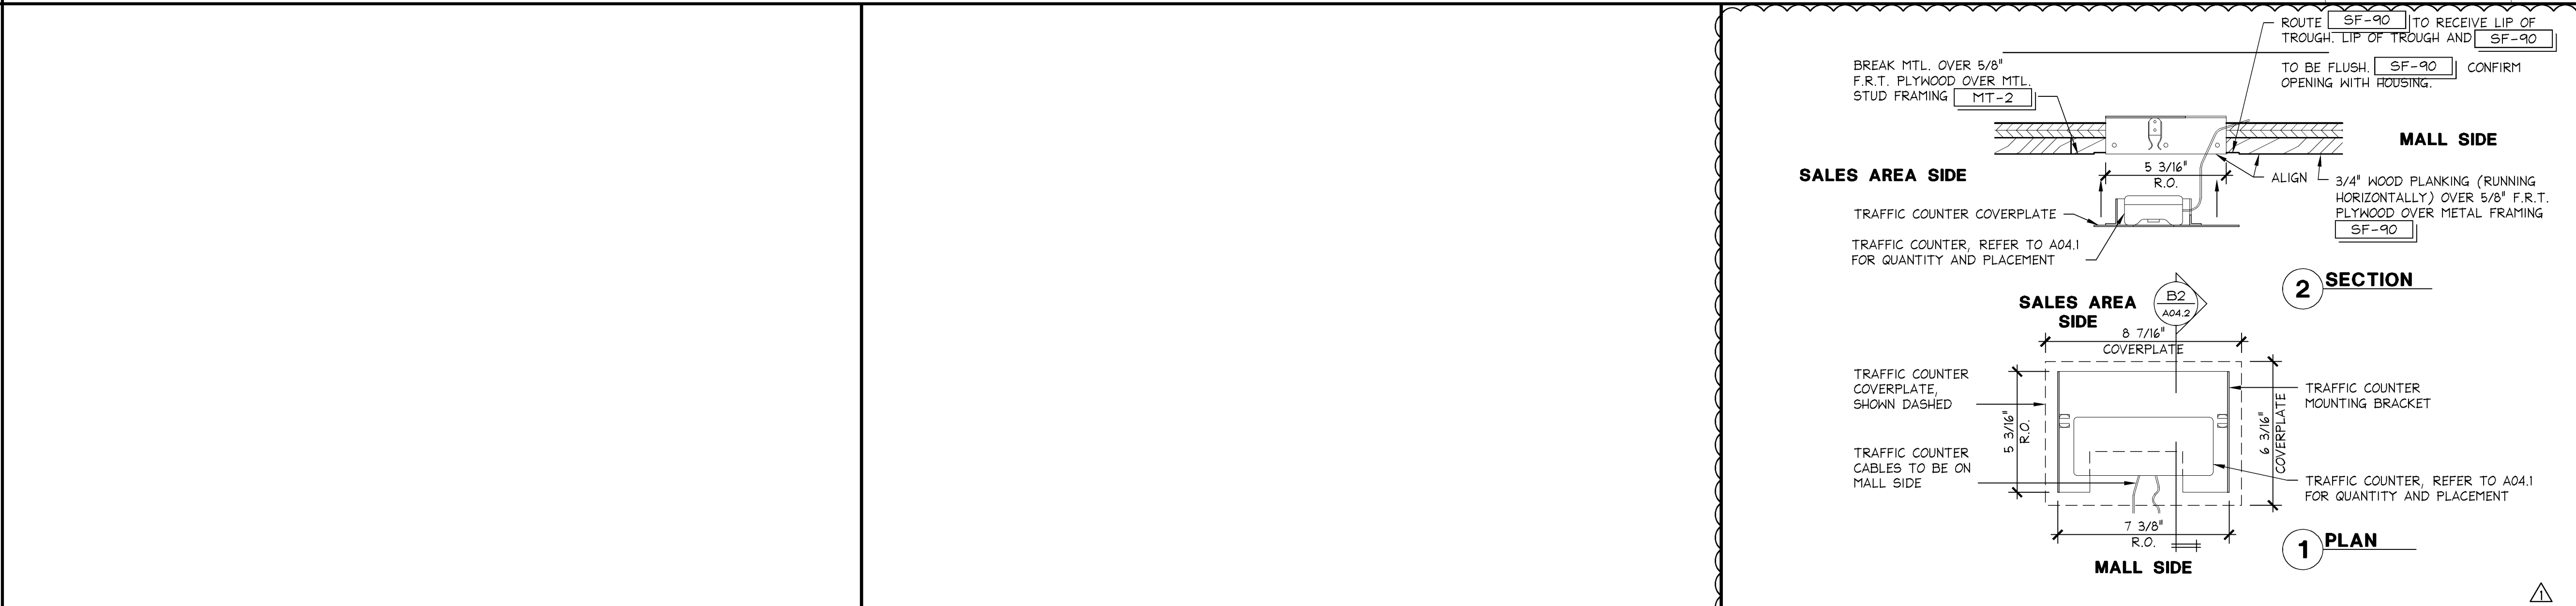

WBC TRAFFIC COUNTER MOUNTING DETAIL	3" = 1'-0"	B
	42D-A088-H00-DETL	11.06.14

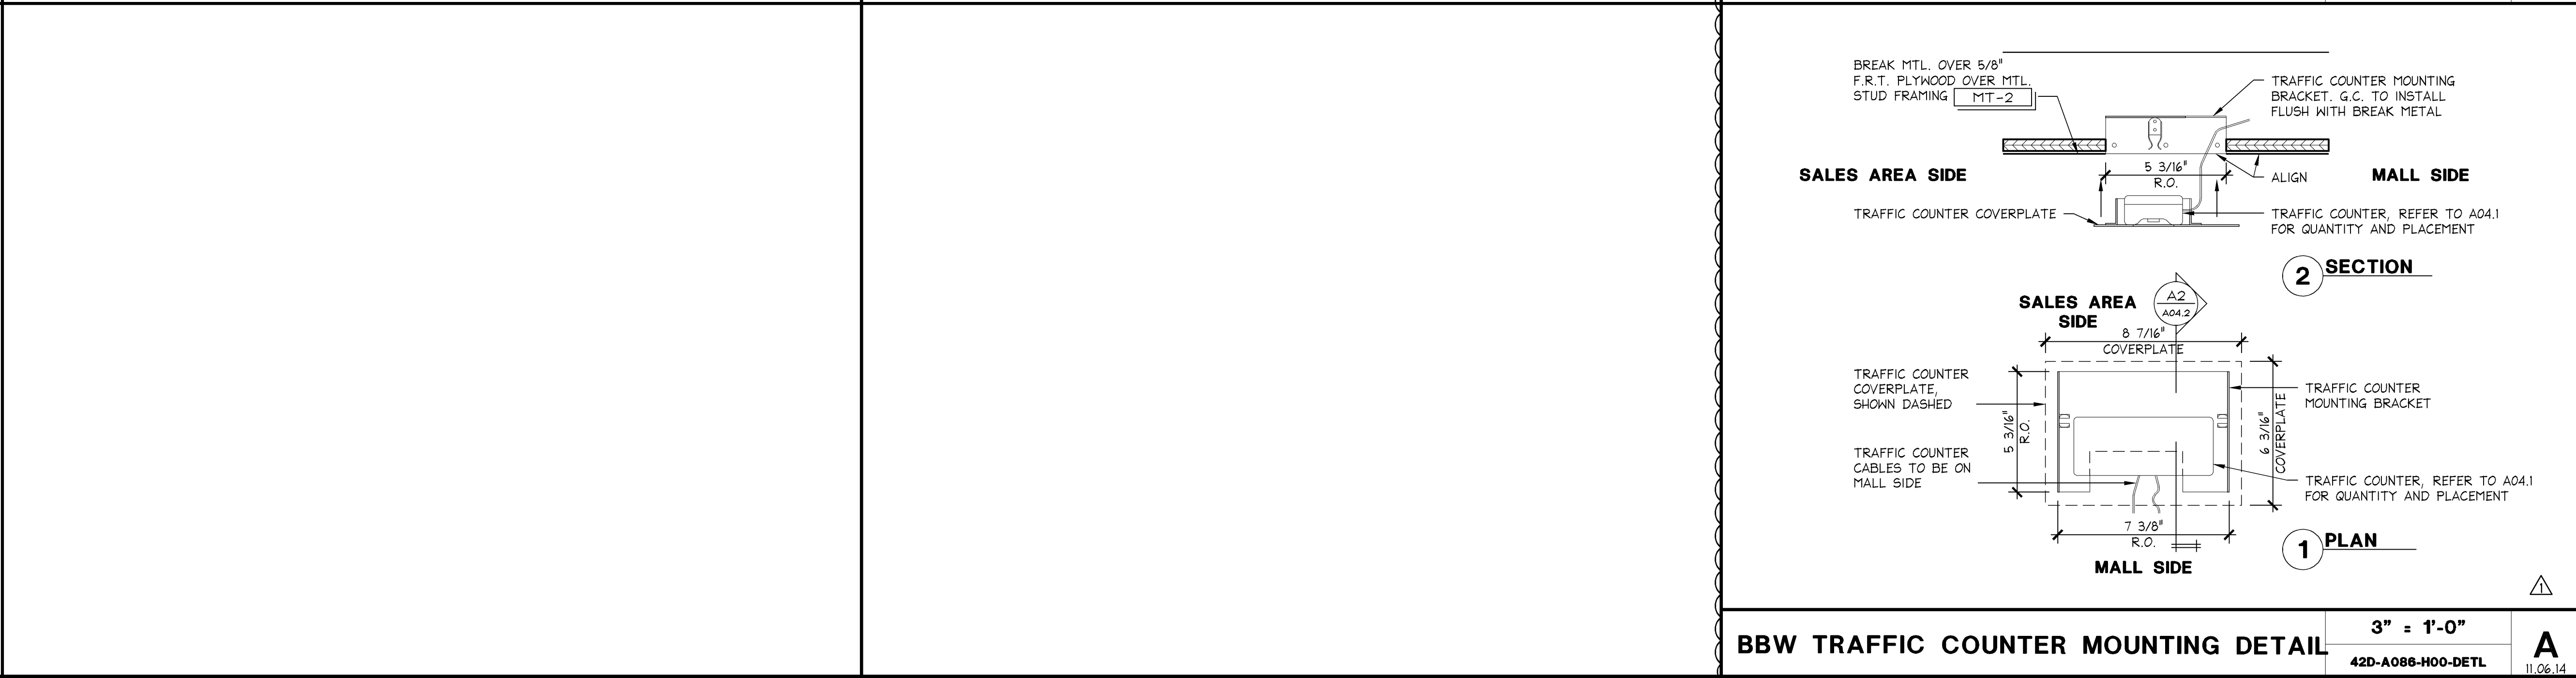

BBW TRAFFIC COUNTER MOUNTING DETAIL	3" = 1'-0"	A
	42D-A088-H00-DETL	11.06.14

MOODY•NOLAN  
responsive architecture  
300 Spruce Street Phone: (614) 461-4664  
Suite 300 Fax: (614) 280-8881  
Columbus, Ohio 43215 www.moodynolan.com

Lbrands  
STORE DESIGN & CONSTRUCTION  
Three Limited Parkway • Columbus, Ohio 43230  
Telephone: 614.415.7000 • Fax: 614.415.7349

THESE DRAWINGS AND SPECIFICATIONS WERE PREPARED FOR USE ON A SPECIFIC SITE. ANY REUSE OF THESE DRAWINGS OR SPECIFICATIONS FOR ANY OTHER PROJECT WITHOUT THE WRITTEN PERMISSION OF MOODY•NOLAN IS PROHIBITED. THE USER OF THESE DRAWINGS AND SPECIFICATIONS SHALL BE RESPONSIBLE FOR OBTAINING ALL NECESSARY PERMITS AND APPROVALS FROM THE APPROPRIATE AGENCIES. THE USER OF THESE DRAWINGS AND SPECIFICATIONS SHALL BE RESPONSIBLE FOR OBTAINING ALL NECESSARY PERMITS AND APPROVALS FROM THE APPROPRIATE AGENCIES. THE USER OF THESE DRAWINGS AND SPECIFICATIONS SHALL BE RESPONSIBLE FOR OBTAINING ALL NECESSARY PERMITS AND APPROVALS FROM THE APPROPRIATE AGENCIES.

014200814  
BATH & BODY WORKS  
WHITE BARN CANDLE CO.  
THE GARDENS MALL  
3101 PGA BOULEVARD  
PALM BEACH GARDENS, FL 33410  
FULL RENO PACKAGE:  
EASTON-G GENERATION:  
00061214 A/E PROJECT #:  
SCOPE:  
DESIGN TYPE:  
LSDMC PROJECT #:

REVISIONS:  
DATE: 12/31/14  
ELITE CONSTRUCTION GROUP  
LAKE JACKSON, TX  
PHONE: 979-285-0712  
NOTE: THESE PRINTS HAVE BEEN  
REDUCED BY 50 PERCENT. SCALE  
WILL BE 50 PERCENT OF WHAT IS  
NOTED ON PLANS

DATE ISSUED: 10/24/2014  
DESIGNED BY: BN  
DRAWN BY: TSG  
CHECKED BY: HS

REFLECTED  
CEILING PLAN

DRAWING NUMBER:  
A04.2