


- 27 4"x4" JUNCTION BOX MOUNTED AT 60" AFF WITH 1-1/4" CONDUIT (WITH BUSHING) TO CEILING FOR BURGULAR ALARM. VERIFY EXACT LOCATION LOCATION WITH LSSDC PRIOR TO WORK COMMENCEMENT.
- 28 INSTALL WALL MOUNTED MOTION DETECTOR AT REAR EXIT AND NEXT TO BURGULAR ALARM AT 7' AFF. VERIFY EXACT LOCATIONS WITH LSSDC PROJECT MANAGER PRIOR TO WORK COMMENCEMENT.
- 29 KEYPAD FOR SECURITY SYSTEM, MOUNTED AT 44" AFF, ON WALL, ON HANDLE-SIDE OF NON-SALES DOOR LEADING TO SALES AREA, AND 3/4" CONDUIT FROM JUNCTION BOX TO ABOVE CEILING.
- 30 INSTALL CEILING MOUNTED MOTION DETECTOR IN EACH STOREFRONT ROOM WITH AN ENTRANCE AND IN FRONT OF EVERY CASHWRAP. VERIFY EXACT COLOR AND LOCATIONS WITH LSSDC PROJECT MANAGER PRIOR TO WORK COMMENCEMENT.
- 31 DOOR CONTACT. GENERAL CONTRACTOR SHALL FURNISH AND INSTALL JUNCTION BOX AND 3/4" CONDUIT FROM ABOVE CEILING TO 6" FRO DOOR, ALIGNED WITH TOP OF DOOR FOR SWING DOORS.
- 32 INSTALL CURTAIN WALL MOUNTED MOTION DETECTOR AT EACH ENTRY/ROLLING GRILLE. VERIFY EXACT LOCATIONS WITH LSSDC PROJECT MANAGER PRIOR TO WORK COMMENCEMENT.
- 33 FIRE ALARM CONTROL PANEL WITH BATTERY BACK-UP AND MINIMUM OF 6 ZONES FURNISHED AND INSTALLED BY FIRE ALARM CONTRACTOR. FIRE ALARM CONTROL PANEL SHALL BE TIED-IN WITH EXISTING WALL CENTRAL FIRE ALARM SYSTEM. CONTRACTOR SHALL COORDINATE FINAL SEQUENCES OF OPERATION WITH LANDLORD ENGINEER.
- 34 FIRE ALARM DEVICE FURNISHED AND INSTALLED BY FIRE ALARM CONTRACTOR, WIRED BY ELECTRICAL CONTRACTOR. REFER TO SPECIFICATION FOR MOUNTING HEIGHTS.
- 35 HOME RUN-TO-IP CABINET-LOCATED IN NON-SALES AREA.
- 36 SECURITY CAMERA DEVICE. HOME RUN SPECIFIED IN DETAIL D/E04.02.
- 37 KEYPAD FOR IP CAMERA SYSTEM, MOUNTED WITH TOP AT 48" AFF AT LATCH-SIDE OF BACK EXIT DOOR, AND WITH 1/2" CONDUIT UP TO JUNCTION BOX ABOVE CEILING.
- 38 INSTALL BUTTON FOR IP CAMERA SYSTEM ON WALL ADJACENT TO A.L.L. SYSTEM AT 48" A.F.F. COORDINATE EXACT LOCATION WITH LSSDC'S PROJECT MANAGER.
- 39 ROUTE 1/2" CONDUIT BACK TO IP CABINET.
- 40 PROVIDE GFI RECEPTACLE MOUNTED 12" CENTERED UNDER LAV FOR SENSOR ACTIVATED FAUCET.

- TBA**
Thorson • Baker + Associates
CONSULTING ENGINEERS
- 3030 West Streetsboro Road (330) 659-6688 Ph.
Richfield, Ohio 44286 (330) 659-6675 Fax

Lbrands
STORE DESIGN & CONSTRUCTION
Three Limited Parkway • Columbus, Ohio 43230
Telephone: 614.415.7000 • Fax: 614.415.7349

NTS	D 09/25/12
-	

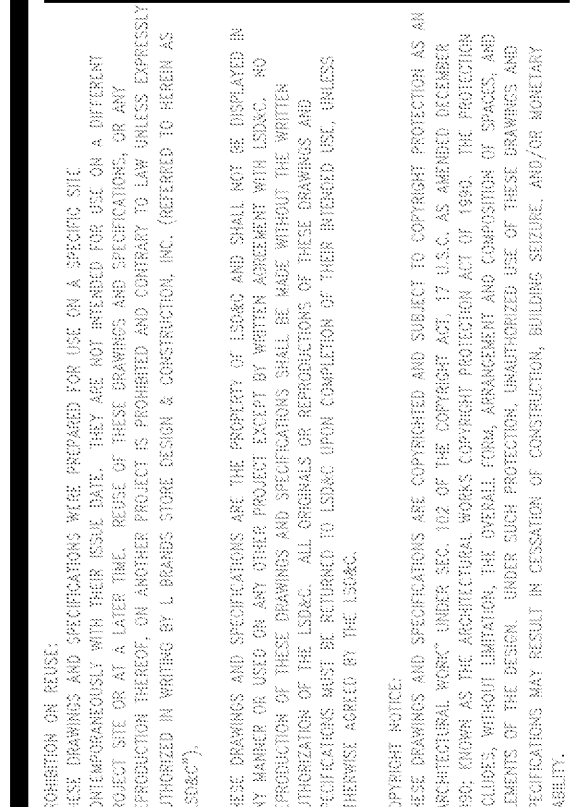

PROJECT INFORMATION:

0105000587

VICTORIA'S SECRET

NORTH POINT MALL

SPACE #1050

1000 NORTH POINT CIRCLE

ALPHARETTA, GA 30022

SCOPE:

DESIGN TYPE:

LSDC PROJECT #:

FULL REMODEL

NMA

00059876

PACKAGE:

GENERATION:

A/E PROJECT #:

PKG II

SPRING 2015

140332

(142Fc)

REVISIONS:

REQUIRED BY:	DATE:
--------------	-------

ELITE CONSTRUCTION GROUP
LAKE JACKSON, TX
PHONE: 979-285-0712
NOTE: THESE PRINTS HAVE BEEN
REDUCED BY 50 PERCENT. SCALE
WILL BE 50 PERCENT OF WHAT IS
NOTED ON PLANS

DATE ISSUED: 09/19/14
DESIGNED BY: RDW
DRAWN BY: TBA
CHECKED BY: JDM

ELECTRICAL POWER & FIRE ALARM PLAN

DRAWING NUMBER:
E02.02

ELECTRICAL POWER AND FIRE ALARM PLAN

1/4" = 1'-0"	A