


WASTE & VENT PIPING DIAGRAM

NTS

C

08/14/11

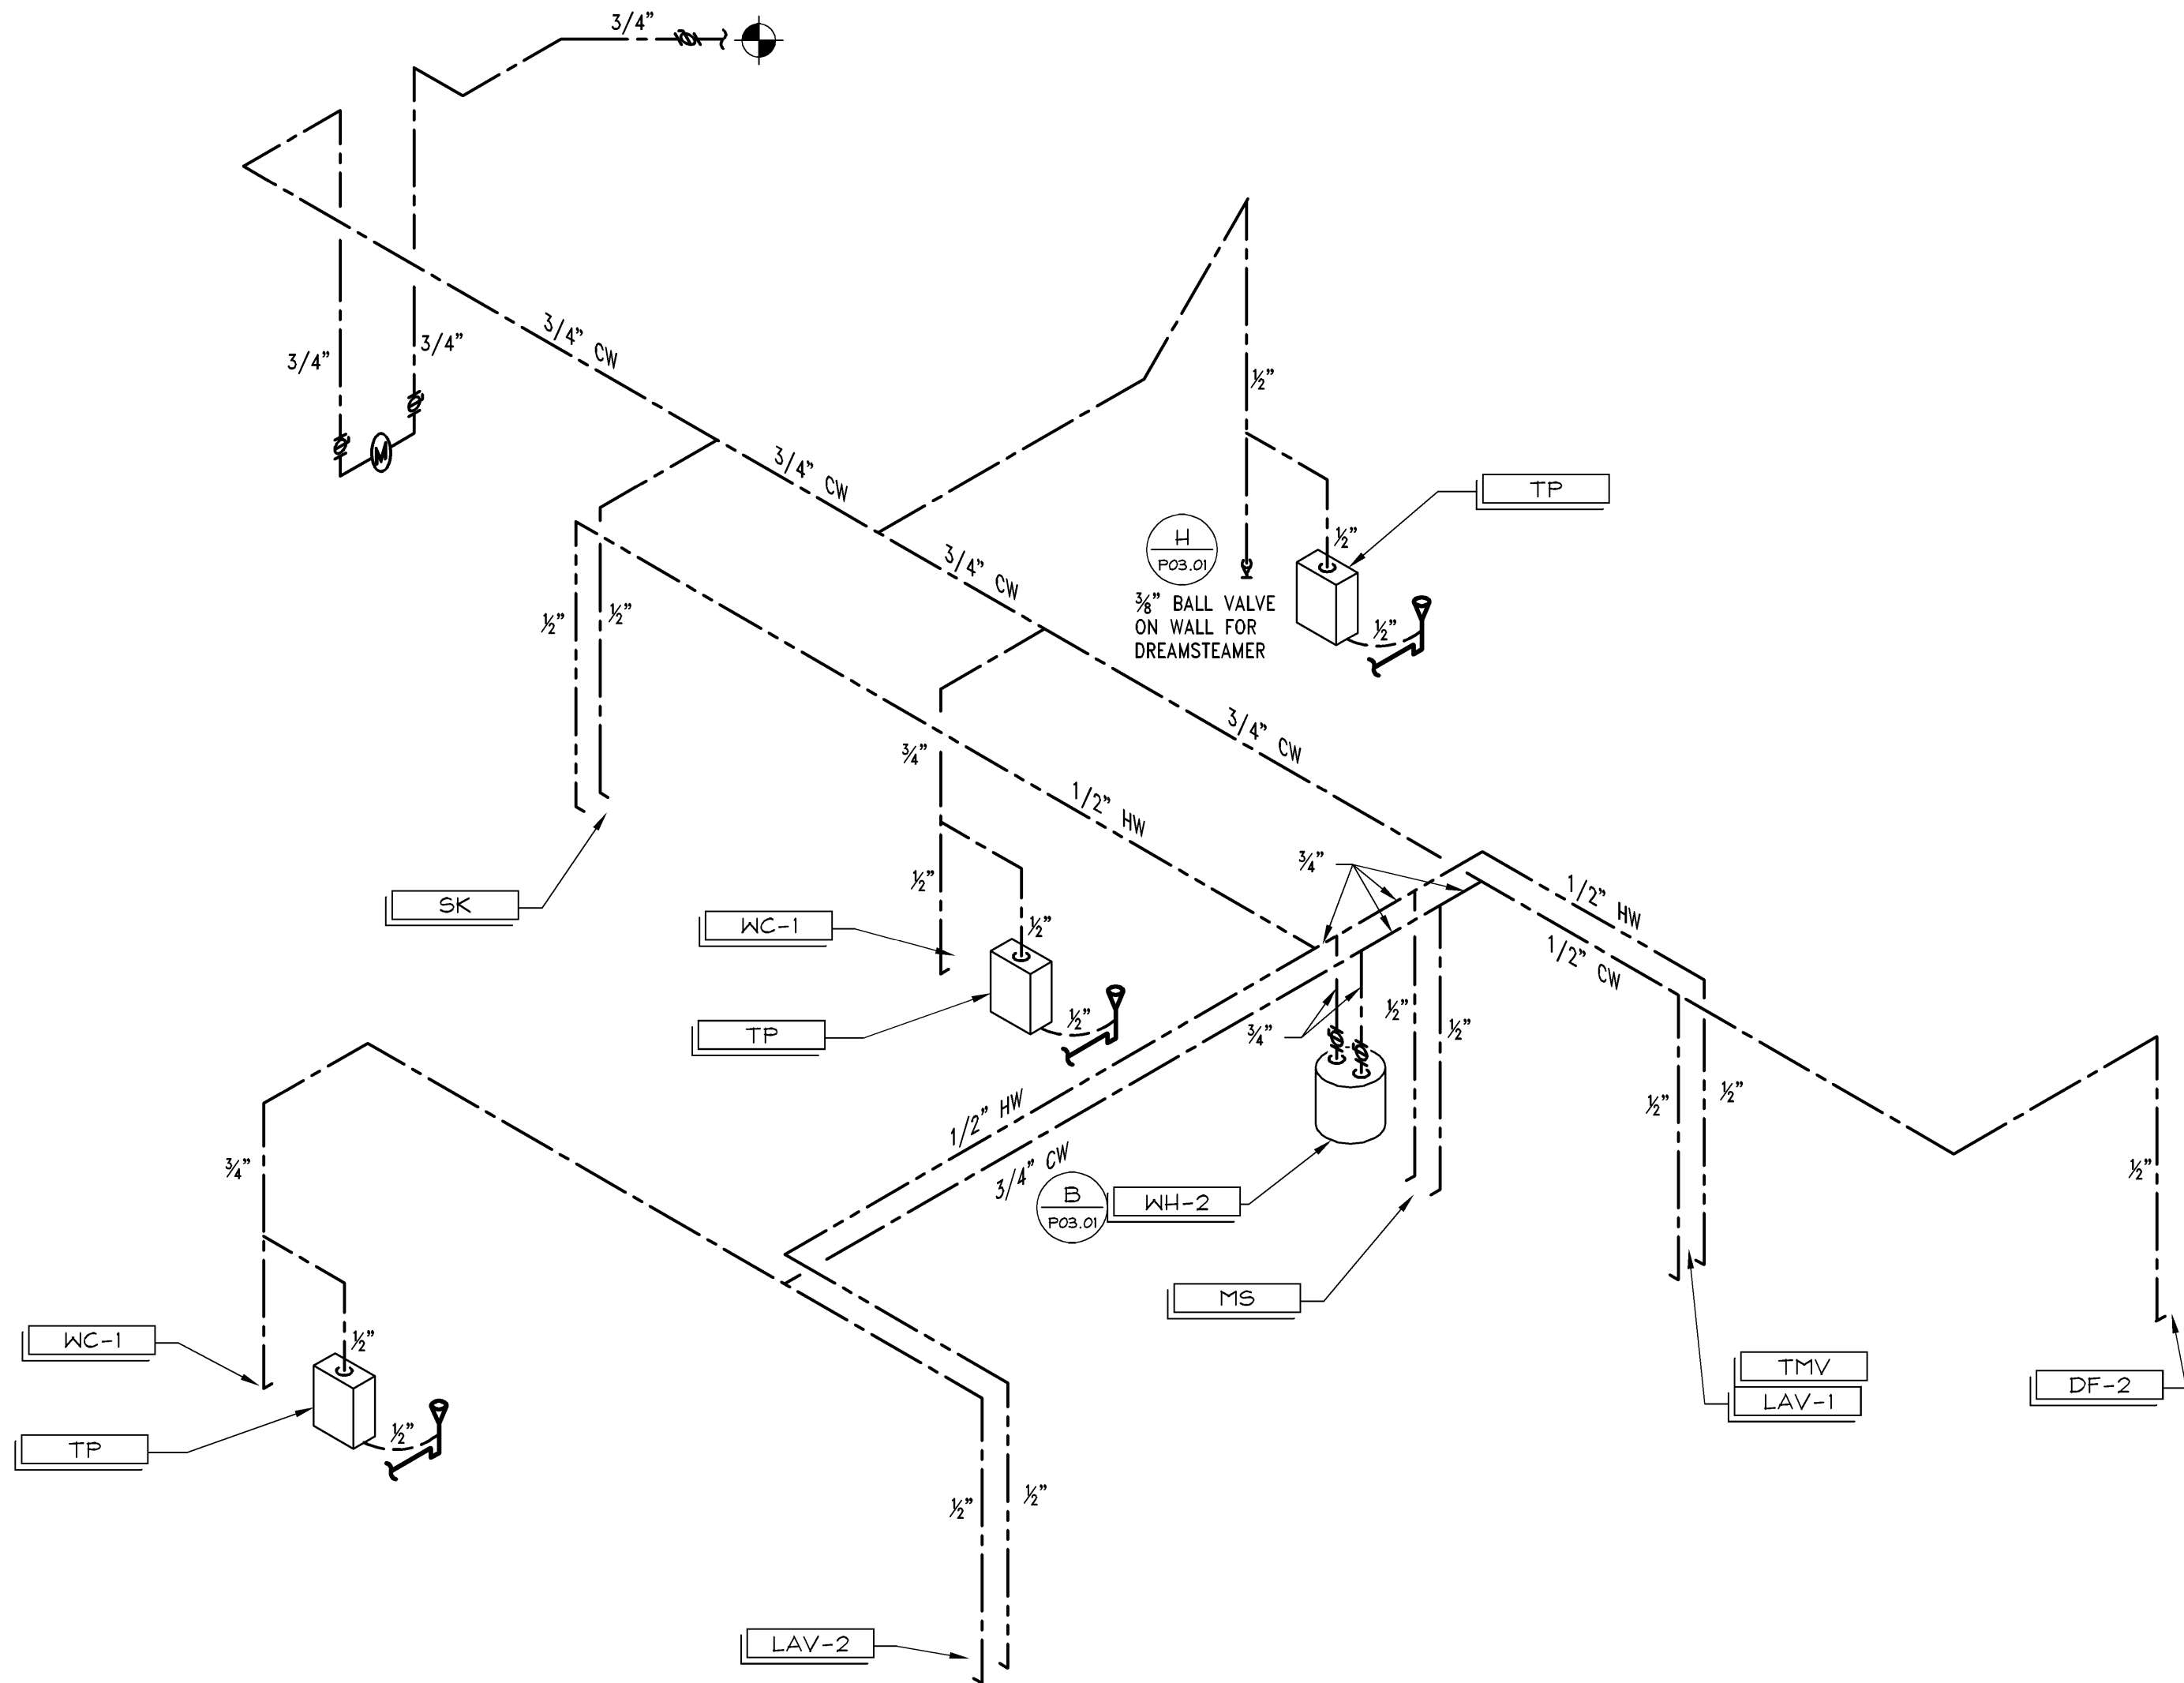

NOTES:
1. PROVIDE AN APPROVED BACKFLOW PREVENTER FOR MAIN DOMESTIC WATER LINE, IN ACCORDANCE WITH LOCAL CODE AND LANDLORD REQUIREMENTS.
2. REFER TO DETAIL R ON SHEET P03.01 AND PLUMBING FIXTURE SCHEDULE FOR WATER HAMMER ARRESTER (WHA) REQUIREMENTS.

DOMESTIC WATER PIPING DIAGRAM

NTS

A

08/14/11

010500587

VICTORIA'S SECRET

NORTH POINT MALL
SPACE #1050
1000 NORTH POINT CIRCLE
ALPHARETTA, GA 30022

PKG II
FULL REMODEL PACKAGE
NMA GENERATION: SPRING 2015 (142Fo)
00059876 I/A/E PROJECT #:

PROJECT INFORMATION:

REVISIONS:

NO ADDENDUM - LANDLORD COMMENTS
& MASTER UPDATES (15156.01 & 0156A) 01/02/2015

ELITE CONSTRUCTION GROUP
LAKE JACKSON, TX
PHONE: 979-285-0712
NOTE: THESE PRINTS HAVE BEEN
REDUCED BY 50 PERCENT. SCALE
WILL BE 50 PERCENT OF WHAT IS
NOTED ON PLANS.

DATE ISSUED: 09/19/14
DESIGNED BY: MAR
DRAWN BY: TBA
CHECKED BY: JMZ

PLUMBING
ISOMETRICS

DRAWING NUMBER:

P02.03