



SYMBOL	DESCRIPTION
	RECESSED DOWNLIGHT
	TRACK w/ TRACK HEADS
	FLUORESCENT STRIPS - SURFACE MOUNTED
	FLUORESCENT STRIPS - CHAIN-HUNG FROM STRUCTURE 12'-0" A.F.F.
	MULTI-LAMP RECESSED DOWNLIGHT
	SURFACE MOUNTED FLUORESCENT LIGHT w/ ACRYLIC LENS
	EGRESS SIGNAGE
	BBW EMERGENCY LIGHT
	SPEAKER
	SUPPLY DIFFUSER
	RETURN AIR GRILLE
	CEILING ACCESS PANEL
	EXHAUST AIR REGISTER
	MARKETING RAIL
	PENDANT LIGHT - MOUNTED 7'-6" A.F.F.
	BILLBOARD LIGHT
	CCTV VIEWING MONITOR
	CCTV CAMERA - SUPPLIED AND INSTALLED BY SECURITY VENDOR
	TRAFFIC COUNTER
	SCENT AIR - MBC ORDERED IN BLACK WITH 10'-0" CORD BBW ORDERED IN WHITE AND MOUNTED IN CEILING
	MBC EMERGENCY LIGHT - PAINTED PT-92

- NOTES:
- ALL CEILING HEIGHTS ARE FROM THE TOP OF FINISH FLOOR TO UNDERSIDE OF FINISH CEILING.
 - PROVIDE ADEQUATE CLEARANCES FOR FIXTURES, DUCTS, CEILINGS, AND RELATED PERTINENT ITEMS NECESSARY TO MAINTAIN THE SPECIFIED HEIGHTS ABOVE FINISH FLOOR.
 - ADDITIONAL HANGER AND SAFETY WIRES FOR LIGHT FIXTURES, SPEAKERS AND DUCTWORK, AS REQUIRED BY LOCAL CODES, TO BE THE RESPONSIBILITY OF THE CEILING SUBCONTRACTOR.
 - SPRINKLER HEAD LAYOUT TO CONFORM TO LOCAL CODE, TAKING IN ACCOUNT LOCATIONS OF DUCTWORK, LIGHTING AND LOCATION OF TENANT'S CABINET, FIXTURE AND SHELVING UNITS.
 - ARCHITECTURAL DRAWINGS DETERMINE LOCATION OF LUMINAIRES AND SUPERSEDE ALL OTHERS, U.O.N.
 - AFTER INSTALLATION, ELECTRICAL CONTRACTOR IS TO TILT THE LAMP IN ALL "T" FIXTURES @ A 45 DEGREE ANGLE TOWARD WALL OR CABINETS.
 - SEE LIGHT FIXTURE SCHEDULE ON ELECTRICAL DRAWINGS FOR FIXTURE MODEL NUMBERS KEYED TO THE LIGHTING AND CEILING LEGEND.
 - NO EMERGENCY LIGHTS, EXIT LIGHTS OR SENSORS ARE TO BE PLACED ON THE PERIMETER SALES WALLS.


CEILING AND LIGHTING LEGEND	1/4" = 1'-0"	R
	42D-A041-L01-LGMD	04.26.10

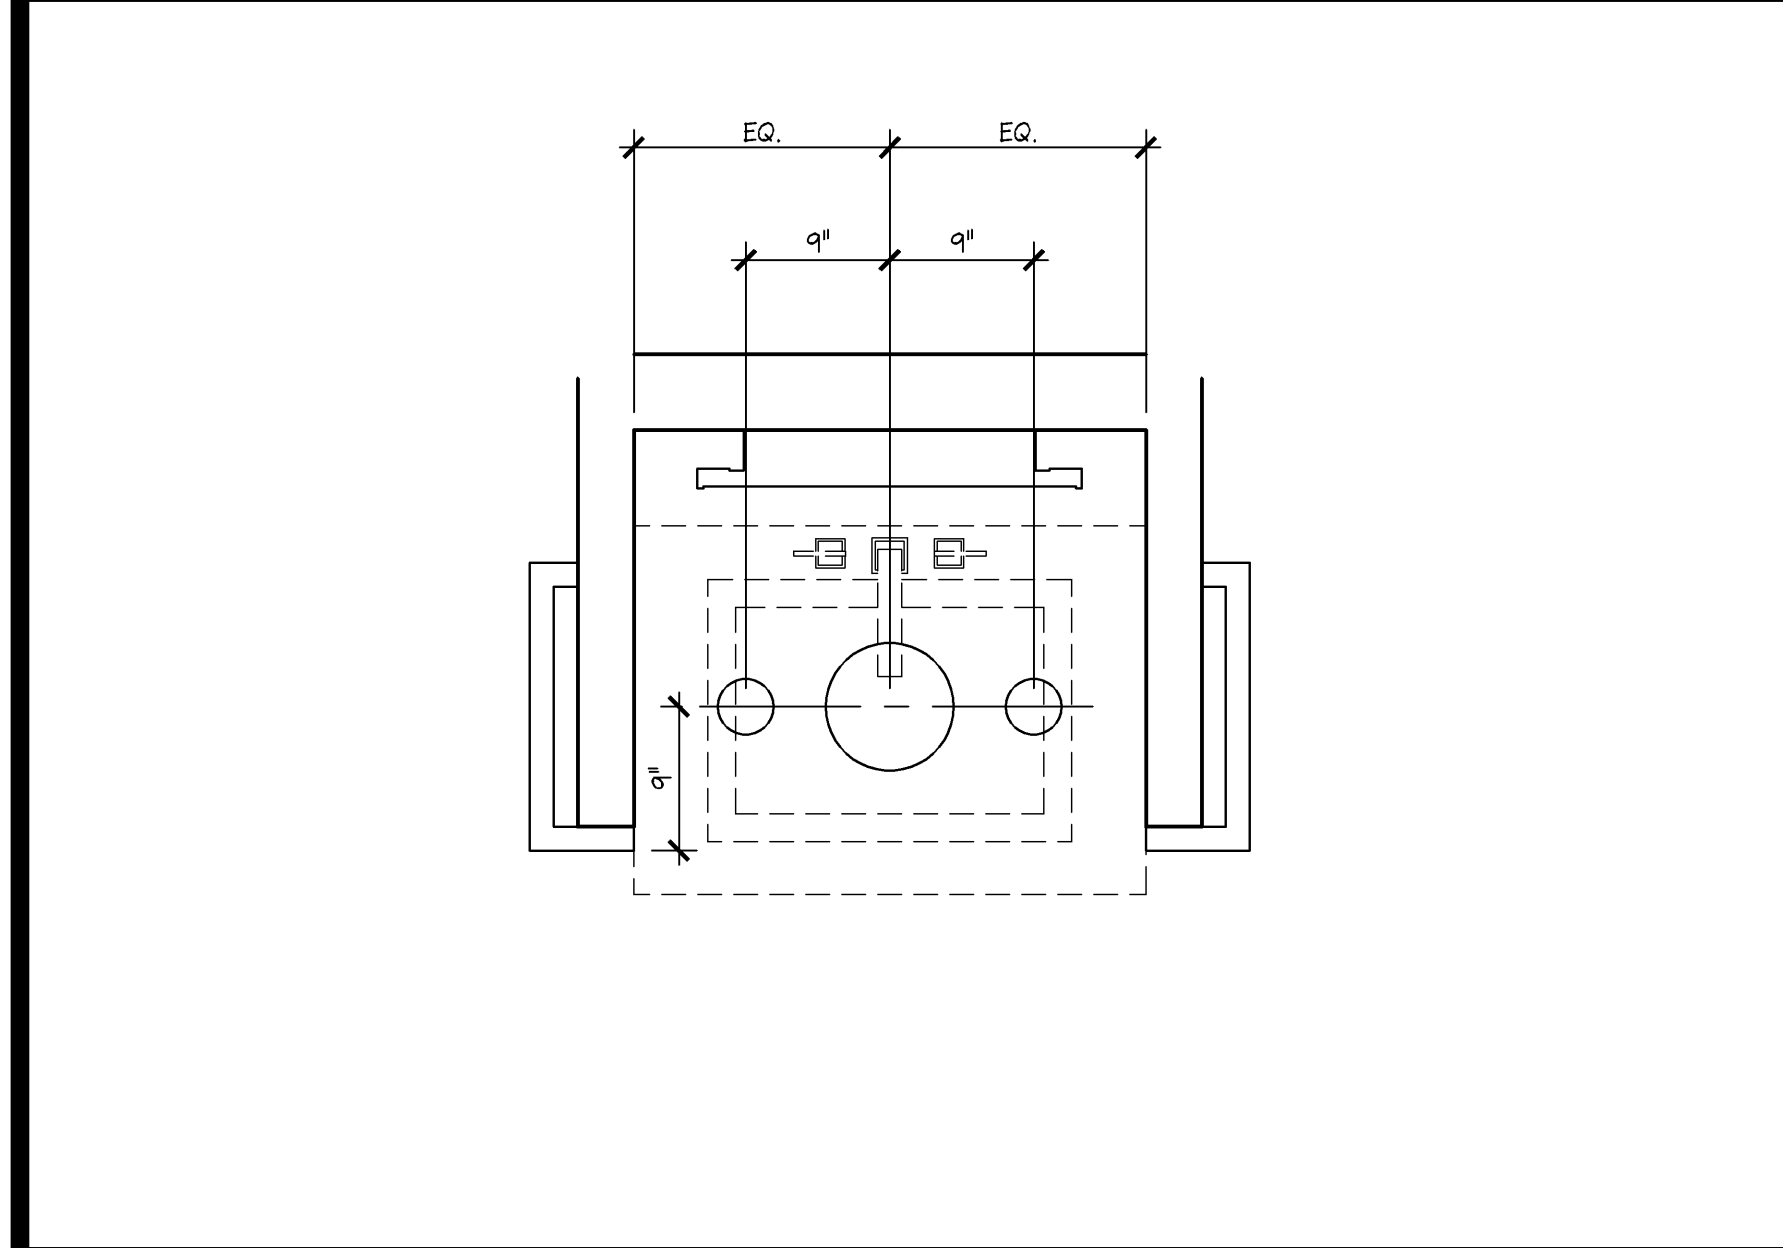


ENLARGED RCP AT ARCHITECTURAL NARROW DEMO SINK	1" = 1'-0"	P
	42D-A041-D01-DETL	03.16.12

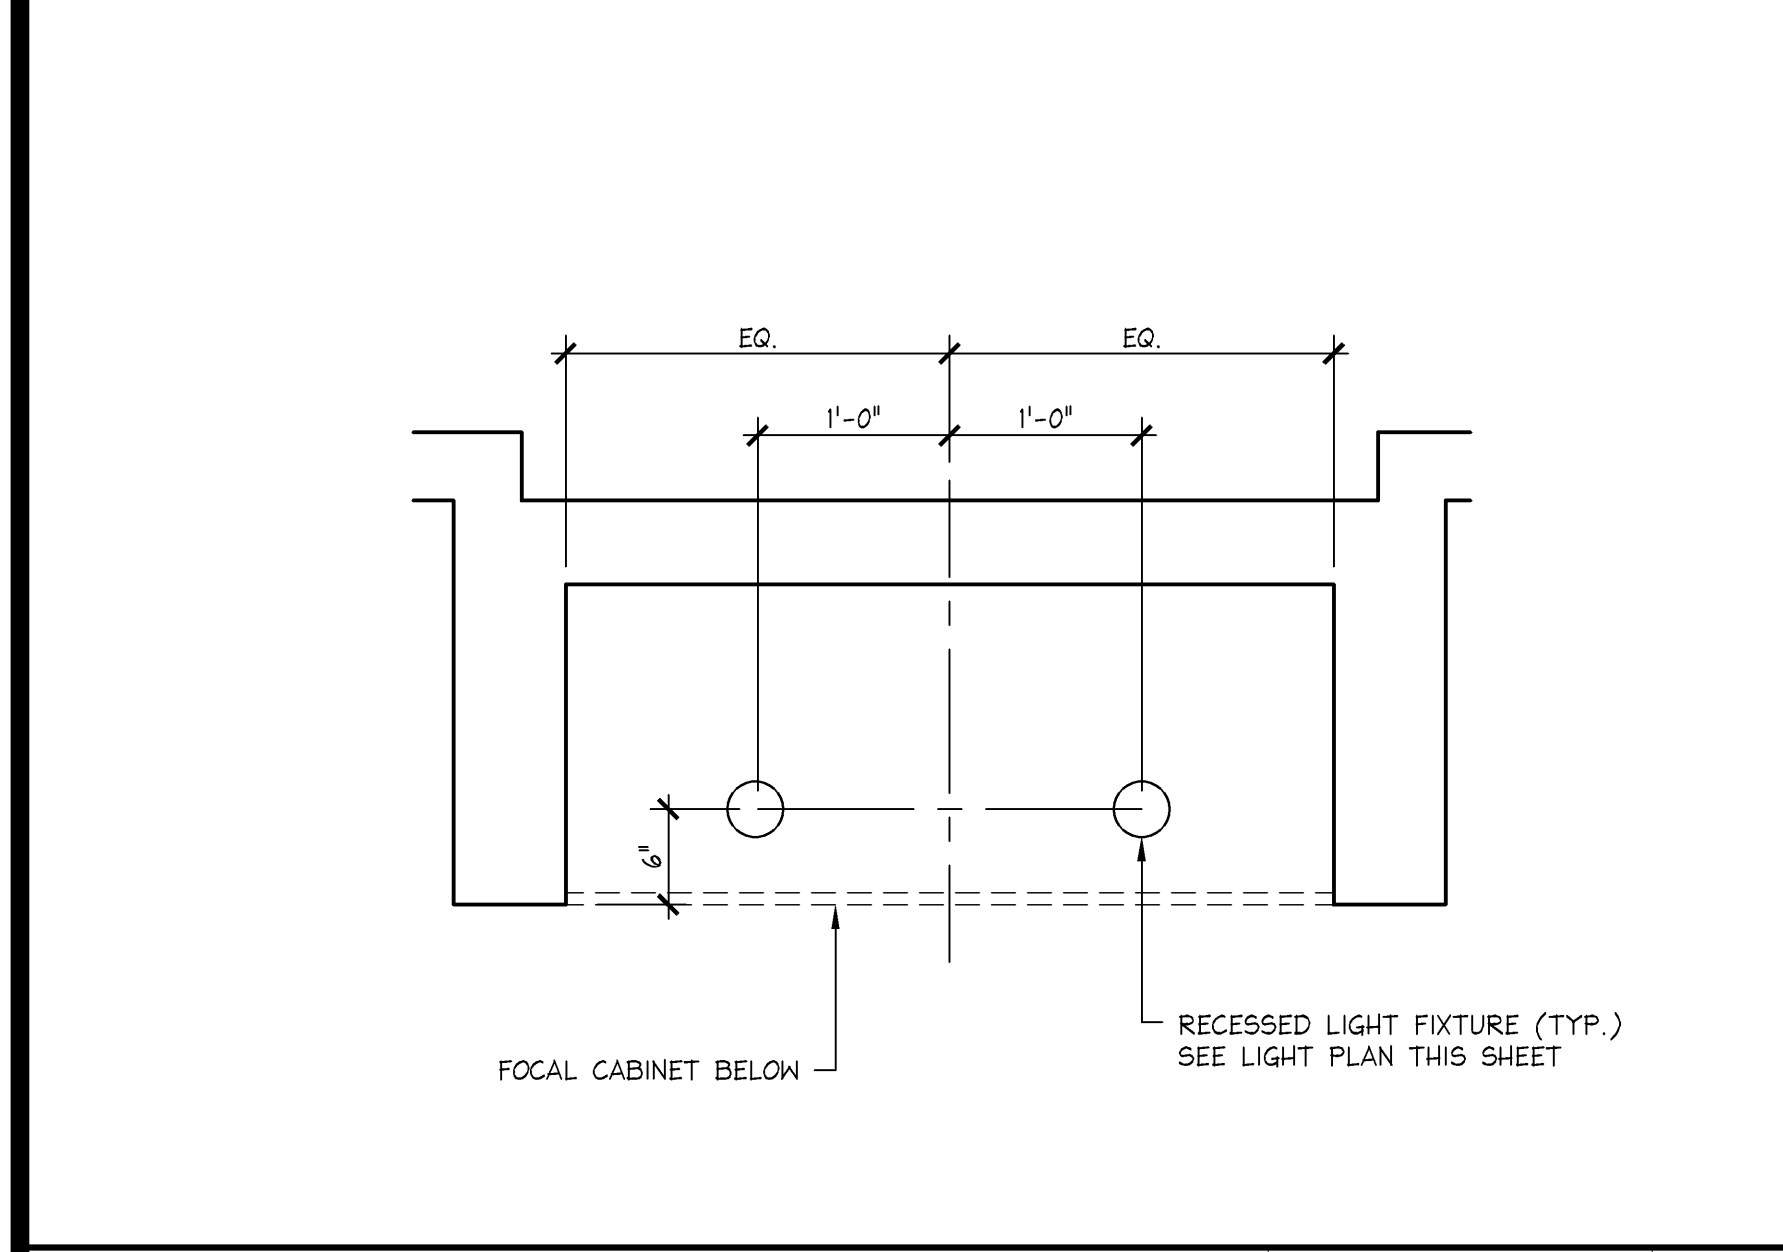

ENLARGED RCP @ FOCAL	1" = 1'-0"	N
	42D-A041-D00-DETL	03.16.12

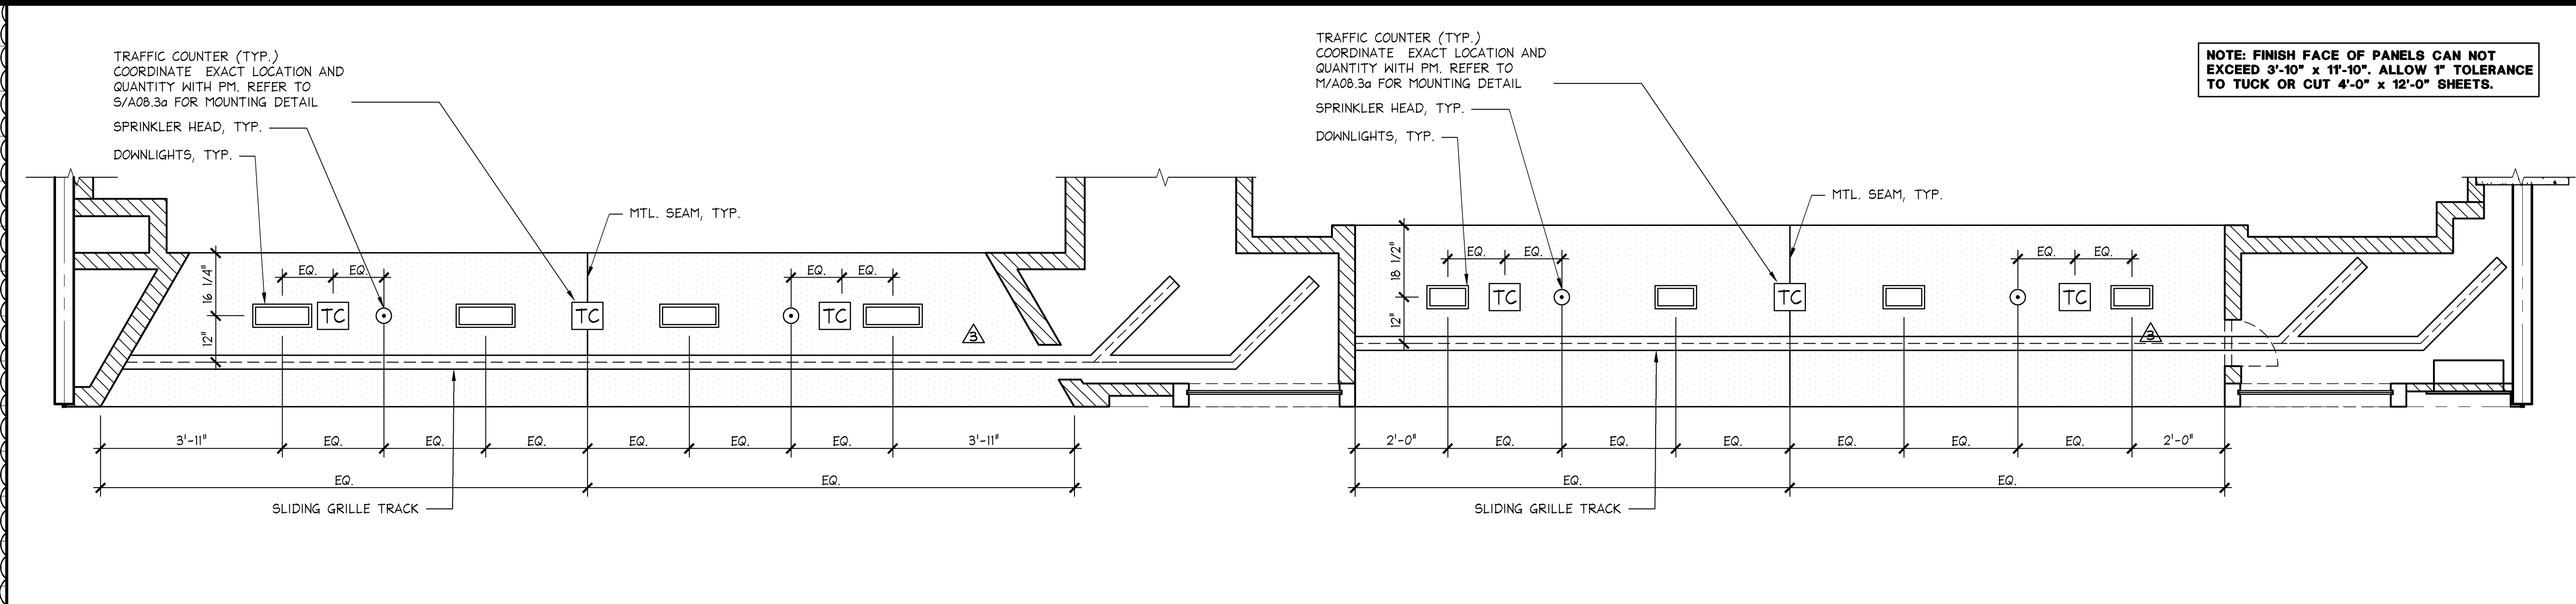

METAL SEAMS @ CANOPY CEILING	1/2" = 1'-0"	D
	42D-A041-C01-DETL	11.18.10

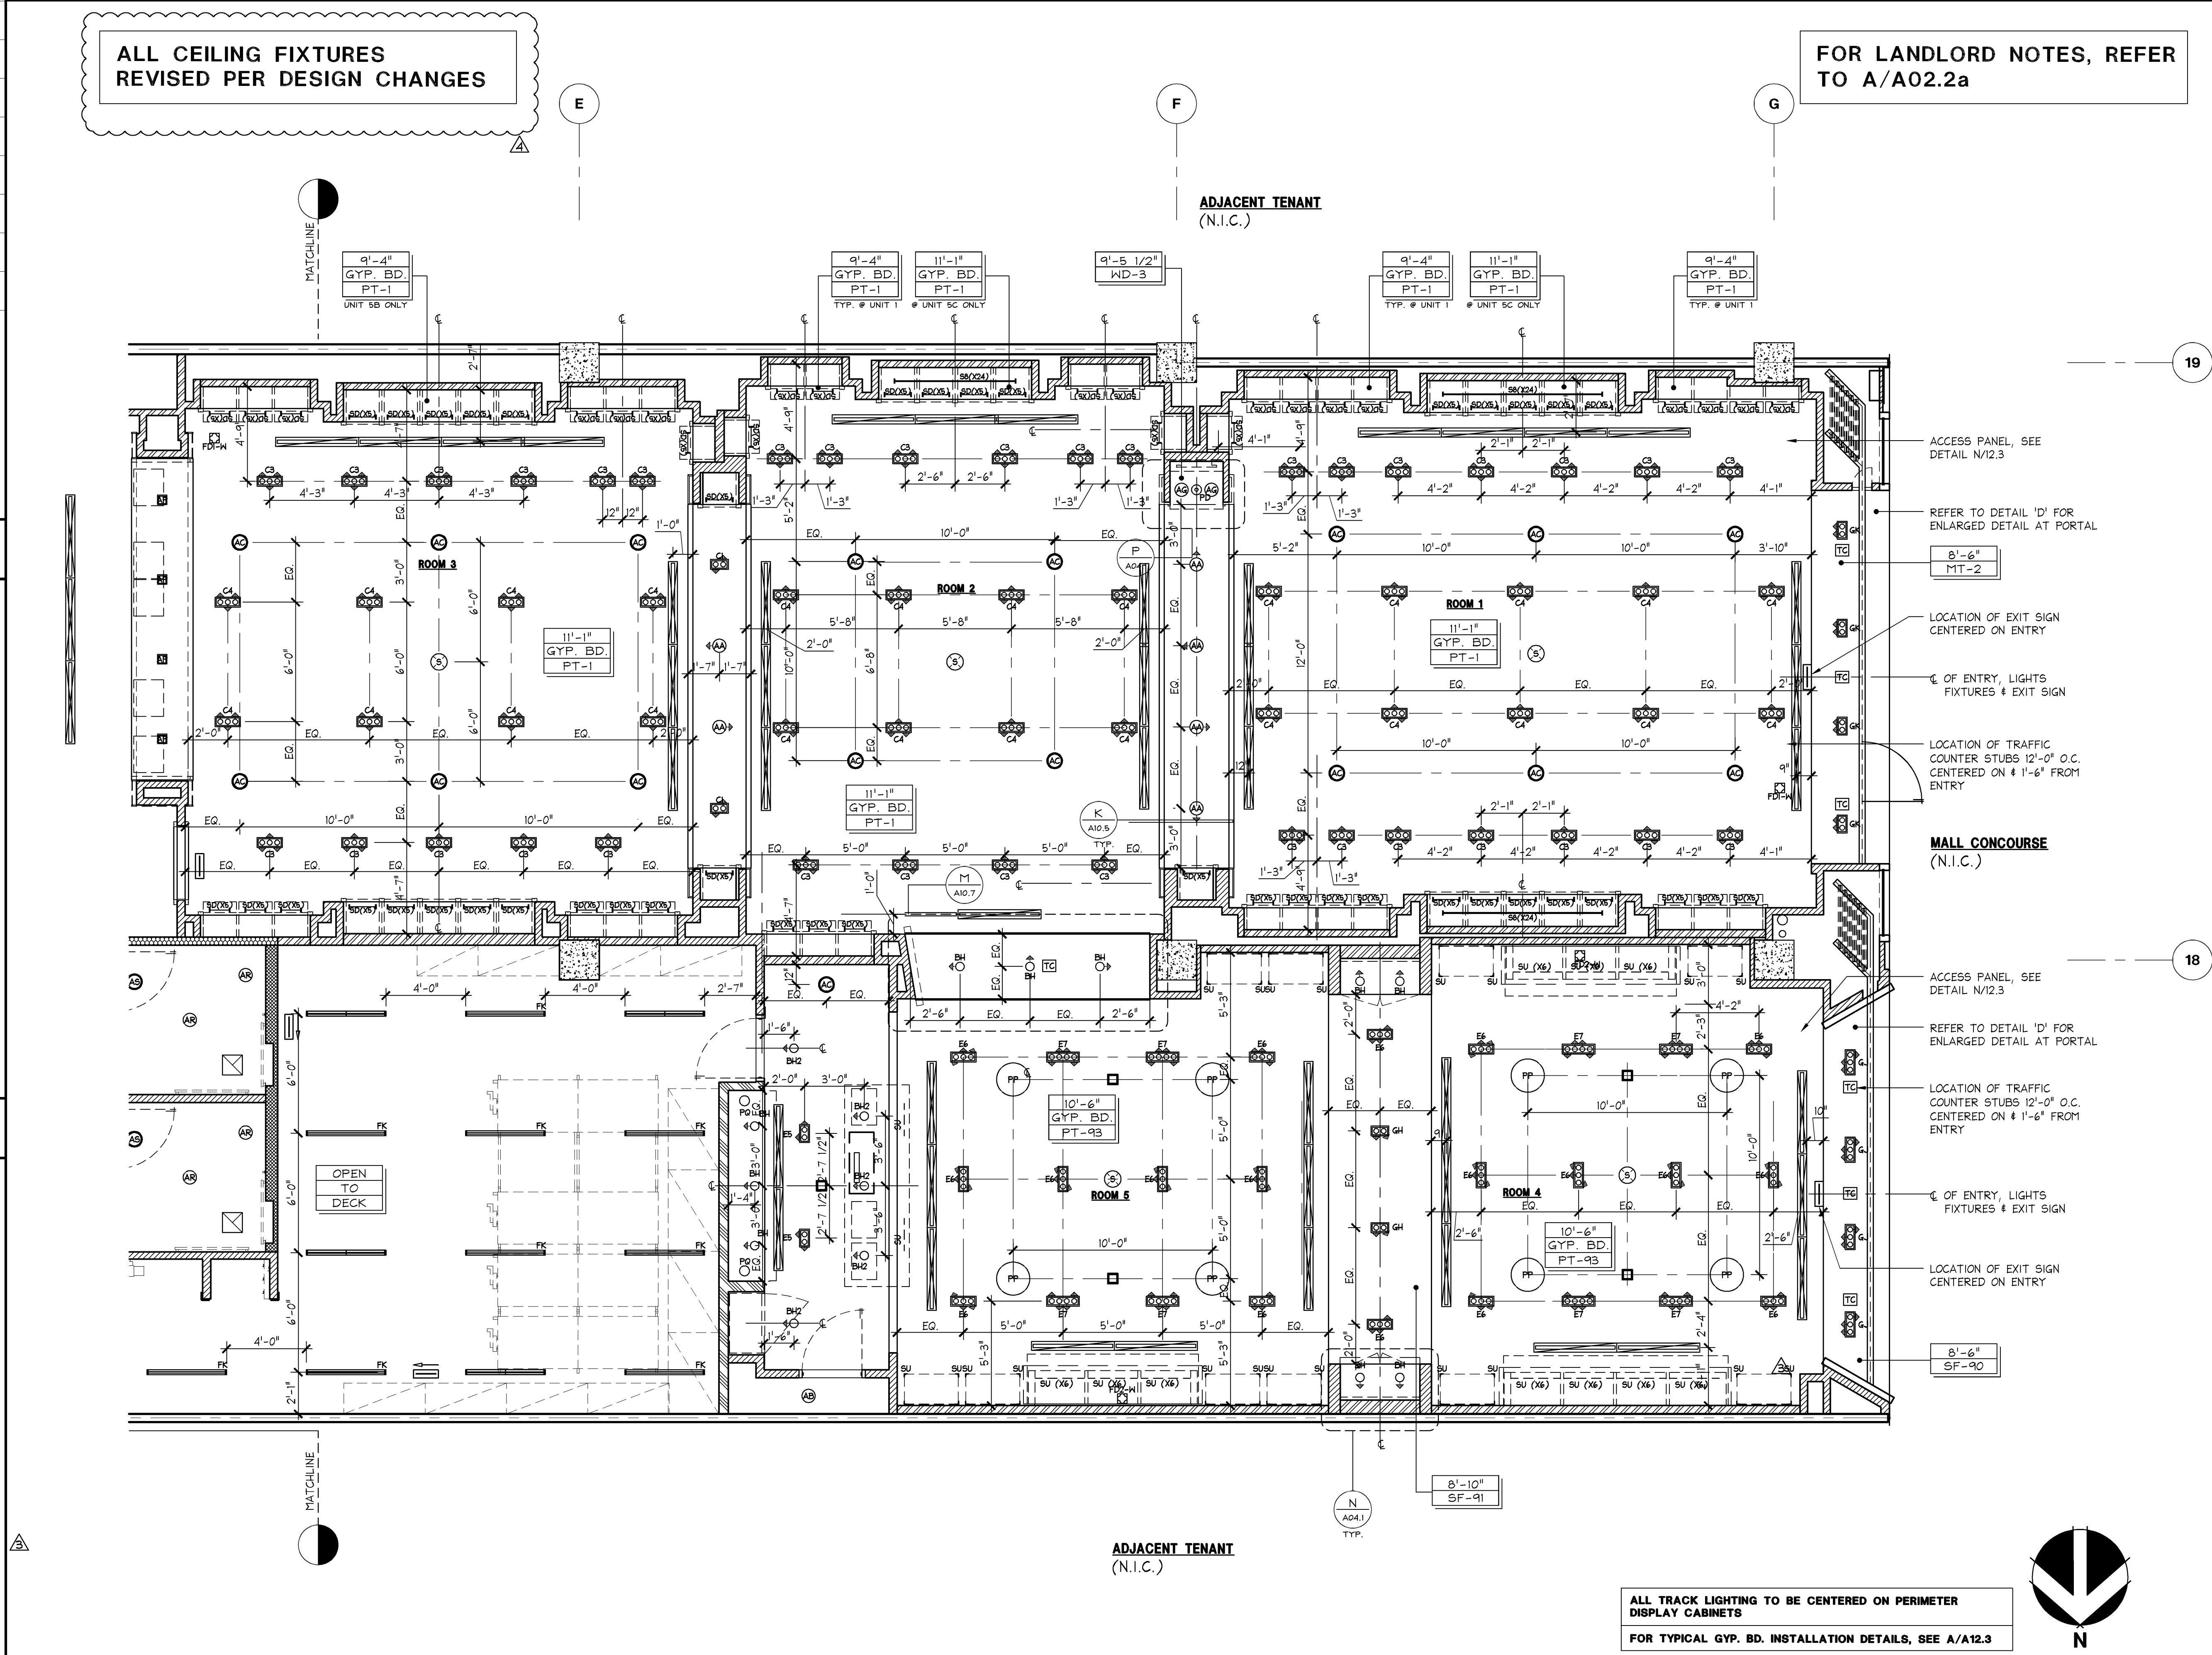

REFLECTED CEILING PLAN	1/4" = 1'-0"	A
	42P-A041-A01-PLAN	03.09.11

SHREMSHOCK

Shremshock Architects, Inc.

6130 S. Sunbury Rd., Westerville, OH 43081

T: 614.545.4550 | F: 614.545.4555 | shremshock.com

Gerald S. Shremshock, Architect

Timothy J. Shremshock, Architect

ELITE CONSTRUCTION GROUP
LAKE JACKSON, TX
PHONE: 979-285-50712
NOTE: THESE PRINTS HAVE BEEN
REDUCED BY 50 PERCENT. SCALE
WILL BE 50 PERCENT OF WHAT IS
NOTED ON PLANS

limitedbrands

LIMITED STORE PLANNING, INC.

d/b/a STORE DESIGN & CONSTRUCTION

Three Limited Parkway • Columbus, Ohio 43230

Telephone: 614.415.7000 • Fax: 614.415.7349

THESE DRAWINGS AND SPECIFICATIONS ARE PREPARED FOR USE ON A SPECIFIC SITE. THESE DRAWINGS AND SPECIFICATIONS ARE NOT TO BE USED FOR ANY OTHER PROJECT WITHOUT THE WRITTEN CONSENT OF THE ARCHITECT. THE ARCHITECT'S OFFICE SHALL NOT BE RESPONSIBLE FOR THE ACCURACY OF THE INFORMATION PROVIDED BY ANY OTHER PARTY. THE ARCHITECT'S OFFICE SHALL NOT BE RESPONSIBLE FOR THE ACCURACY OF THE INFORMATION PROVIDED BY ANY OTHER PARTY. THE ARCHITECT'S OFFICE SHALL NOT BE RESPONSIBLE FOR THE ACCURACY OF THE INFORMATION PROVIDED BY ANY OTHER PARTY.

PROJECT INFORMATION:

24200161

BATH & BODY WORKS

THE GALLERIA II

SPACE INDUSTRIES RD.

HOUSTON, TX 77056

REVISIONS:

REQUIRED BY

BUILDING DEPARTMENT COMMENTS

04/11/14

DESIGN CHANGES

06/27/14

DATE ISSUED:

3/7/14

DESIGNED BY:

SB

DRAWN BY:

JLH

CHECKED BY:

RHW

REFLECTED CEILING PLAN

DRAWING NUMBER:

A04.1