



SYMBOL	DESCRIPTION
	RECESSED DOWNLIGHT
	TRACK w/ TRACK HEADS
	FLUORESCENT STRIPS - SURFACE MOUNTED
	FLUORESCENT STRIPS - CHAIN-HUNG FROM STRUCTURE 12'-0" A.F.F.
	MULTI-LAMP RECESSED DOWNLIGHT
	SURFACE MOUNTED FLUORESCENT LIGHT w/ ACRYLIC LENS
	EGRESS SIGNAGE
	BBW EMERGENCY LIGHT
	SPEAKER
	SUPPLY DIFFUSER
	RETURN AIR GRILLE
	CEILING ACCESS PANEL
	EXHAUST AIR REGISTER
	MARKETING RAIL
	PENDANT LIGHT - MOUNTED 7'-6" A.F.F.
	BILLBOARD LIGHT
	CCTV VIEWING MONITOR
	CCTV CAMERA - SUPPLIED AND INSTALLED BY SECURITY VENDOR
	TRAFFIC COUNTER
	SCENT AIR - MBC ORDERED IN BLACK WITH 10'-0" CORD BBW ORDERED IN WHITE AND MOUNTED IN CEILING
	MBC EMERGENCY LIGHT - PAINTED PT-92

- NOTES:
- ALL CEILING HEIGHTS ARE FROM THE TOP OF FINISH FLOOR TO UNDERSIDE OF FINISH CEILING.
 - PROVIDE ADEQUATE CLEARANCES FOR FIXTURES, DUCTS, CEILINGS, AND RELATED PERTINENT ITEMS NECESSARY TO MAINTAIN THE SPECIFIED HEIGHTS ABOVE FINISH FLOOR.
 - ADDITIONAL HANGER AND SAFETY WIRES FOR LIGHT FIXTURES, SPEAKERS AND DUCTWORK, AS REQUIRED BY LOCAL CODES, TO BE THE RESPONSIBILITY OF THE CEILING SUBCONTRACTOR.
 - SPRINKLER HEAD LAYOUT TO CONFORM TO LOCAL CODE, TAKING IN ACCOUNT LOCATIONS OF DUCTWORK, LIGHTING AND LOCATION OF TENANT'S CABINET, FIXTURE AND SHELVING UNITS.
 - ARCHITECTURAL DRAWINGS DETERMINE LOCATION OF LUMINAIRES AND SUPERSEDE ALL OTHERS, U.O.N.
 - AFTER INSTALLATION, ELECTRICAL CONTRACTOR IS TO TILT THE LAMP IN ALL "T" FIXTURES @ A 45 DEGREE ANGLE TOWARD WALL OR CABINETS.
 - SEE LIGHT FIXTURE SCHEDULE ON ELECTRICAL DRAWINGS FOR FIXTURE MODEL NUMBERS KEYED TO THE LIGHTING AND CEILING LEGEND.
 - NO EMERGENCY LIGHTS, EXIT LIGHTS OR SENSORS ARE TO BE PLACED ON THE PERIMETER SALES WALLS.


CEILING AND LIGHTING LEGEND	1/4" = 1'-0"	R
	42L-A041-L01-LGMD	04.26.10

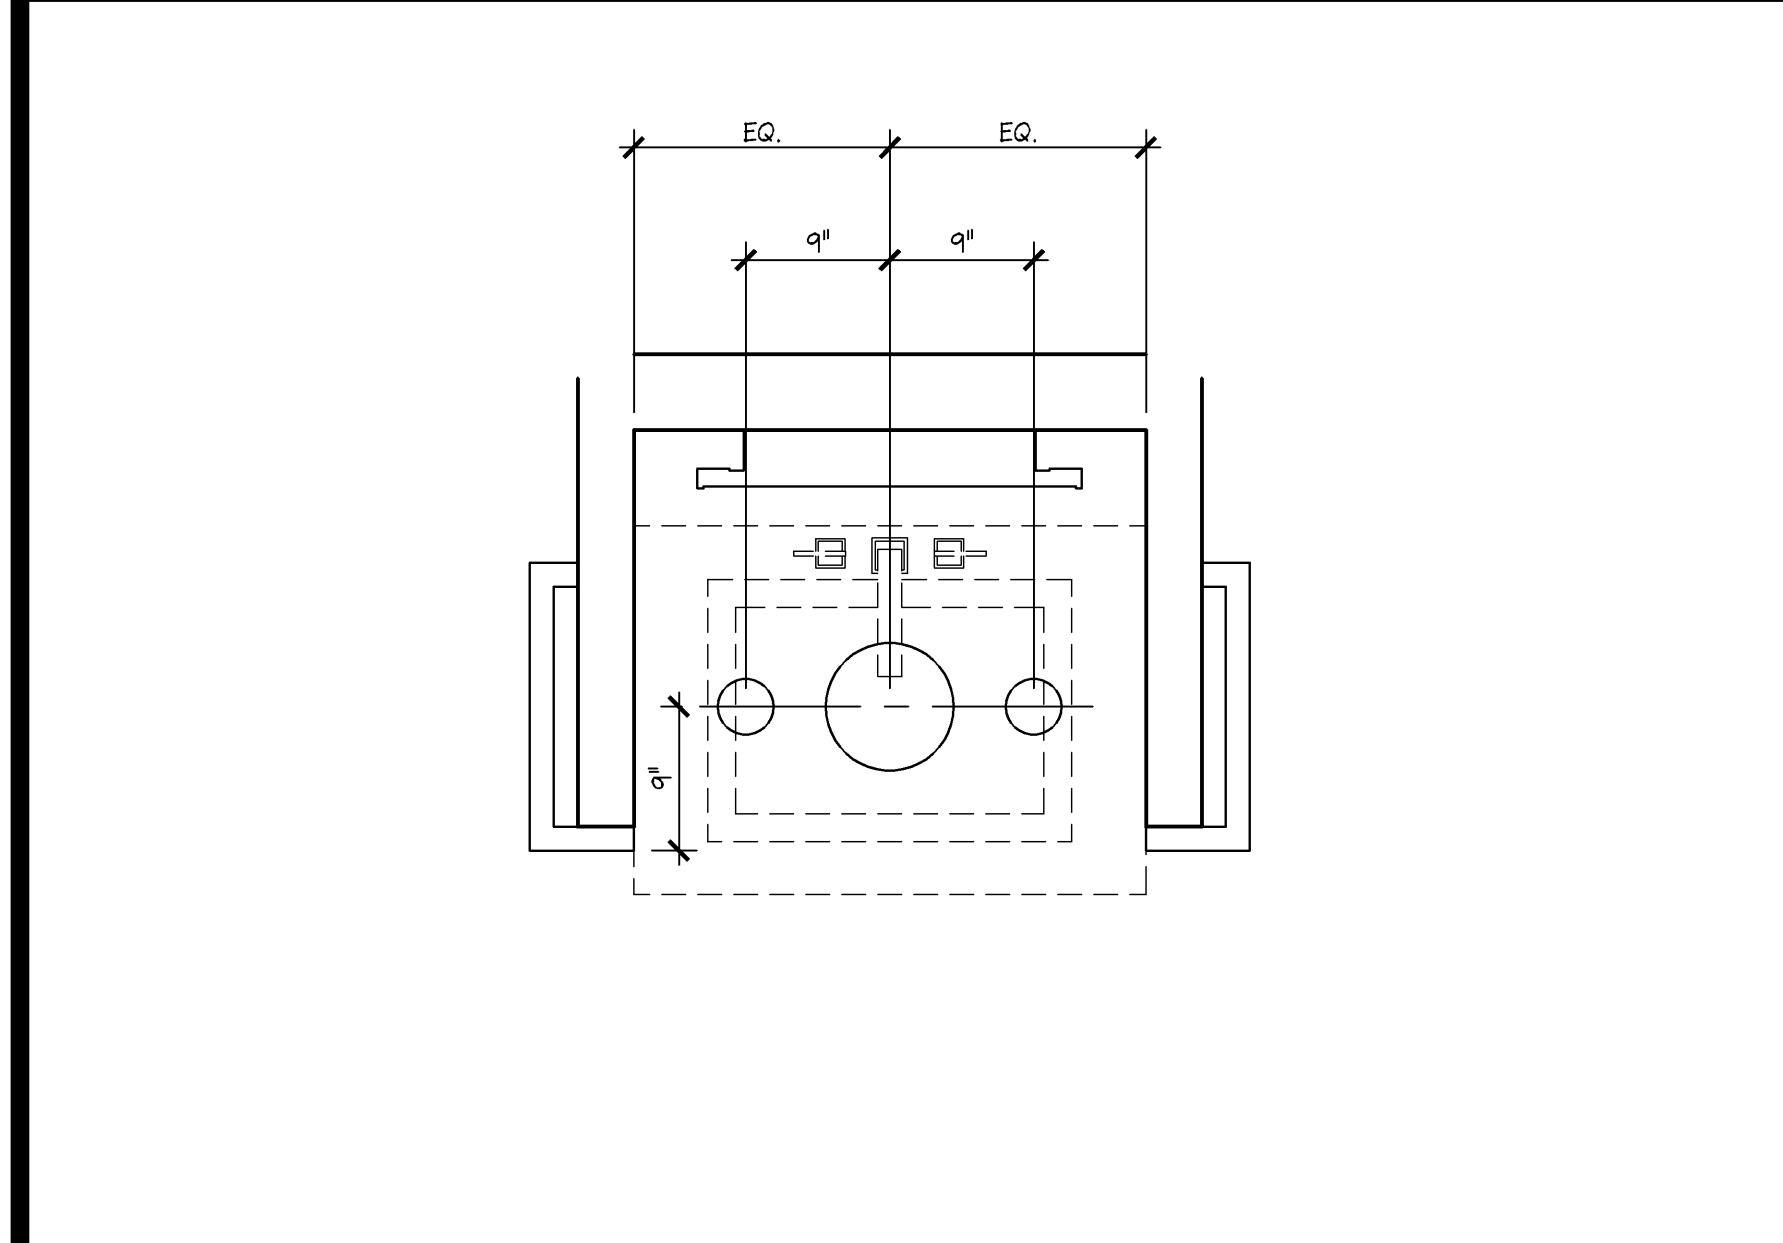


ENLARGED RCP AT ARCHITECTURAL NARROW DEMO SINK	1" = 1'-0"	P
	42D-A041-D01-DETL	03.16.12

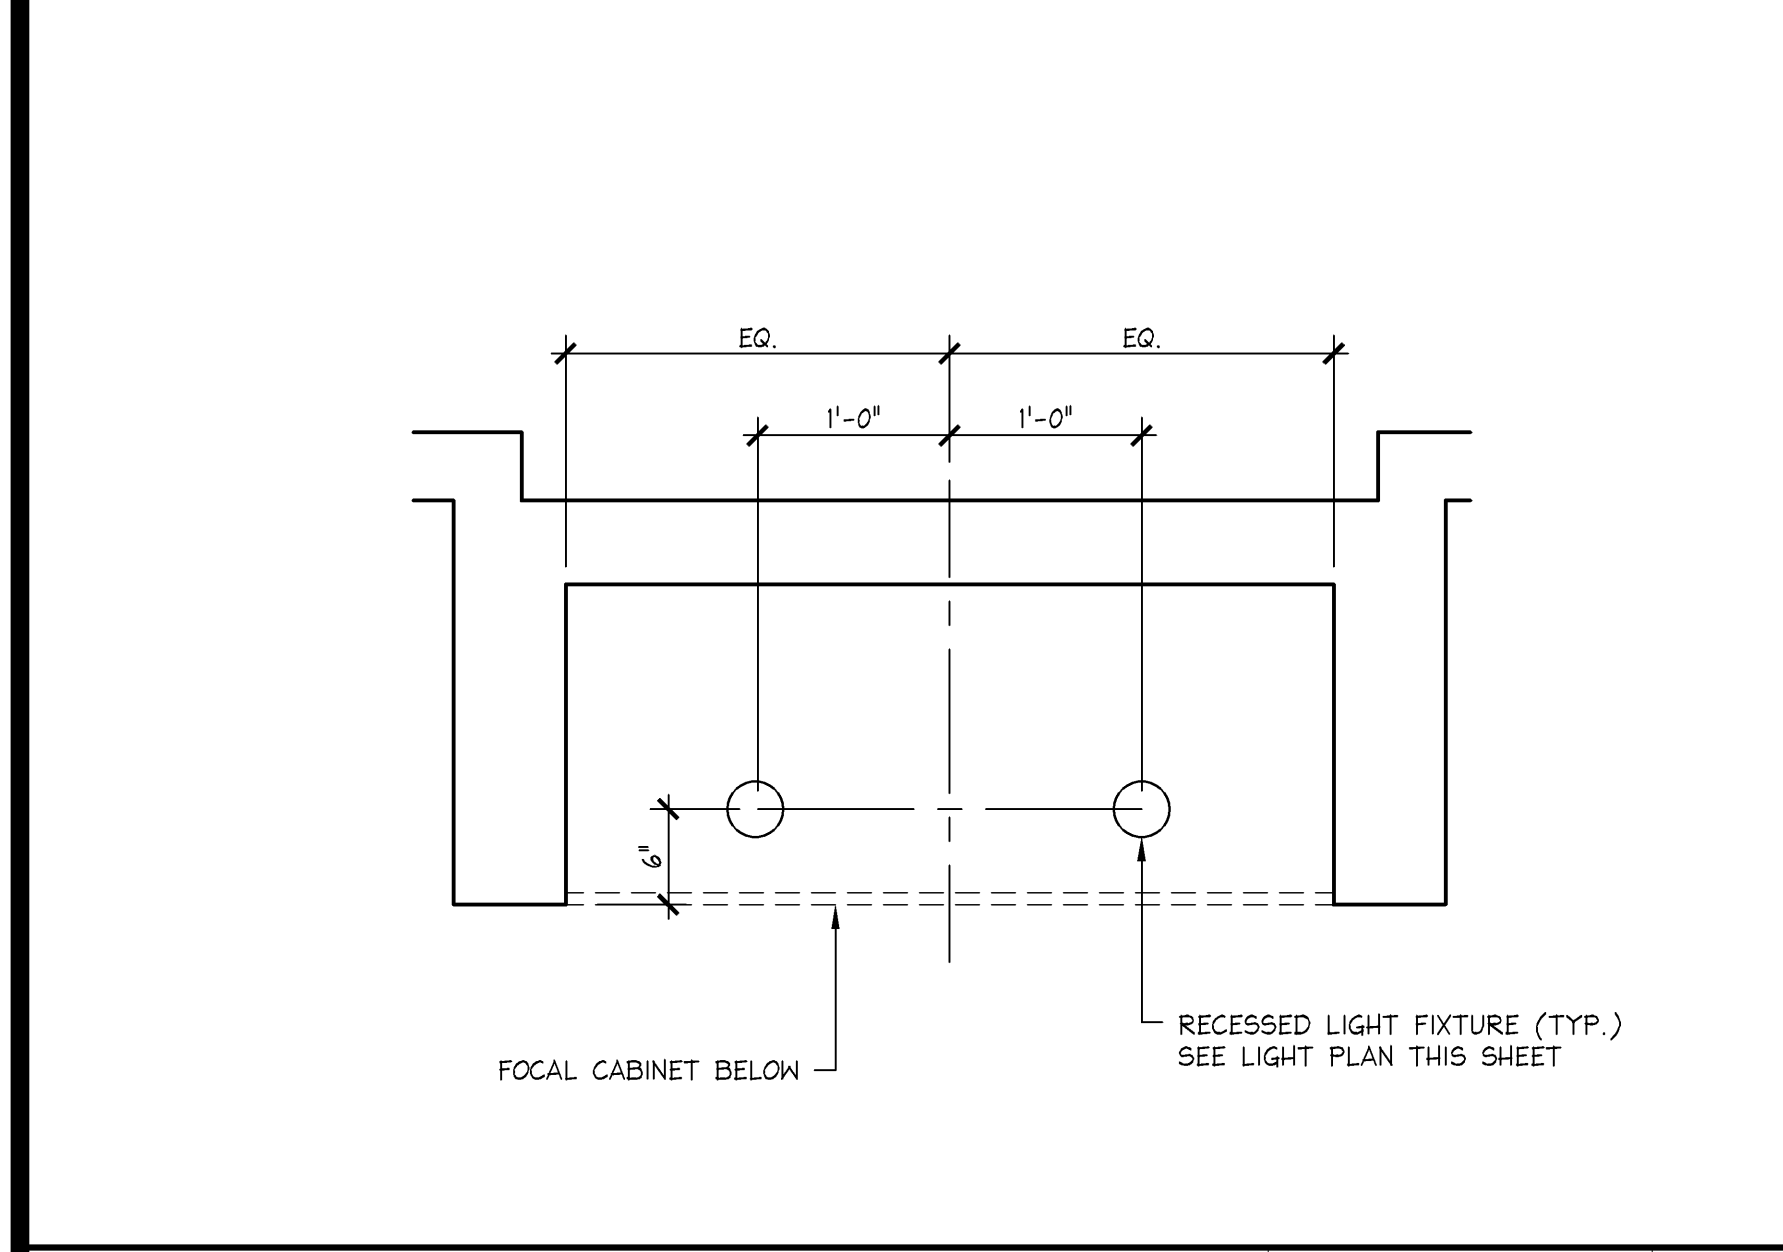

ENLARGED RCP @ FOCAL	1" = 1'-0"	N
	42D-A041-D00-DETL	03.16.12

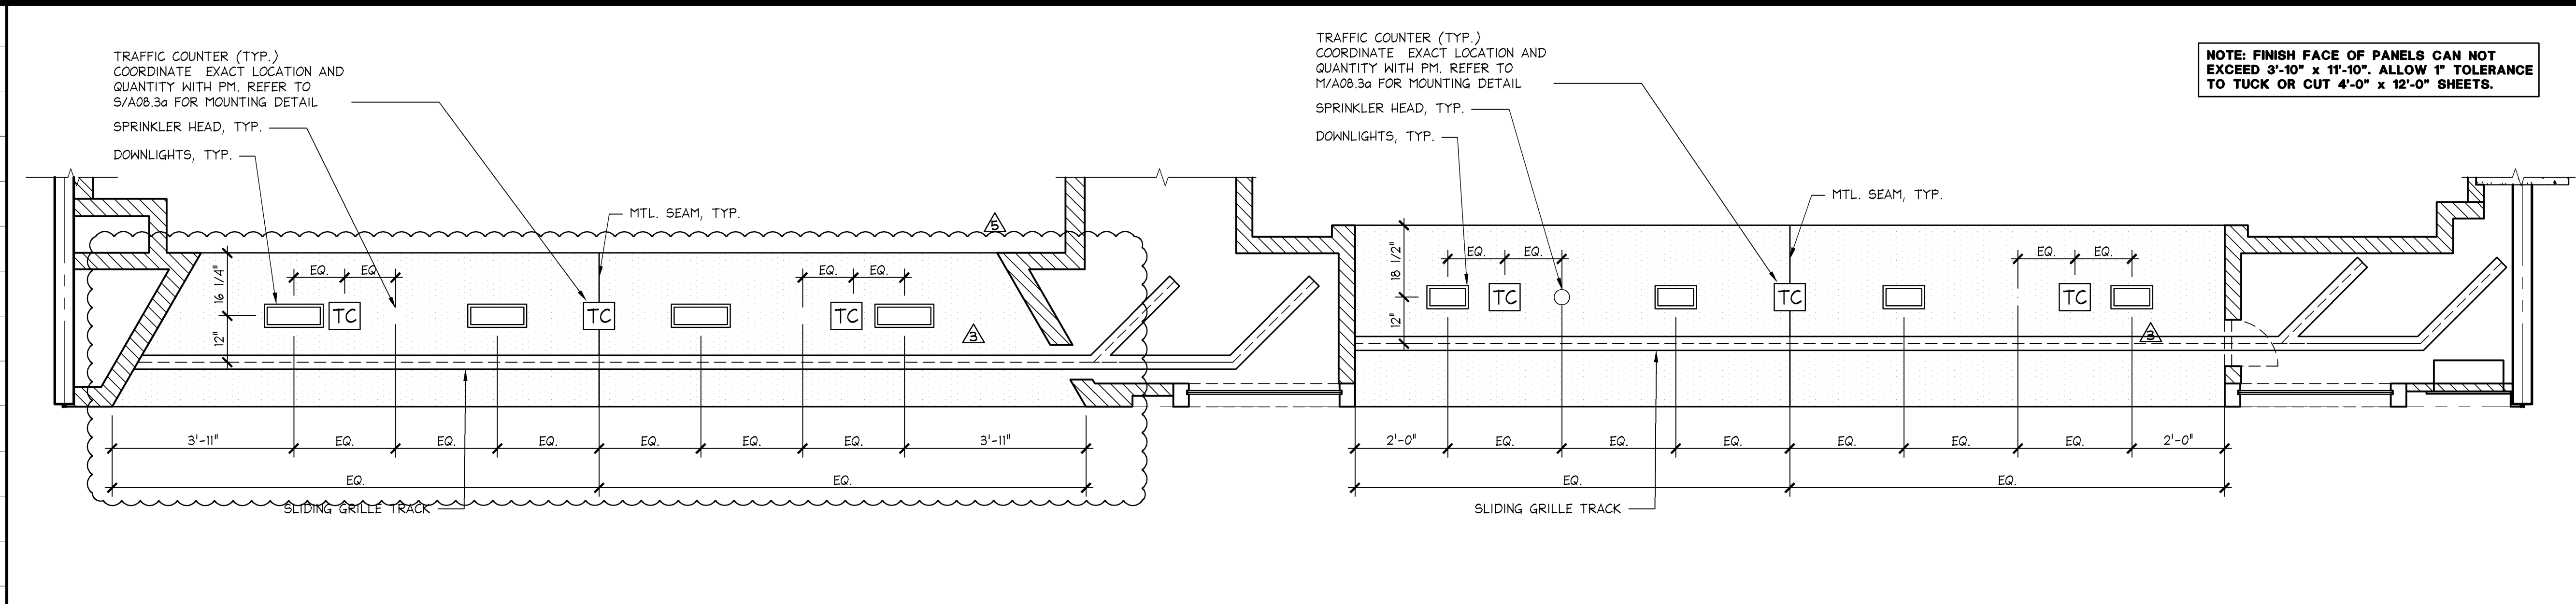

METAL SEAMS @ CANOPY CEILING	1/2" = 1'-0"	D
	42D-A041-C01-DETL	11.18.10

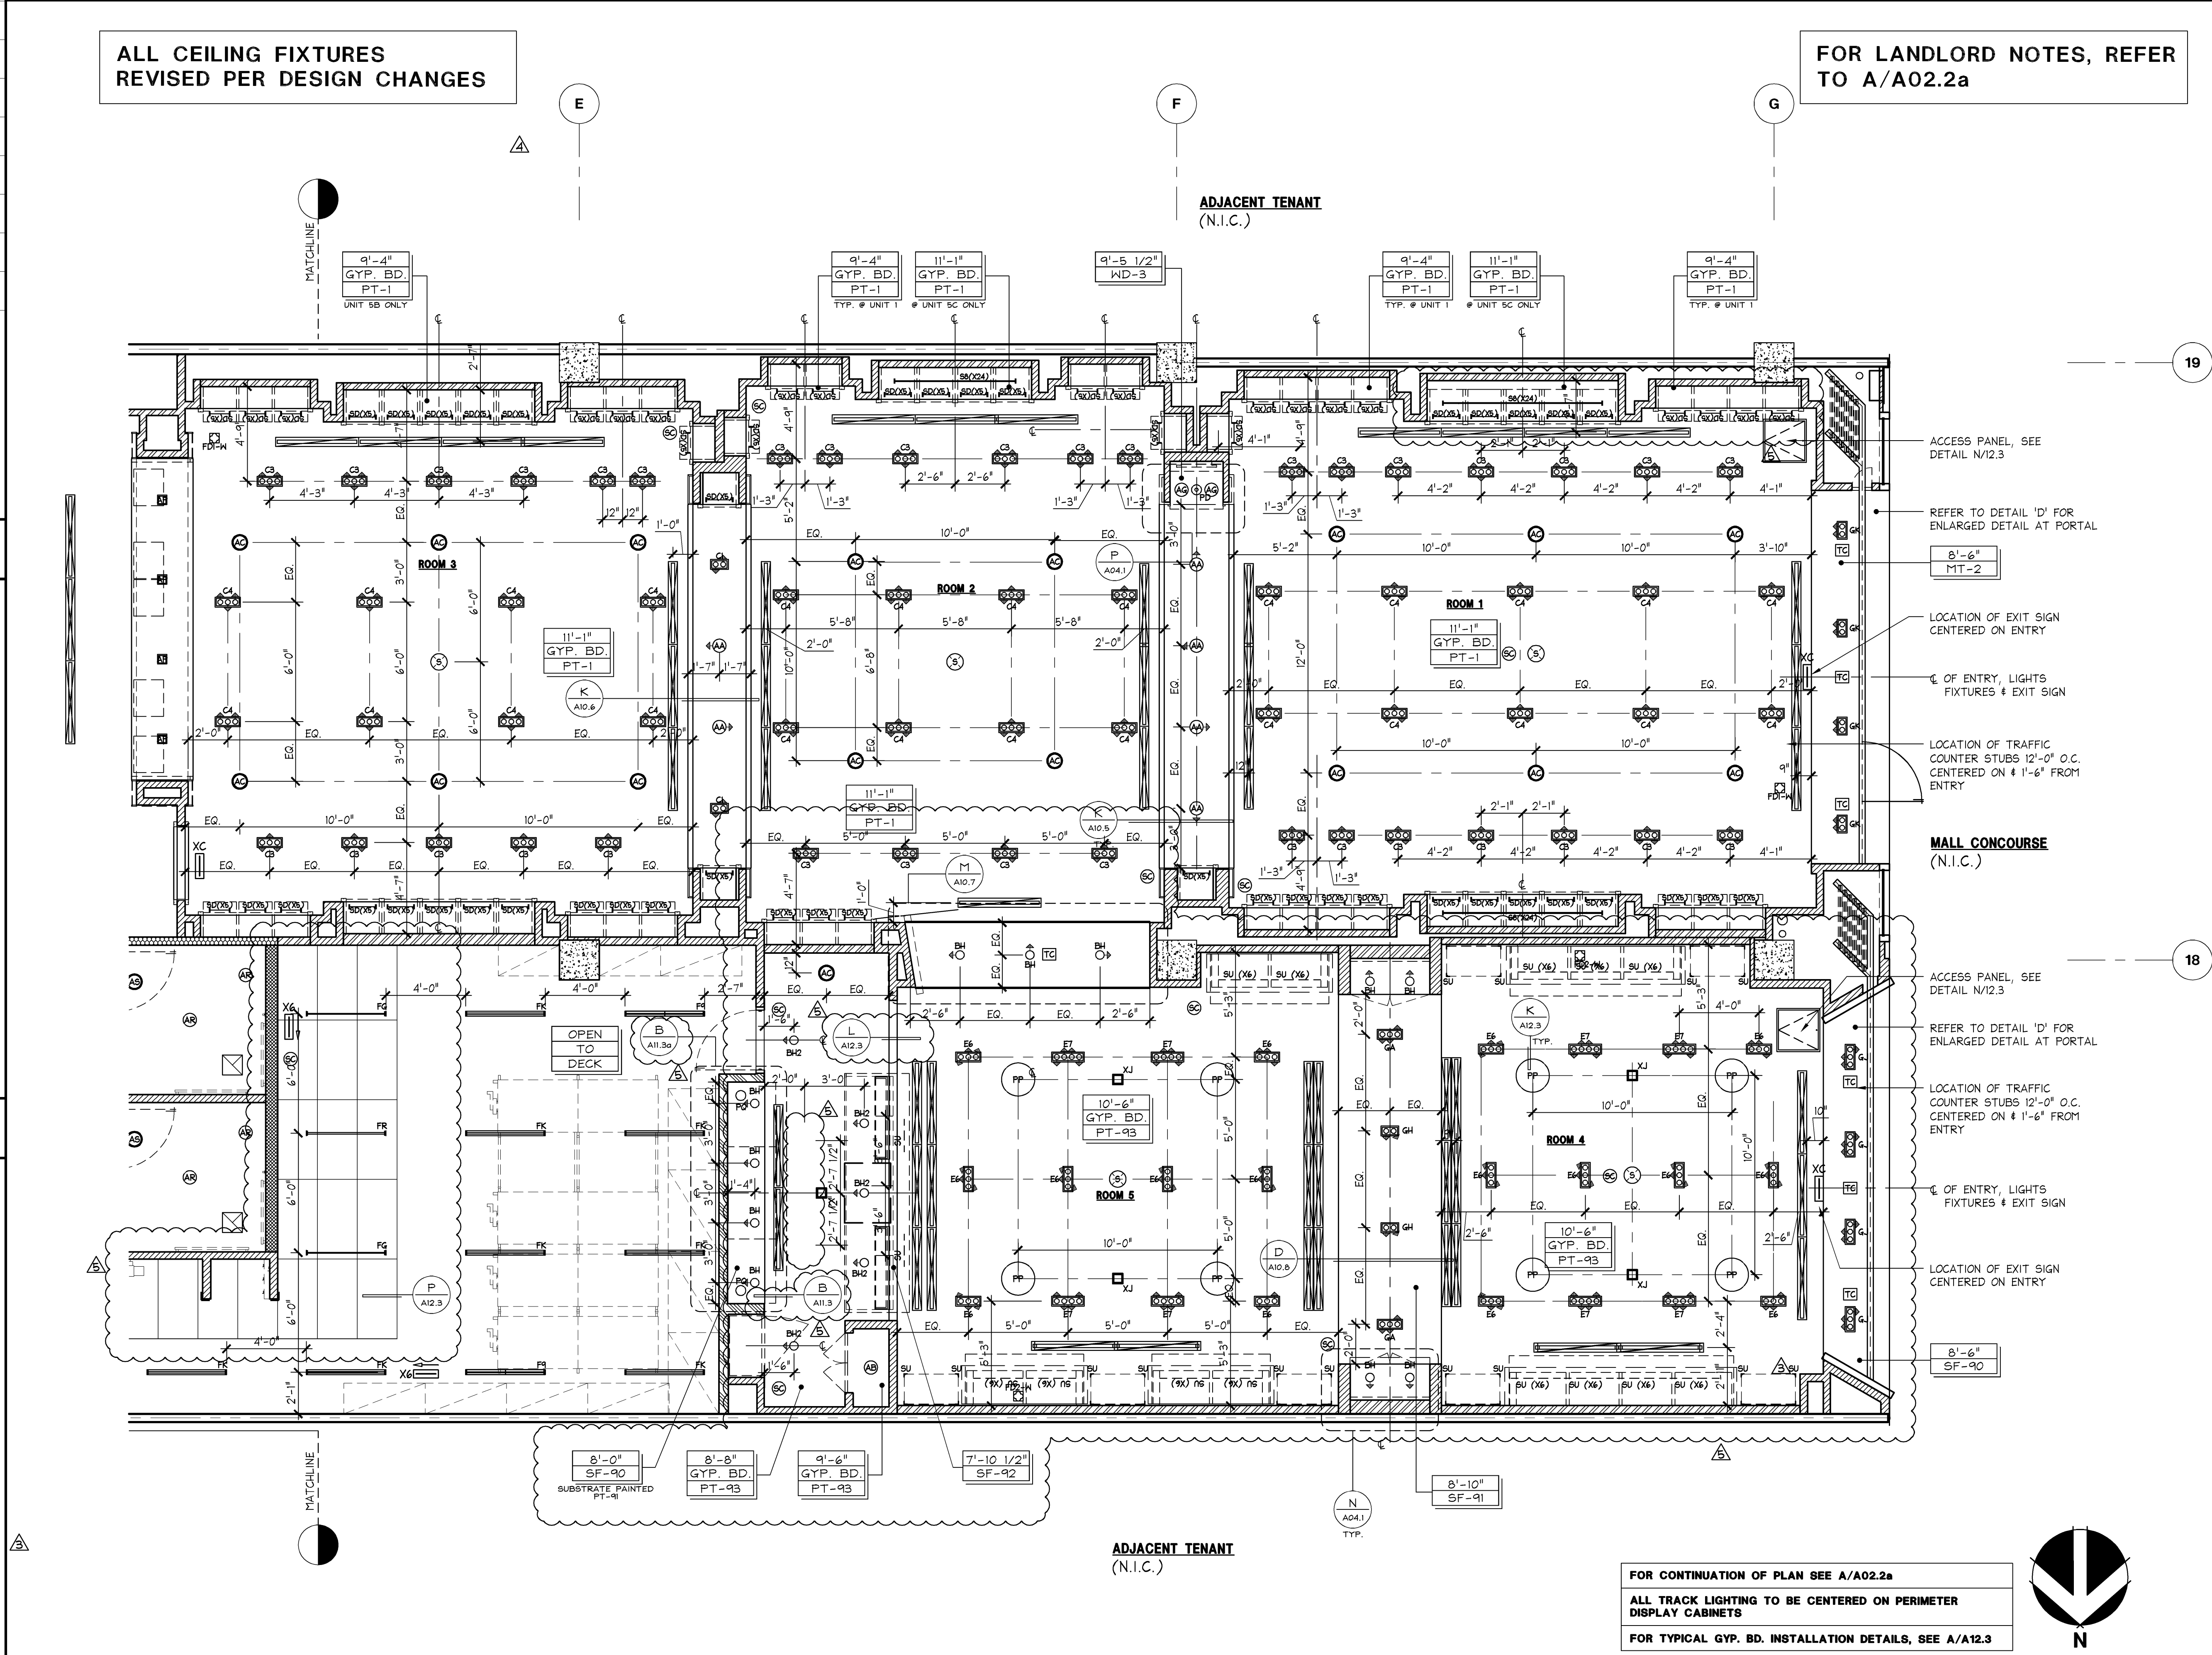

REFLECTED CEILING PLAN	1/4" = 1'-0"	A
	42P-A041-A01-PLAN	03.09.11

SHREMSHOCK

Shremshock Architects, Inc.

6150 S. Sandbury Rd., Westerville, OH 43081

T: 614 545 4550 | F: 614 545 4555 | shremshock.com

Gerald S. Shremshock, Architect

Timothy J. Shremshock, Architect

ELITE CONSTRUCTION GROUP

LAKE JACKSON, TX

PHONE: 979-284-0712

NOTE: THESE PRINTS HAVE BEEN REDUCED BY 50 PERCENT. SCALE WILL BE 50 PERCENT OF WHAT IS NOTED ON PLANS

limitedbrands

LIMITED STORE PLANNING, INC.

d/b/a STORE DESIGN & CONSTRUCTION

Three Limited Parkway • Columbus, Ohio 43230

Telephone: 614.415.7000 • Fax: 614.415.7349

PROJECT INFORMATION:

24200161

BATH & BODY WORKS

THE GALLERIA II

SPACE INDUSTRIES RD.

HOUSTON, TX 77056

SCOPE: REMODEL

DESIGN TYPE: EASTON-G

LSDAC PROJECT #:

REVISIONS:

NO.	REVISION	DATE
1	BUILDING DEPARTMENT COMMENTS	04/11/14
2	DESIGN CHANGES/ LANDLORD COMMENTS	05/07/14
3	MASTERS UPDATES	06/26/14
4	DESIGN CHANGES	06/27/14
5	DESIGN CHANGES	07/24/14

DATE ISSUED:

DESIGNED BY:

DRAWN BY:

CHECKED BY:

3/7/14

SB

JLH

RHW

REFLECTED CEILING PLAN

DRAWING NUMBER:

A04.1