
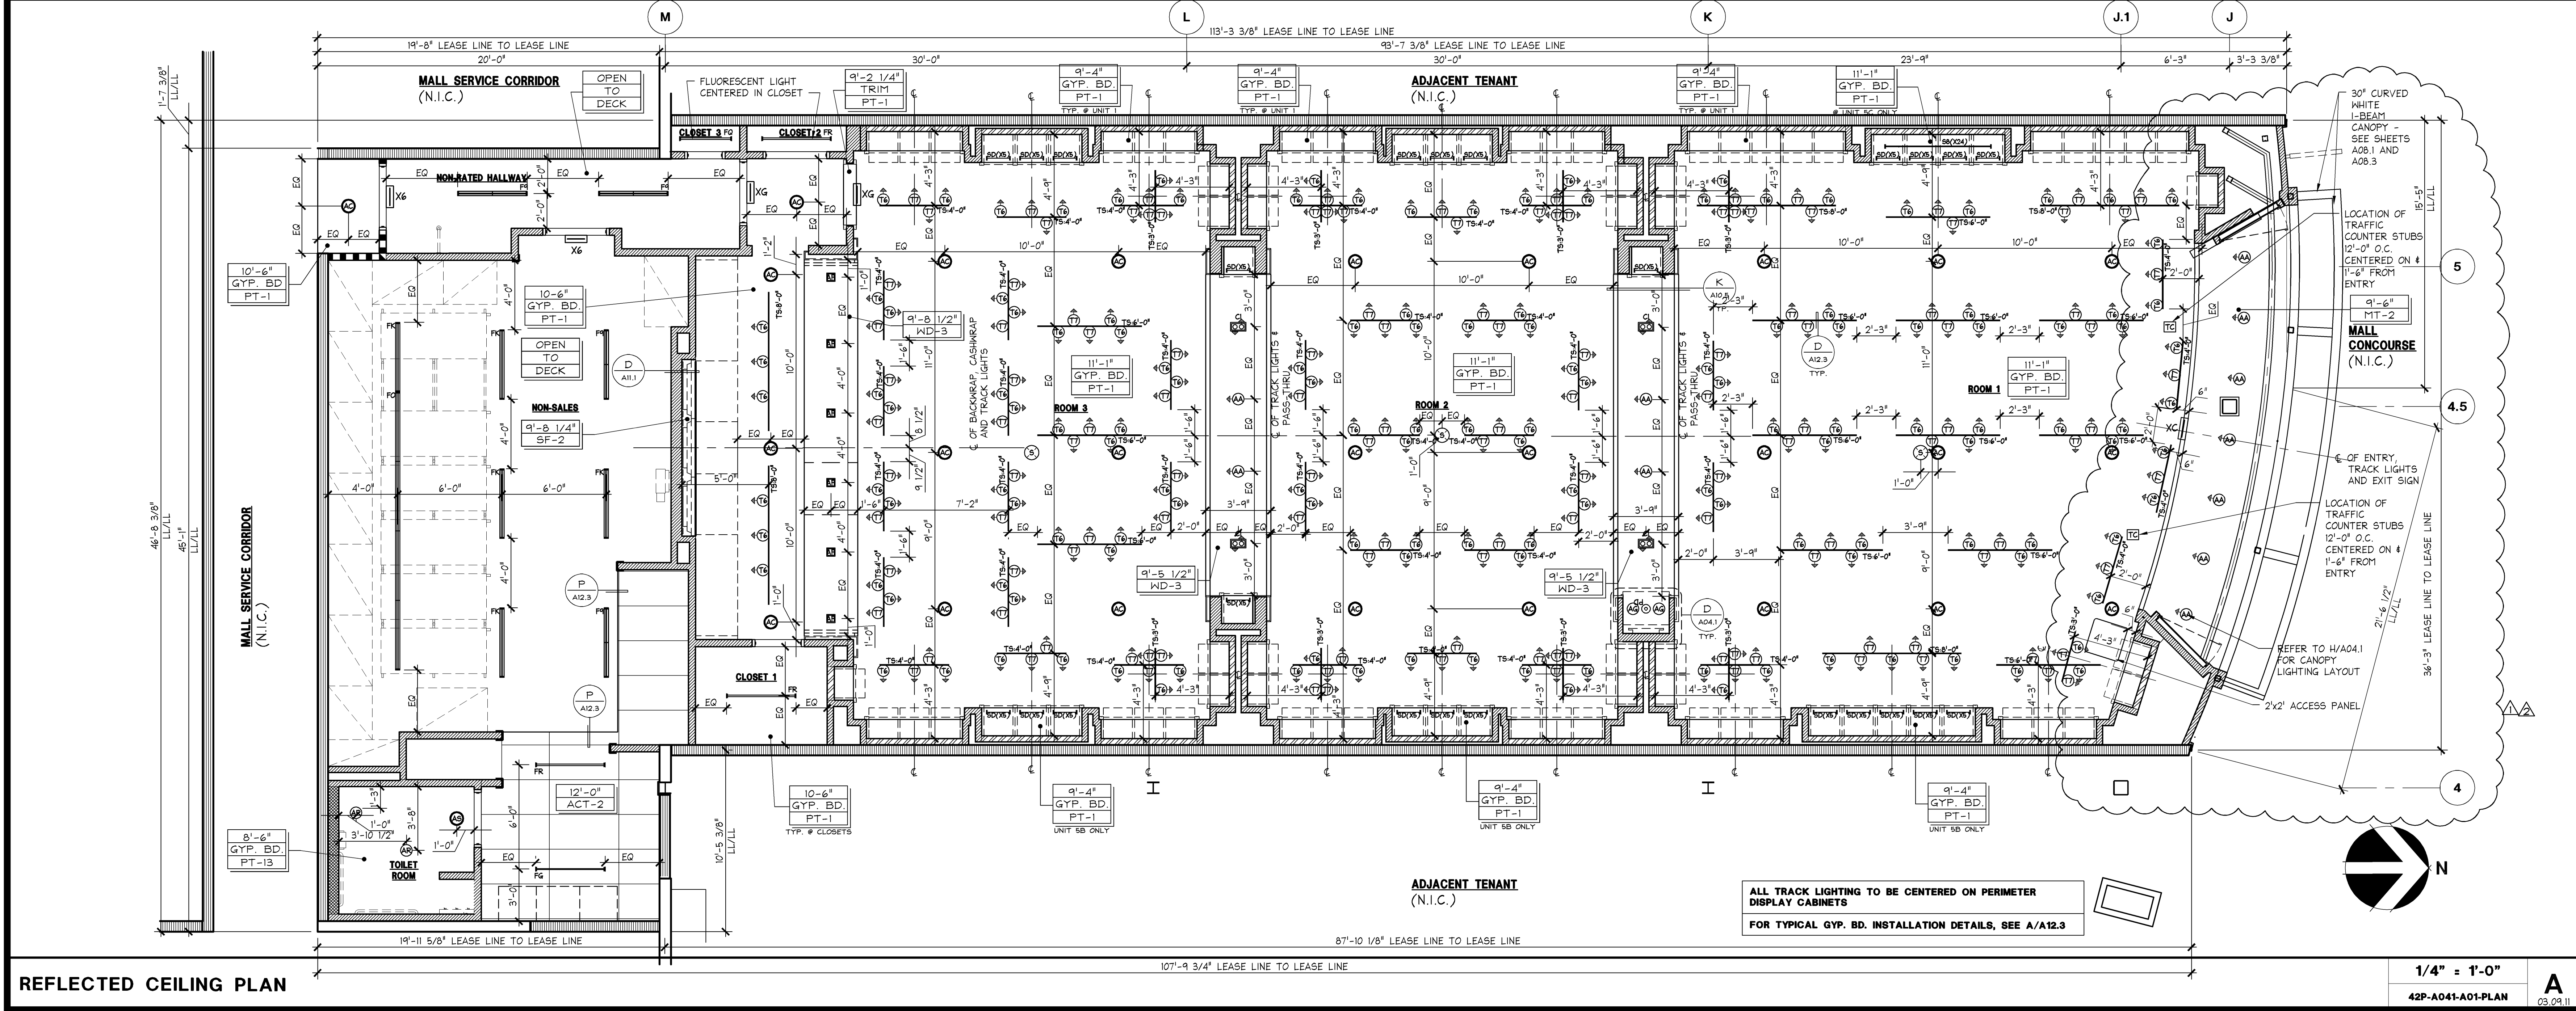
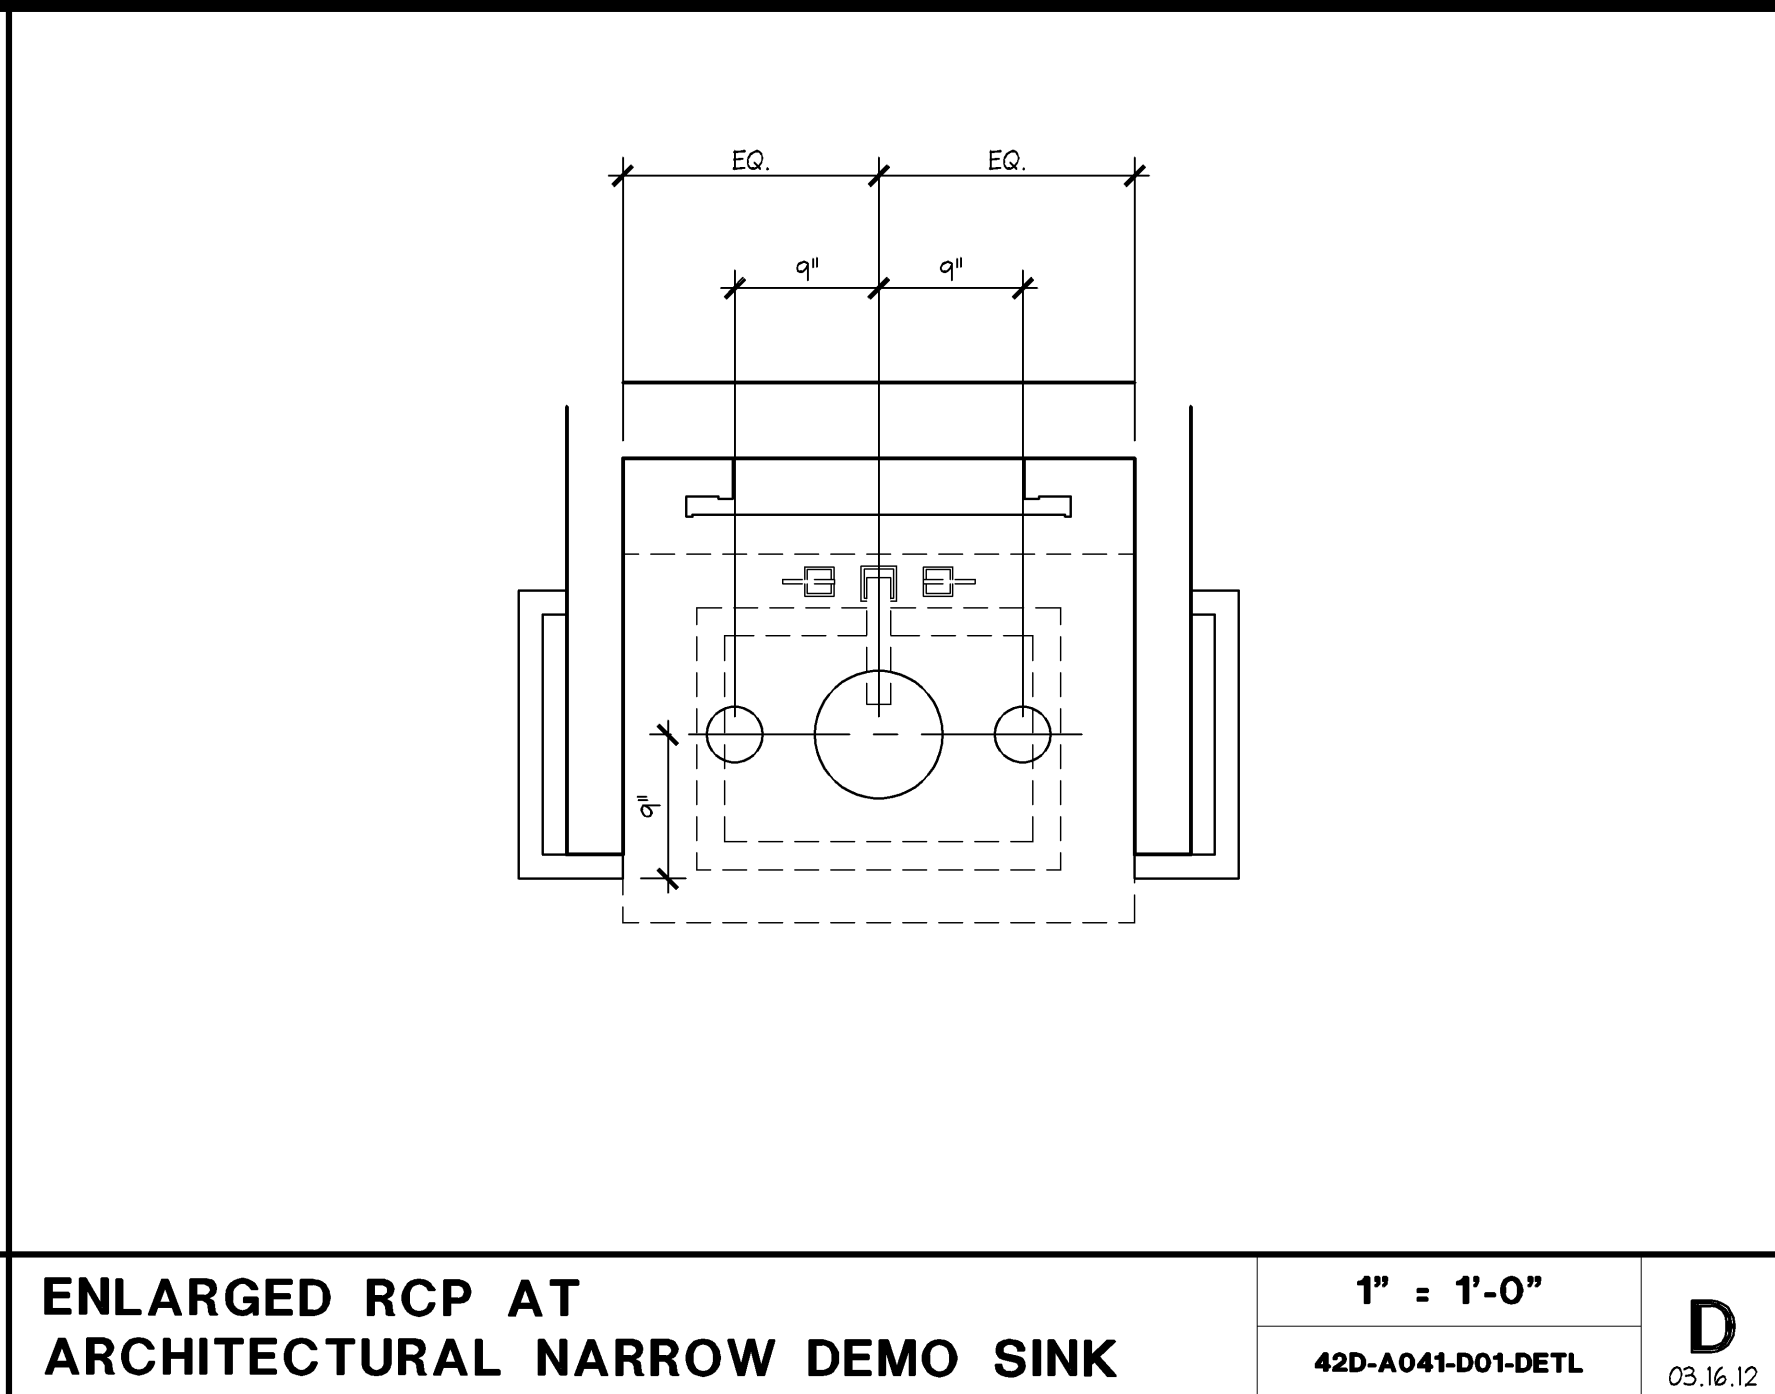


SYMBOL	DESCRIPTION
	RECESSED DOWNLIGHT
	TRACK W/ TRACK HEADS
	FLUORESCENT STRIPS - SURFACE MOUNTED
	FLUORESCENT STRIPS - CHAIN-HUNG FROM STRUCTURE 12'-0" A.F.F.
	MULTI-LAMP RECESSED DOWNLIGHT
	SURFACE MOUNTED FLUORESCENT LIGHT W/ ACRYLIC LENS
	EGRESS SIGNAGE
	EMERGENCY LIGHT
	SPEAKER
	SUPPLY DIFFUSER
	RETURN AIR GRILLE
	CEILING ACCESS PANEL
	EXHAUST AIR REGISTER
	MARKETING RAIL
	PENDANT LIGHT - MOUNTED 7'-6" A.F.F.
	BILLBOARD LIGHT
	CCTV VIEWING MONITOR
	CCTV CAMERA - SUPPLIED AND INSTALLED BY SECURITY VENDOR
	TRAFFIC COUNTER
	SCENT AIR

- NOTES:
1. ALL CEILING HEIGHTS ARE FROM THE TOP OF FINISH FLOOR TO UNDERSIDE OF FINISH CEILING.
 2. PROVIDE ADEQUATE CLEARANCES FOR FIXTURES, DUCTS, CEILINGS, AND RELATED PERTINENT ITEMS NECESSARY TO MAINTAIN THE SPECIFIED HEIGHTS ABOVE FINISH FLOOR.
 3. ADDITIONAL HANGER AND SAFETY WIRES FOR LIGHT FIXTURES, SPEAKERS AND DUCTWORK, AS REQUIRED BY LOCAL CODES, TO BE THE RESPONSIBILITY OF THE CEILING SUBCONTRACTOR.
 4. SPRINKLER HEAD LAYOUT TO CONFORM TO LOCAL CODE, TAKING IN ACCOUNT LOCATIONS OF DUCTWORK, LIGHTING AND LOCATION OF TENANT'S CABINET, FIXTURE AND SHELVING UNITS.
 5. ARCHITECTURAL DRAWINGS DETERMINE LOCATION OF LUMINAIRES AND SUPERSEDE ALL OTHERS, U.O.N.
 6. AFTER INSTALLATION, ELECTRICAL CONTRACTOR IS TO TILT THE LAMP IN ALL "T" FIXTURES @ A 45 DEGREE ANGLE TOWARD WALL OR CABINETS.
 7. SEE LIGHT FIXTURE SCHEDULE ON ELECTRICAL DRAWINGS FOR FIXTURE MODEL NUMBERS KEYS TO THE LIGHTING AND CEILING LEGEND.
 8. NO EMERGENCY LIGHTS, EXIT LIGHTS OR SENSORS ARE TO BE PLACED ON THE PERIMETER SALED WALLS.

CEILING AND LIGHTING LEGEND	1/4" = 1'-0"	R
	42L-A041-L01-LGMD	04.26.10

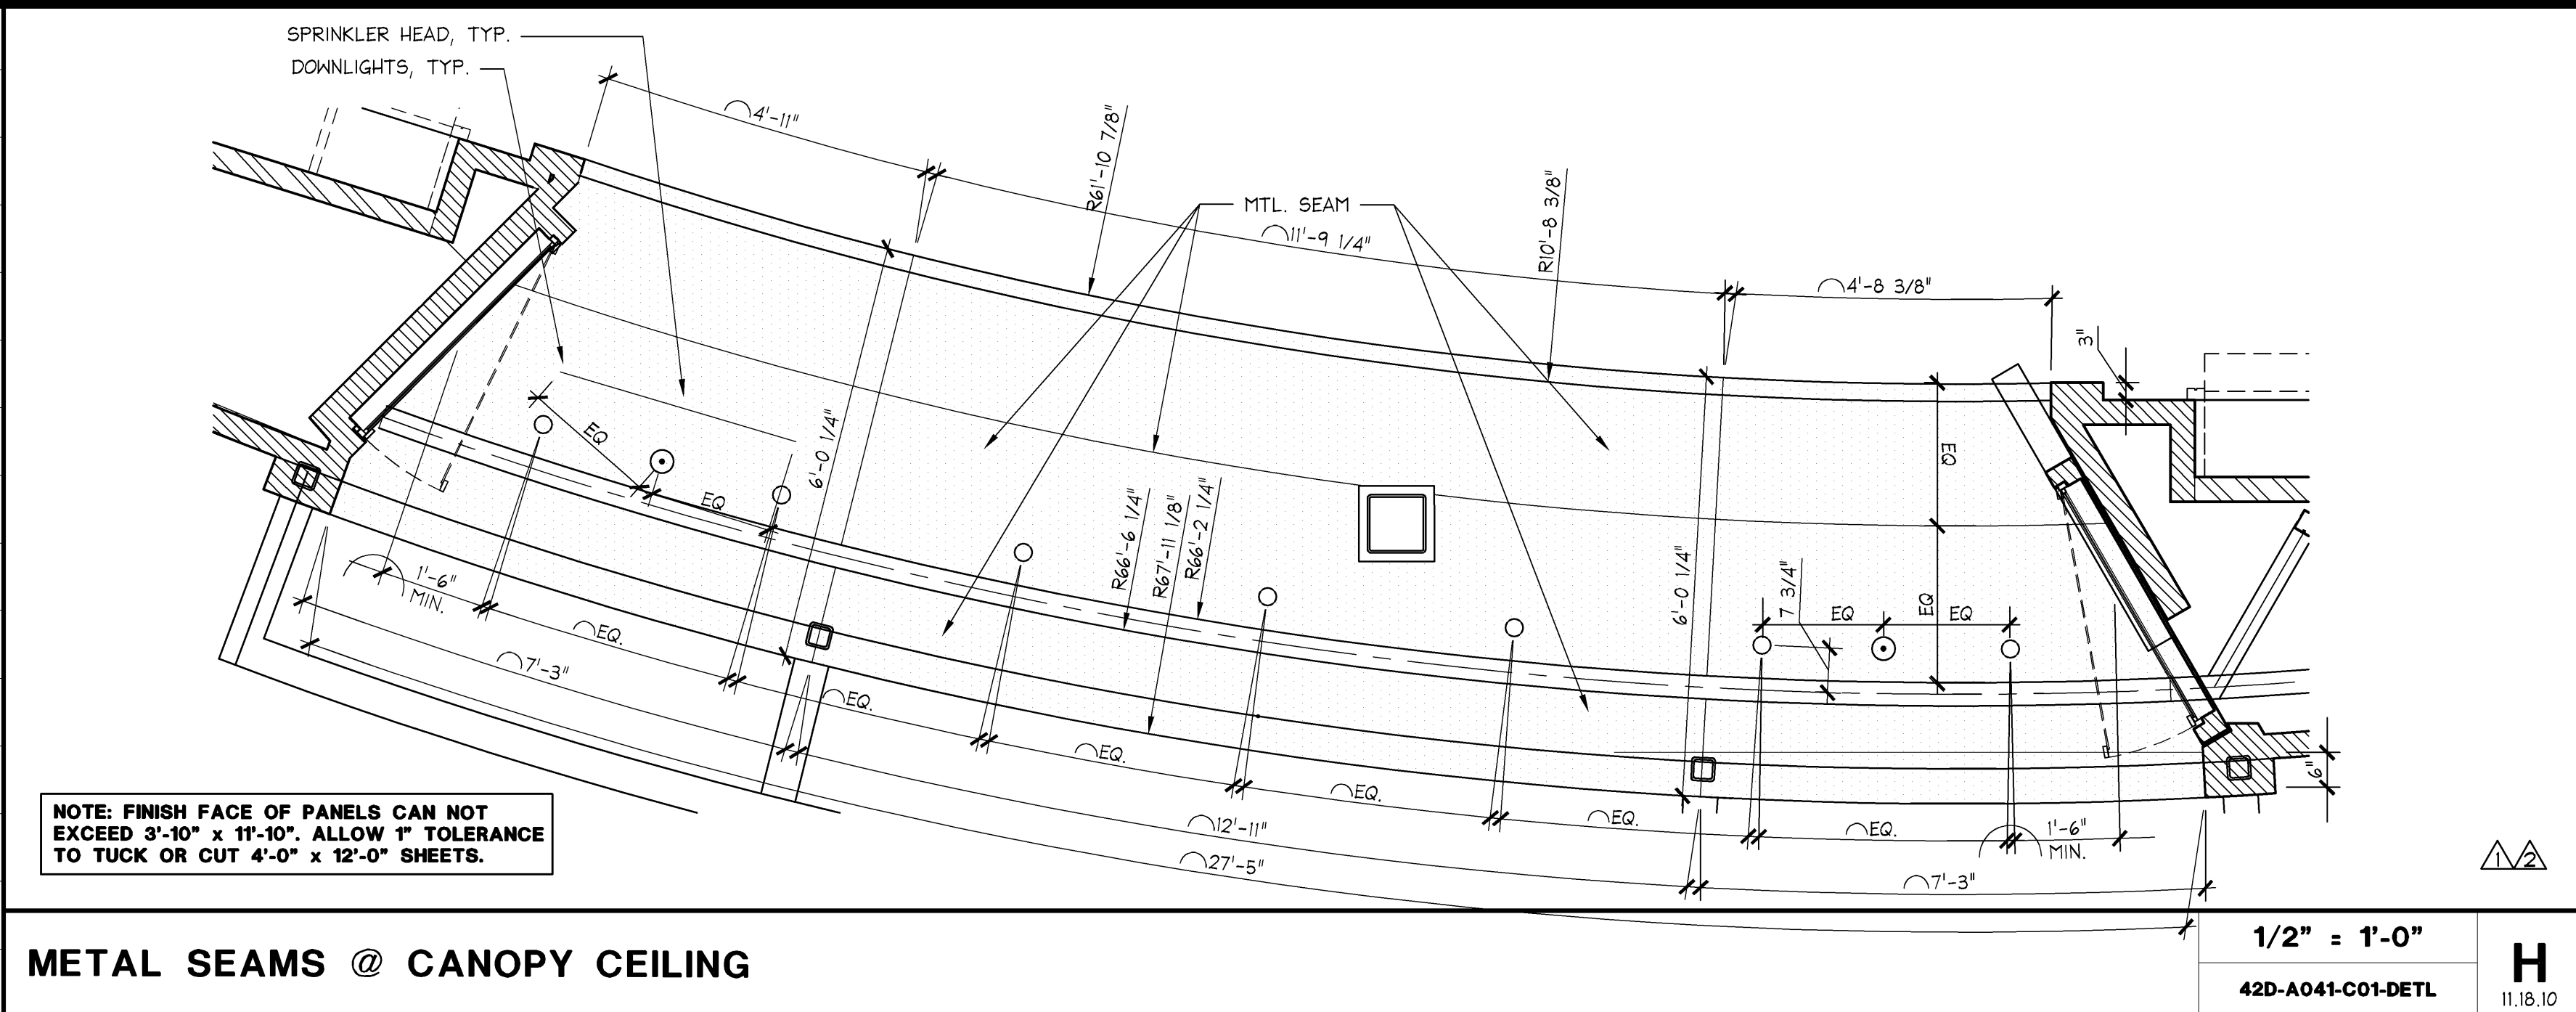

MOODY-NOLAN
responsive architecture
300 Spruce Street Phone: (614) 461-4664
Suite 300 Fax: (614) 280-8881
Columbus, Ohio 43215 www.moodynolan.com

Limitedbrands
LIMITED STORE PLANNING, INC.
d/b/a STORE DESIGN & CONSTRUCTION
Three Limited Parkway • Columbus, Ohio 43230
Telephone: 614.415.7000 • Fax: 614.415.7349

THESE DRAWINGS AND SPECIFICATIONS ARE THE PROPERTY OF LSCD AND SHALL NOT BE REPRODUCED OR TRANSMITTED IN ANY FORM OR BY ANY MEANS, ELECTRONIC OR MECHANICAL, INCLUDING PHOTOCOPYING, RECORDING, OR BY ANY INFORMATION STORAGE AND RETRIEVAL SYSTEM, WITHOUT THE WRITTEN PERMISSION OF LSCD. THESE DRAWINGS AND SPECIFICATIONS ARE THE PROPERTY OF LSCD AND SHALL NOT BE REPRODUCED OR TRANSMITTED IN ANY FORM OR BY ANY MEANS, ELECTRONIC OR MECHANICAL, INCLUDING PHOTOCOPYING, RECORDING, OR BY ANY INFORMATION STORAGE AND RETRIEVAL SYSTEM, WITHOUT THE WRITTEN PERMISSION OF LSCD. THESE DRAWINGS AND SPECIFICATIONS ARE THE PROPERTY OF LSCD AND SHALL NOT BE REPRODUCED OR TRANSMITTED IN ANY FORM OR BY ANY MEANS, ELECTRONIC OR MECHANICAL, INCLUDING PHOTOCOPYING, RECORDING, OR BY ANY INFORMATION STORAGE AND RETRIEVAL SYSTEM, WITHOUT THE WRITTEN PERMISSION OF LSCD.

024200396

BATH & BODY WORKS

MEMORIAL CITY MALL

303 MEMORIAL CITY WAY

HOUSTON, TX 77024

RELO DOWN / NEW PACKAGE:

SCOPE: EASTON-G

DESIGN TYPE: 60685

LSDAC PROJECT #: A/E PROJECT #:

PROJECT INFORMATION:

REVISIONS:

ELITE CONSTRUCTION GROUP

LAKE JACKSON, TX

PHONE: 979-284-0712

NOTE: THESE PRINTS HAVE BEEN REDUCED BY 50 PERCENT SCALE. WILL BE 50 PERCENT OF WHAT IS NOTED ON PLANS.

DATE ISSUED: 04/11/2014

DESIGNED BY: SF

DRAWN BY: TSG

CHECKED BY: TBD

REFLECTED CEILING PLAN

DRAWING NUMBER:

A04.1