




GAS PIPING SUPPORT DETAIL 1" = 1'-0" S 00D-P0301-S00-GPSP 09/03/2015

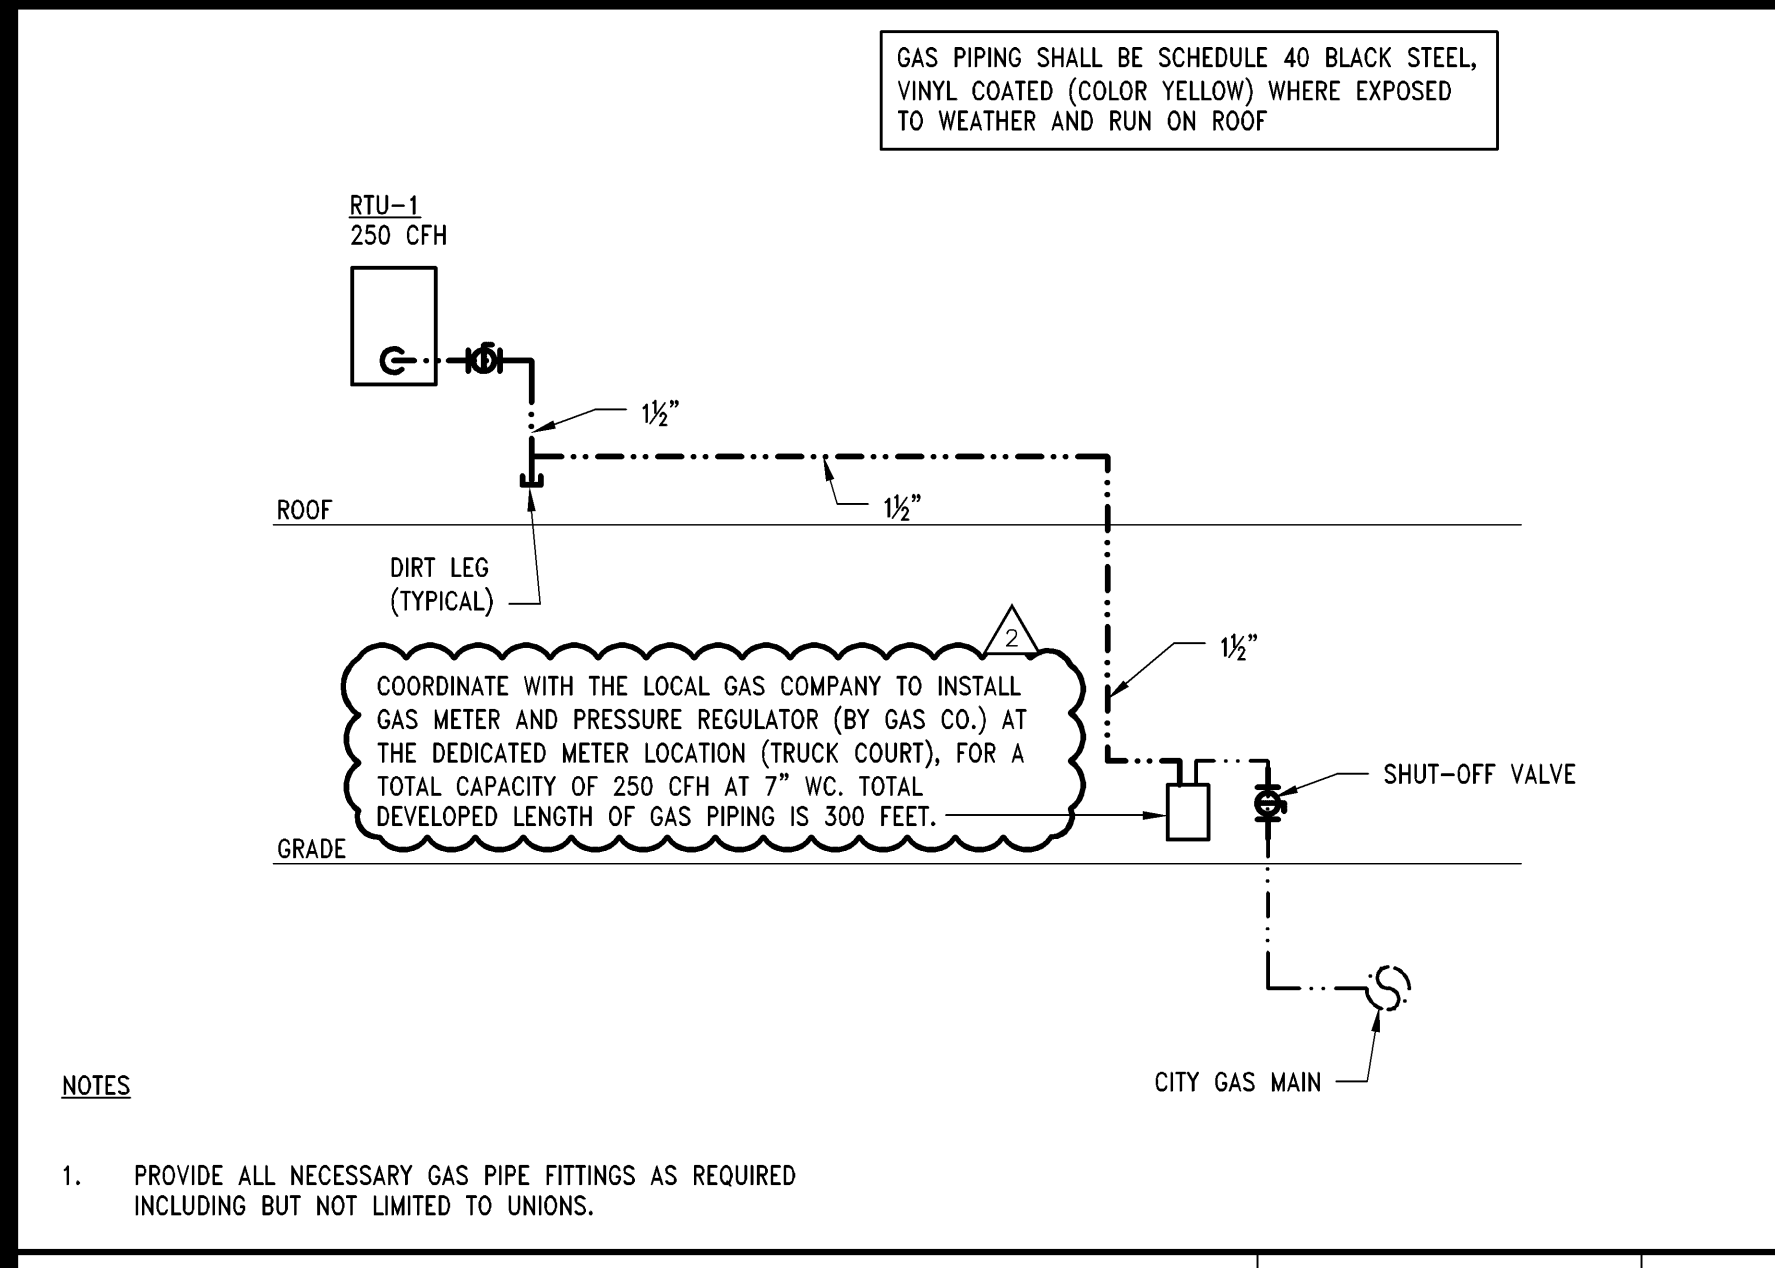


GAS PIPING DIAGRAM NTS 00D-P0301-M00-GSPD 09/03/2015

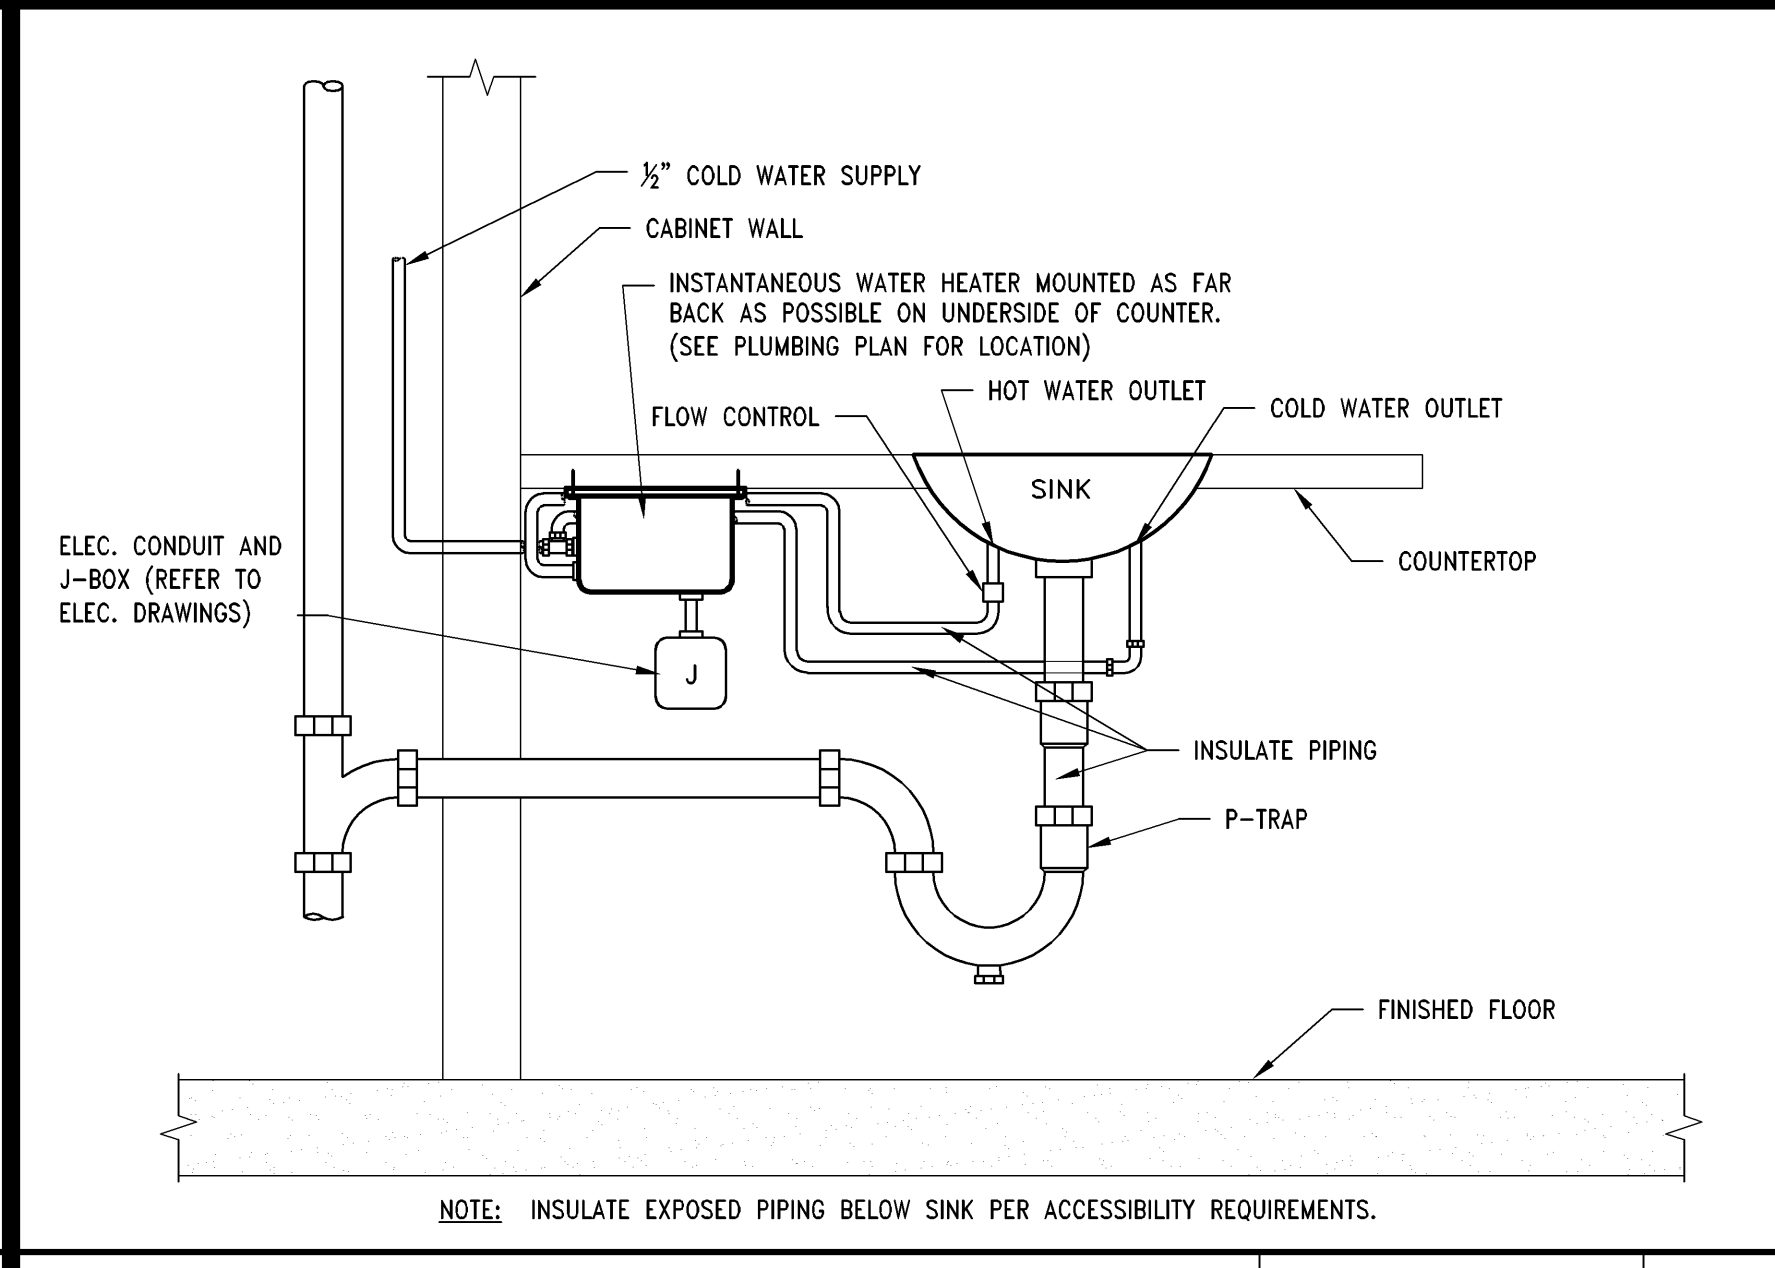


DEMONSTRATION SINK DETAIL NTS 42D-P0301-H02-DEMO 09/03/2015

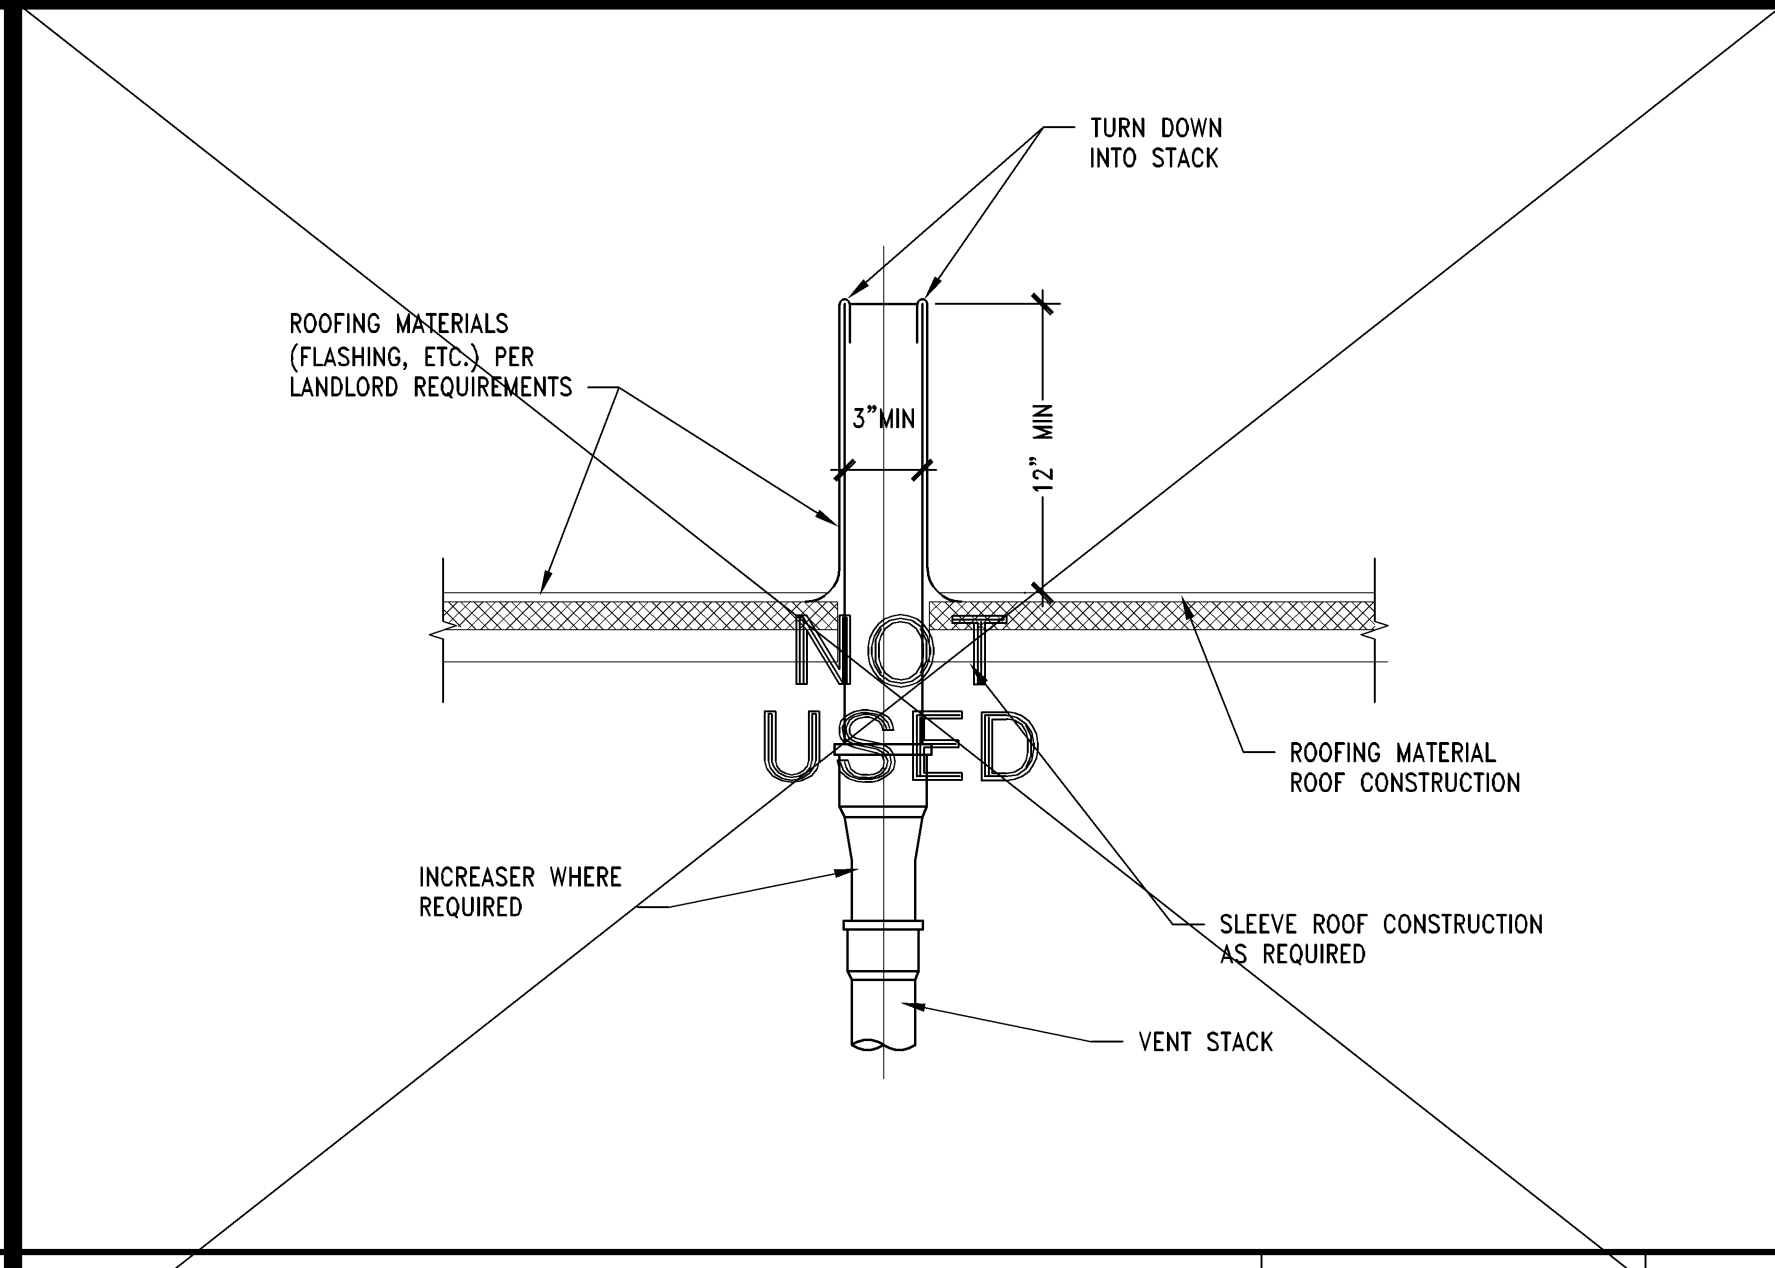


VENT THRU ROOF DETAIL 1-1/2"=1'-0" D 00D-P0301-D00-VTR 09/03/2015

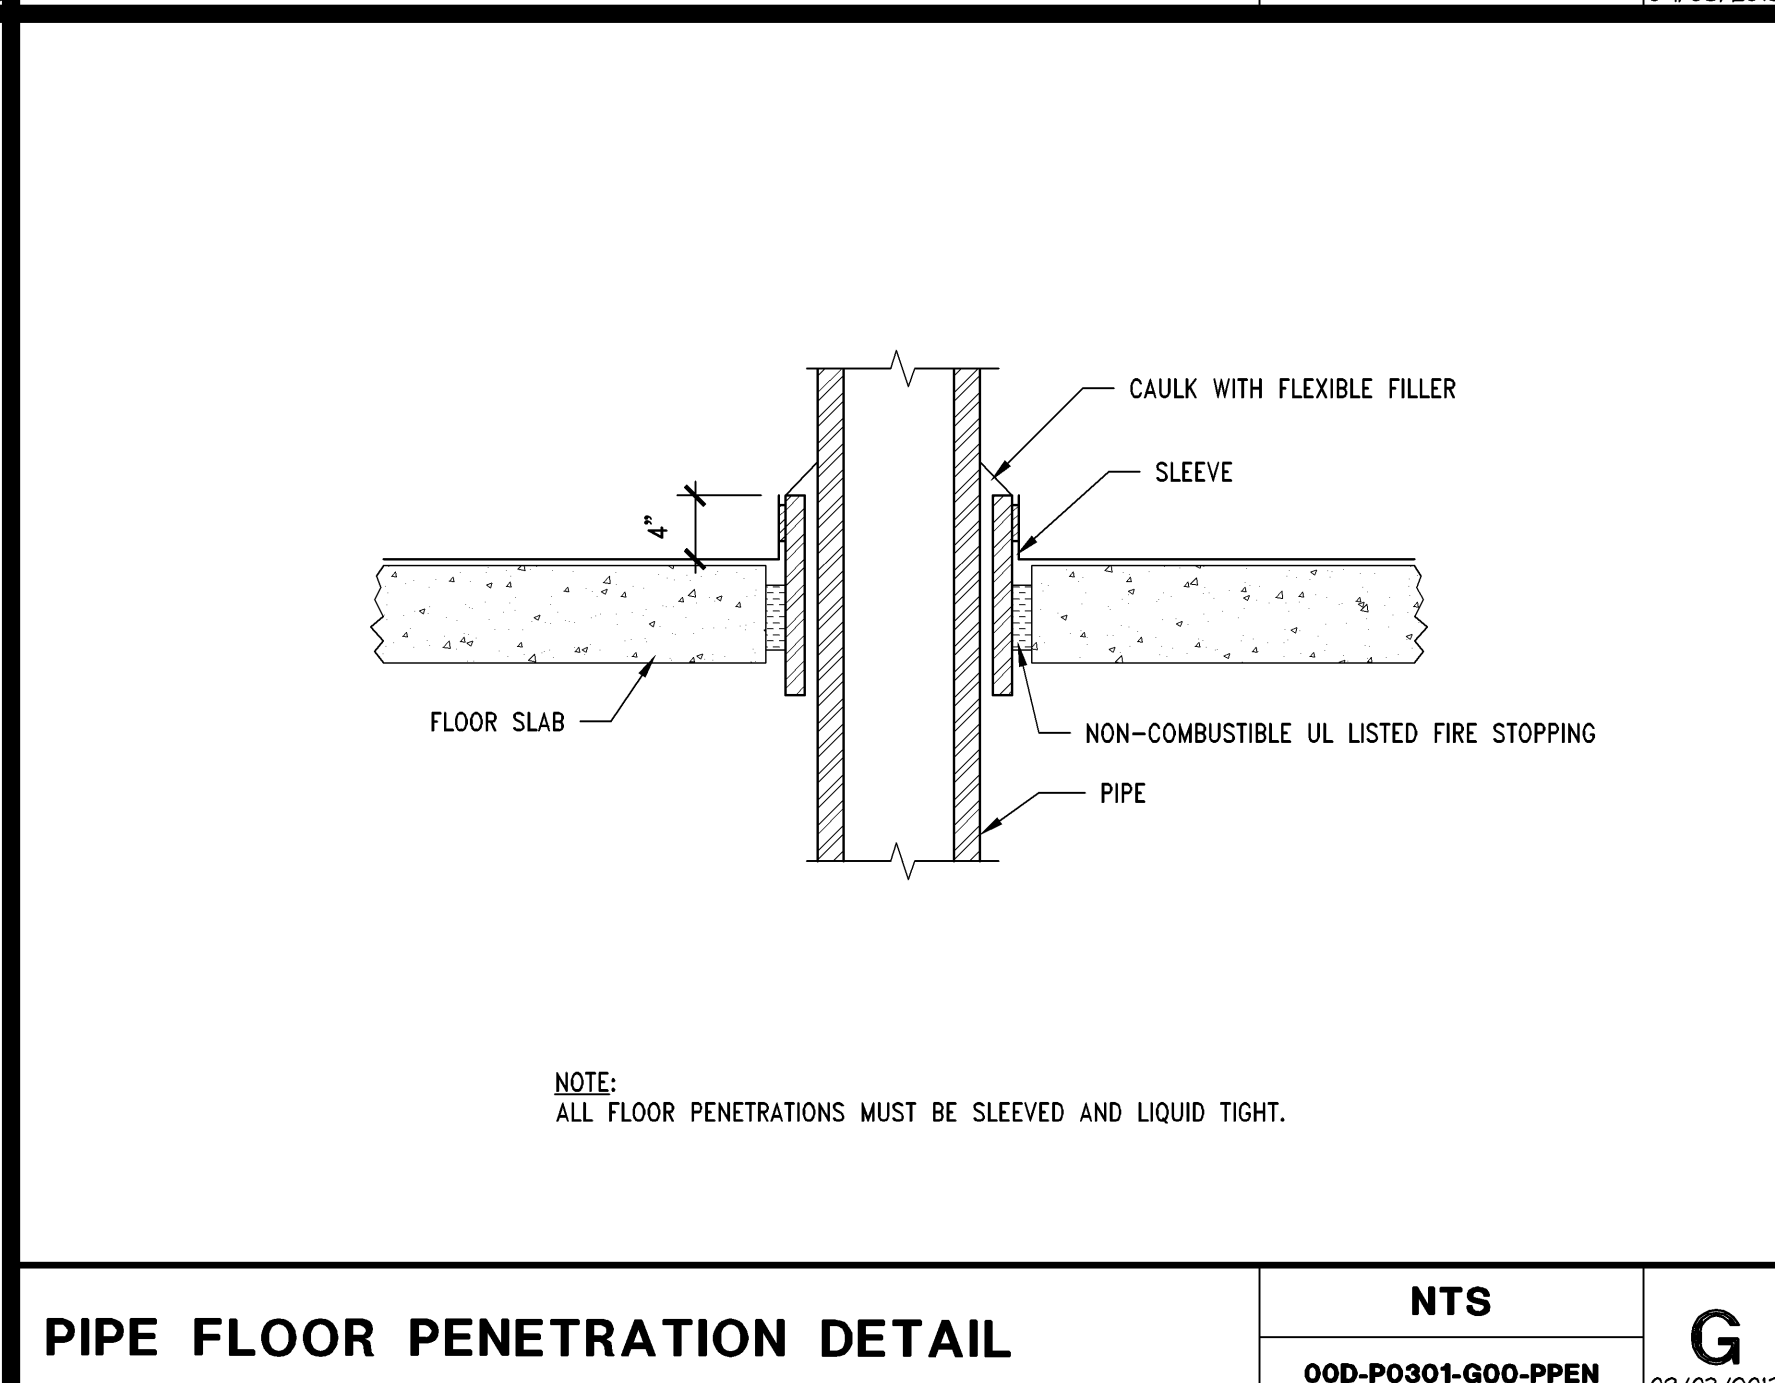


PIPE FLOOR PENETRATION DETAIL NTS 00D-P0301-G00-PPEN 09/03/2015

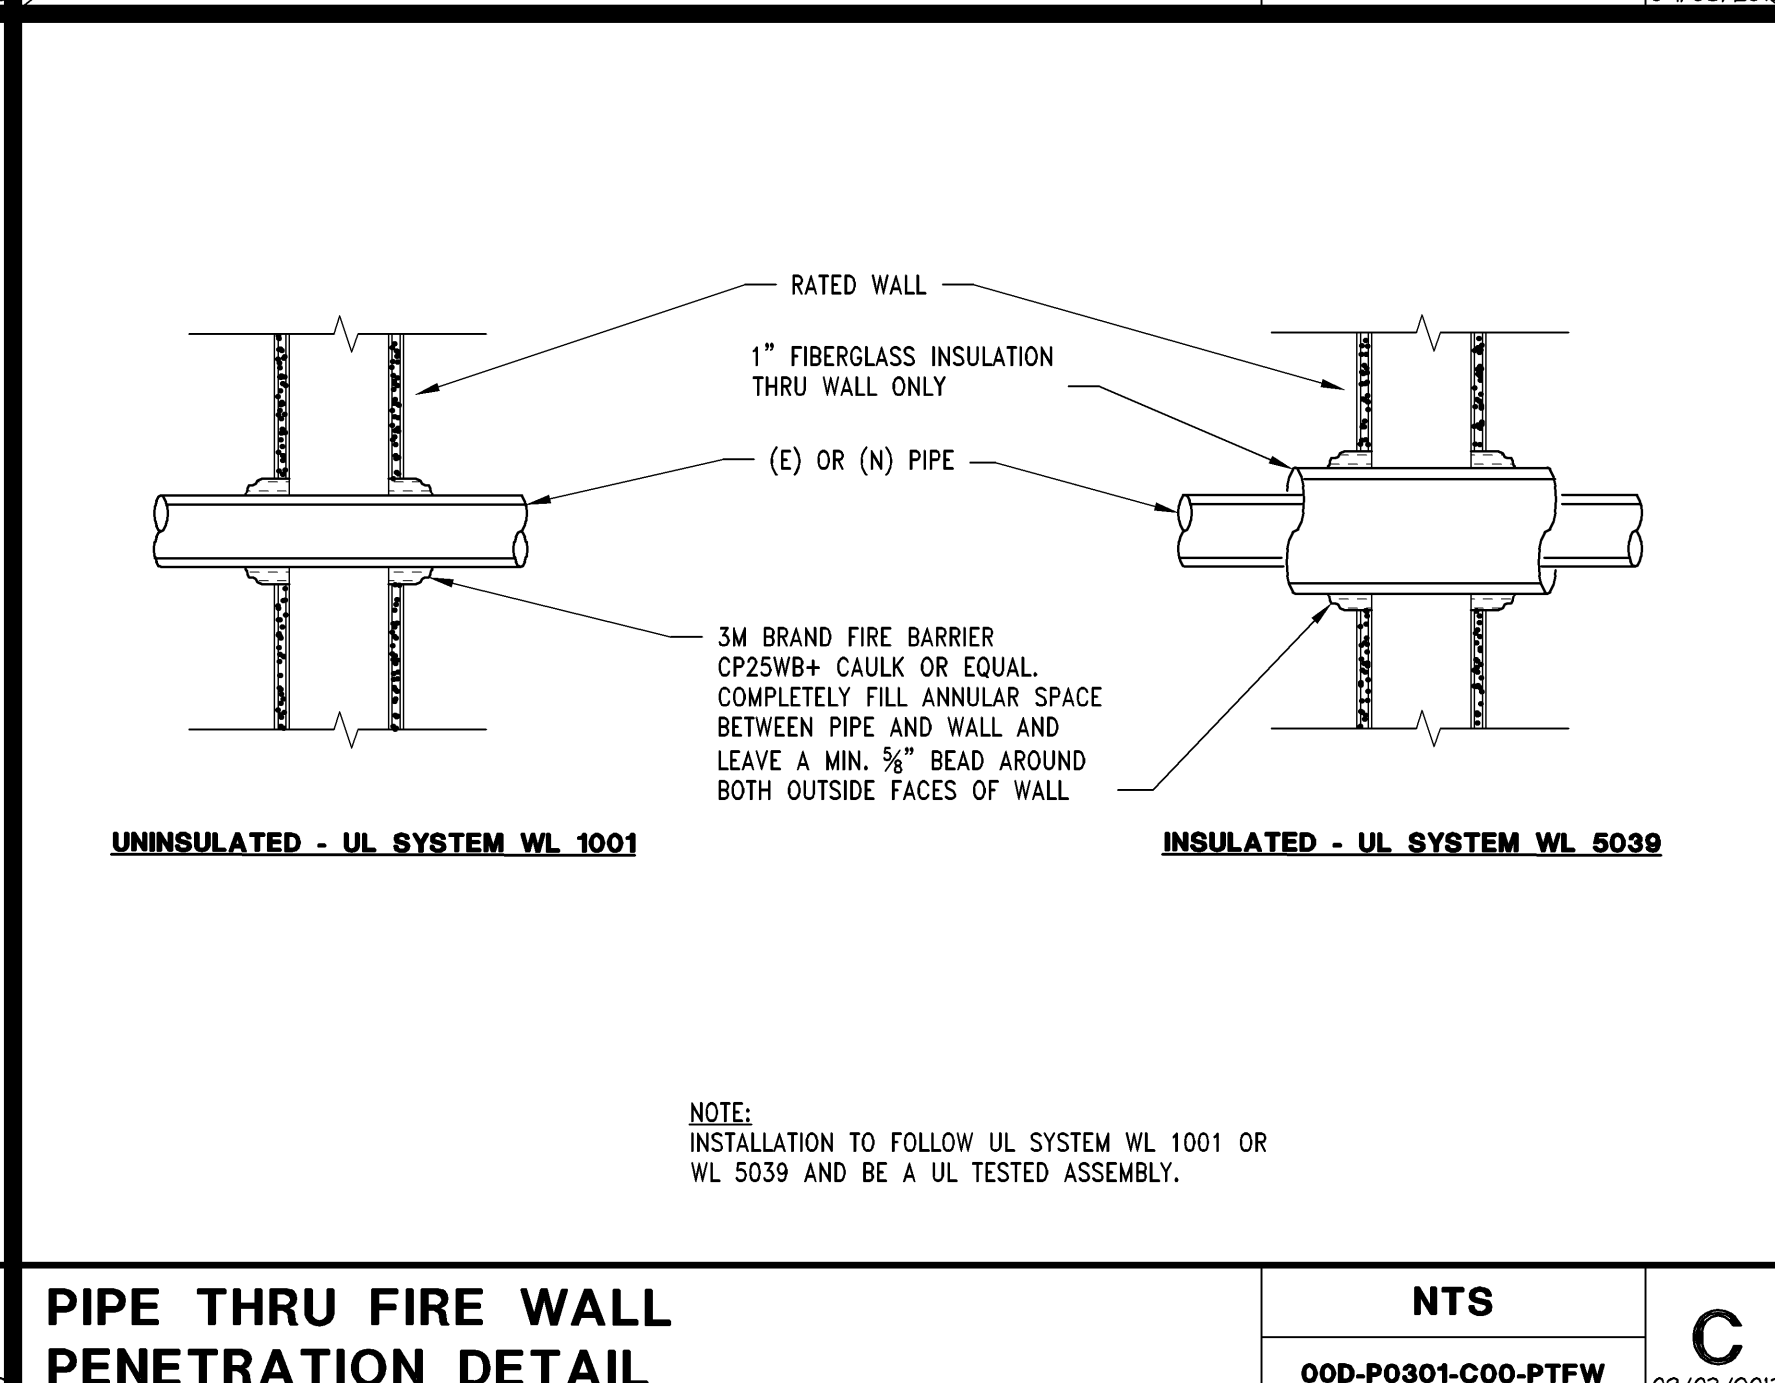


PIPE THRU FIRE WALL PENETRATION DETAIL NTS 00D-P0301-C00-PTFW 09/03/2015

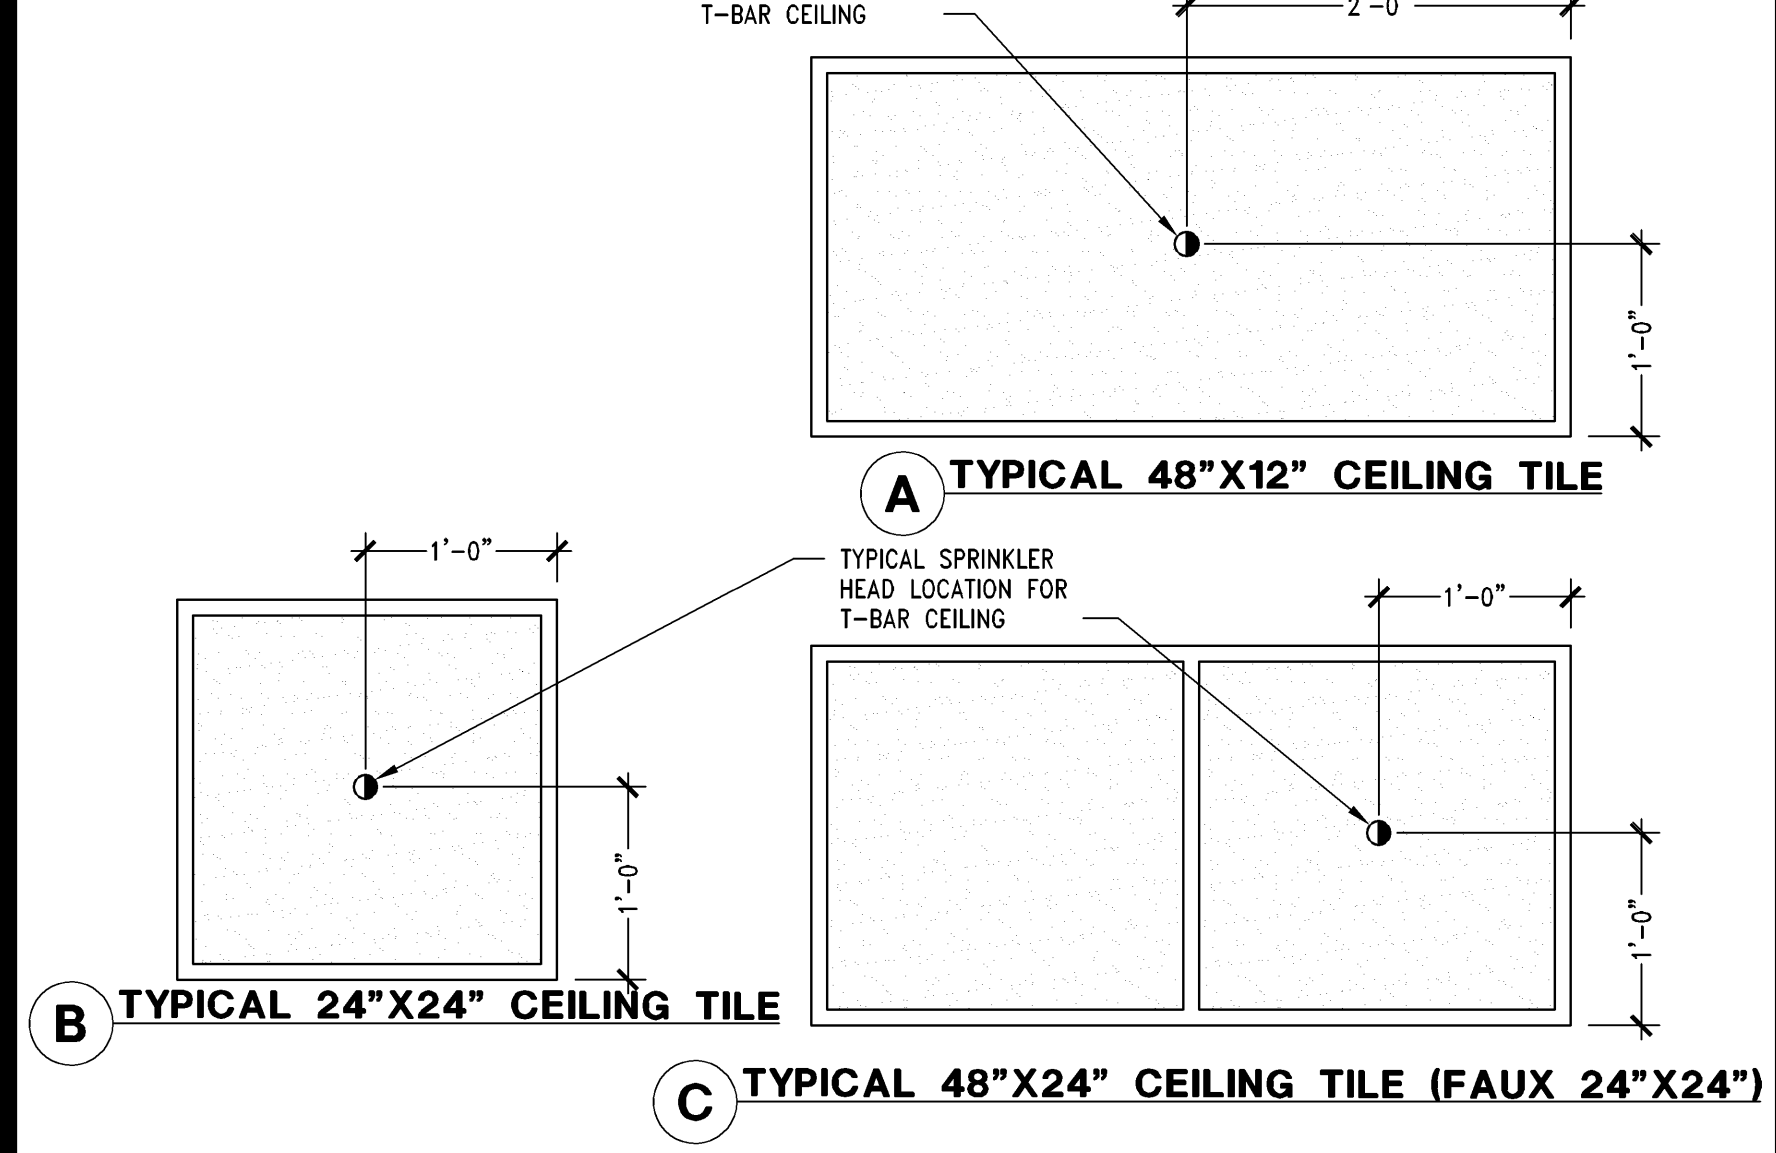


FIRE SPRINKLER HEAD LOCATION DETAILS 1" = 1'-0" P 00D-P0301-P00-FSHL 09/03/2015

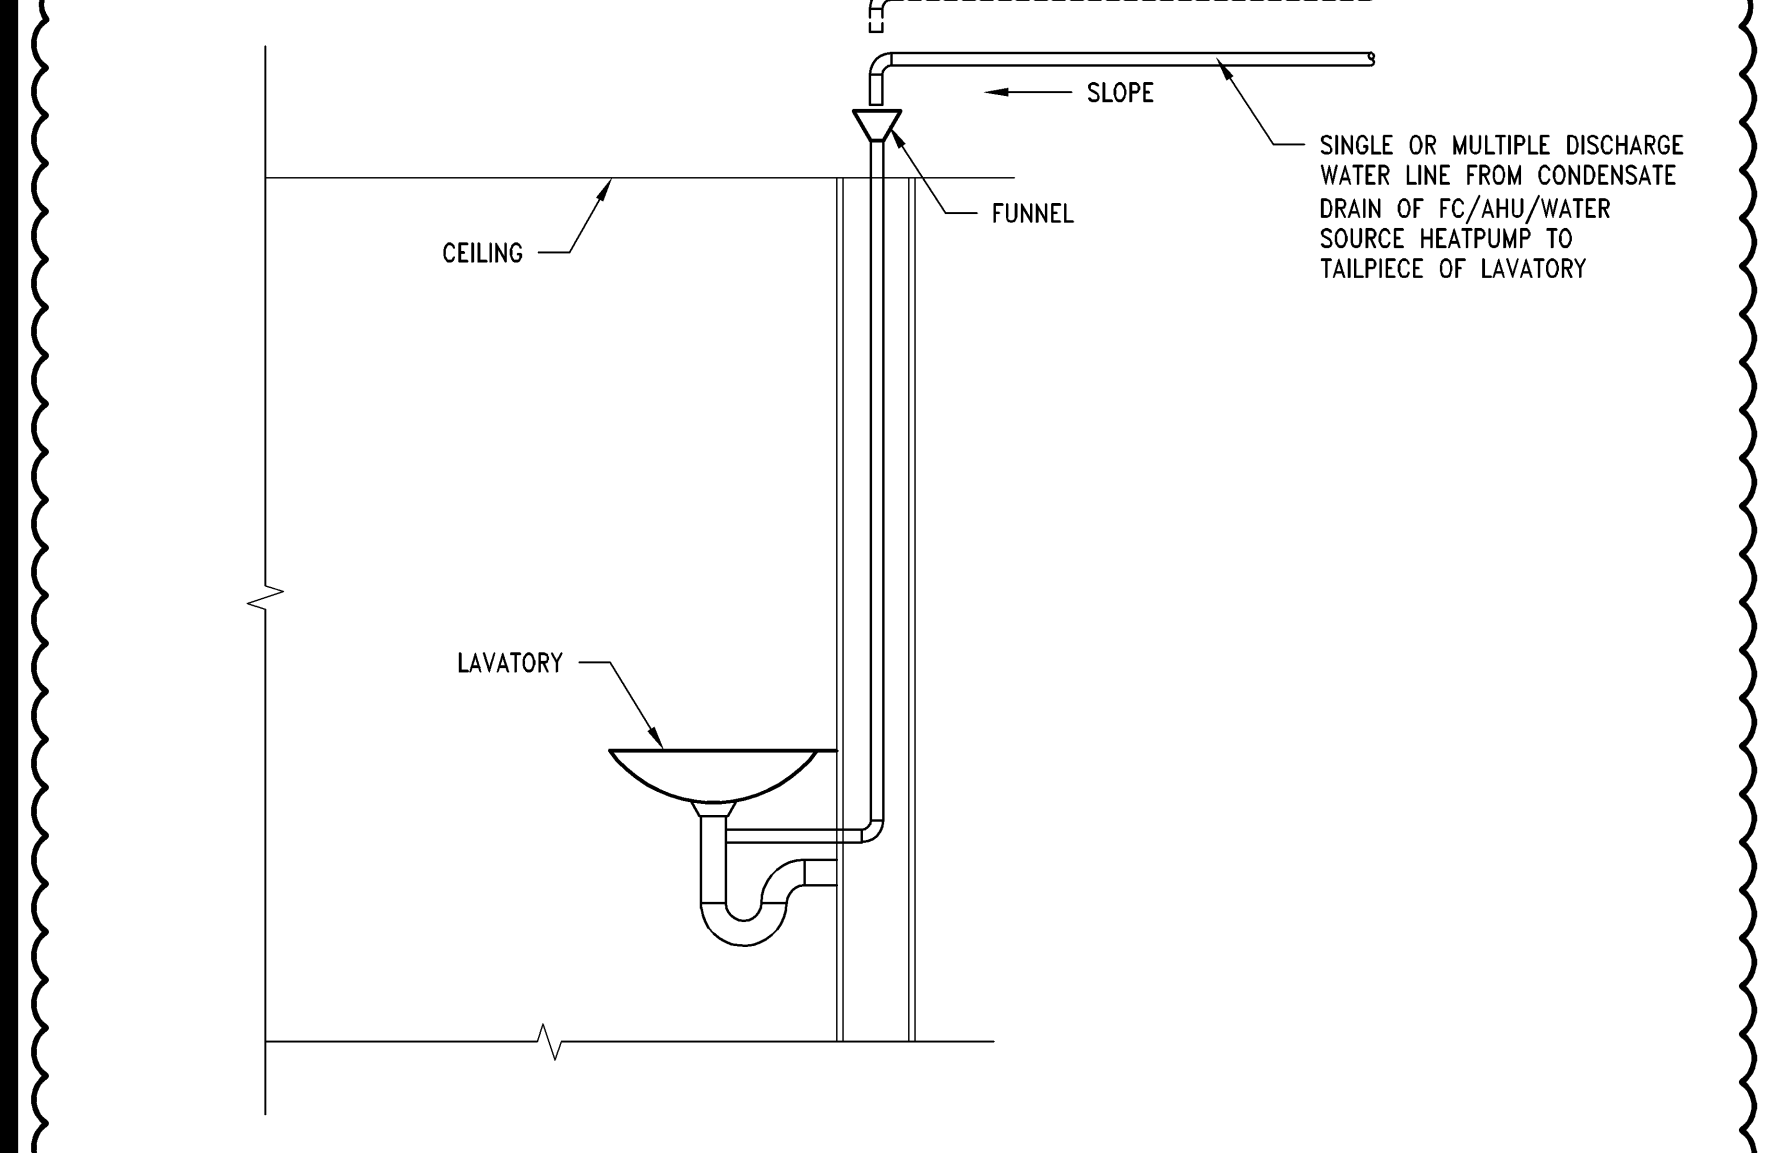


CONDENSATE DRAIN DETAIL NTS 00D-P0301-K02-COBD 09/03/2015

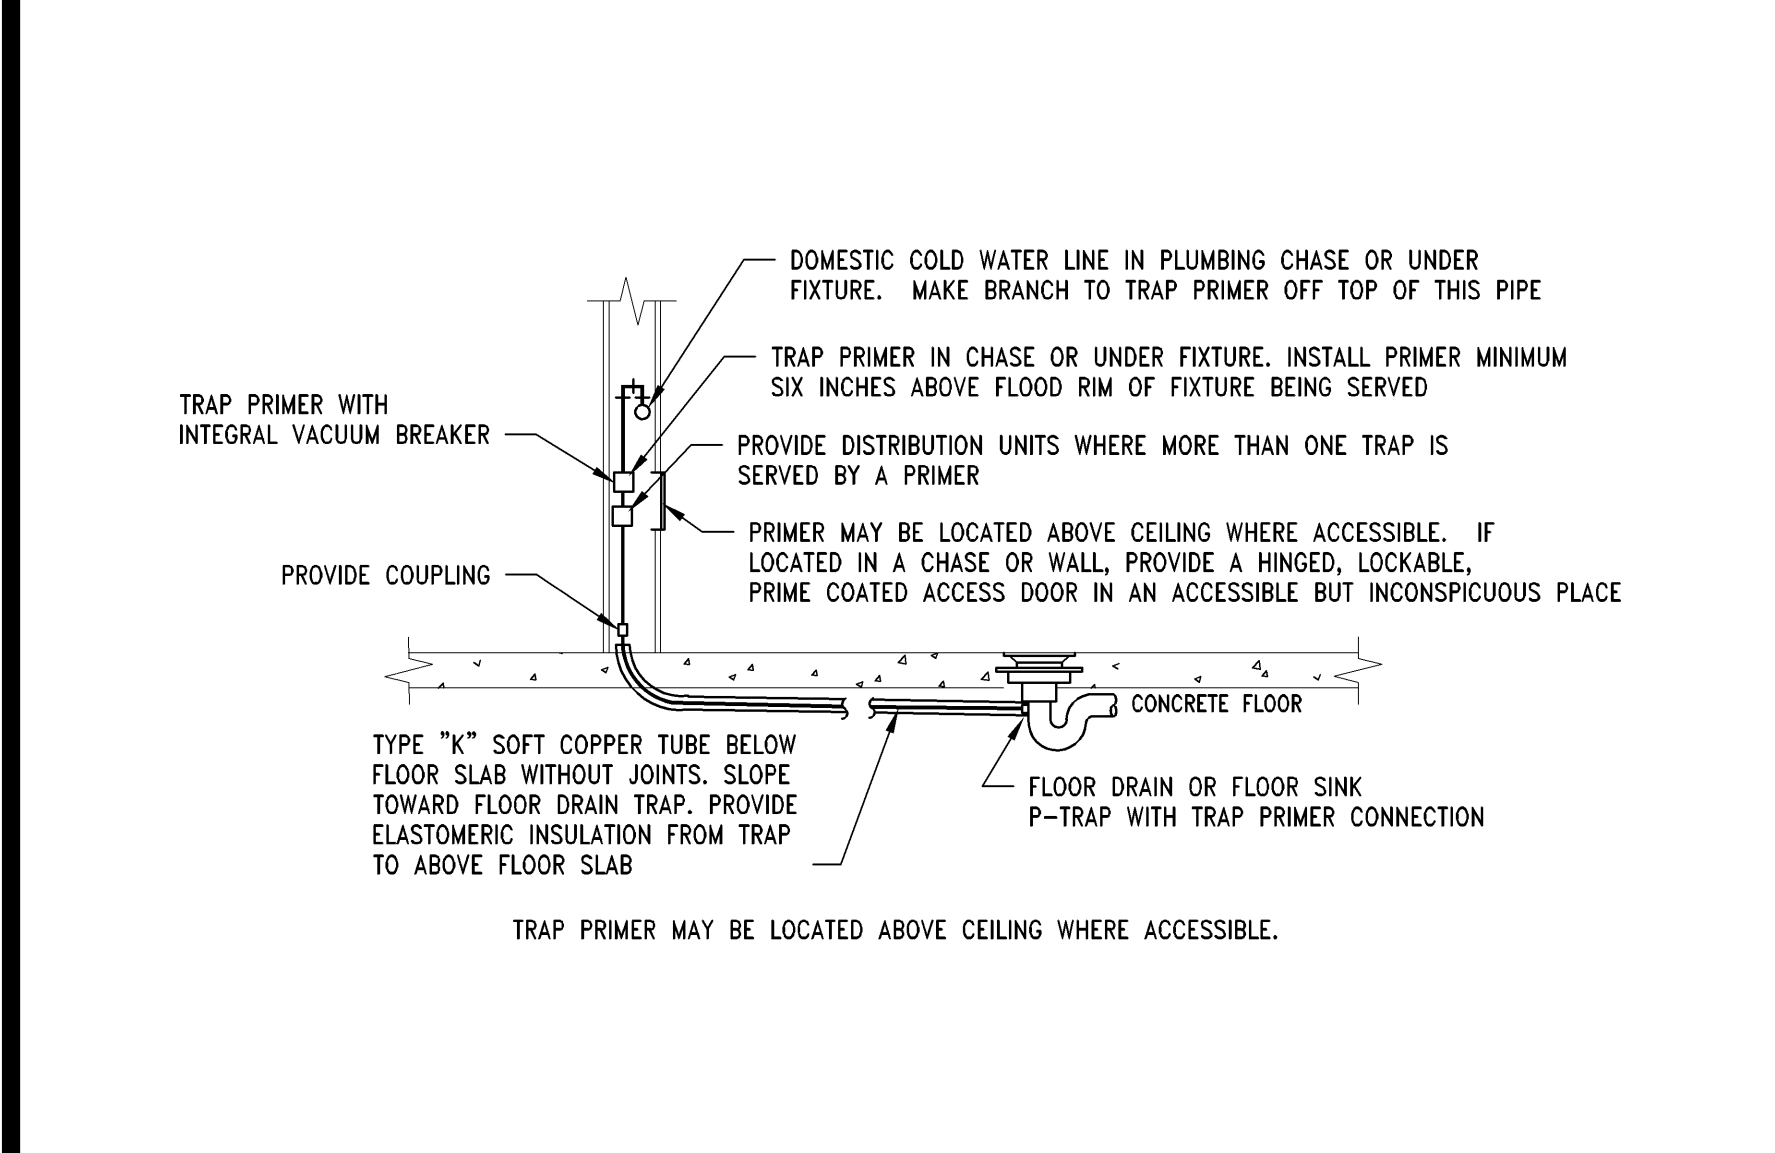


TRAP PRIMER 1" = 1'-0" F 00D-P0301-F01-TRAP 09/03/2015

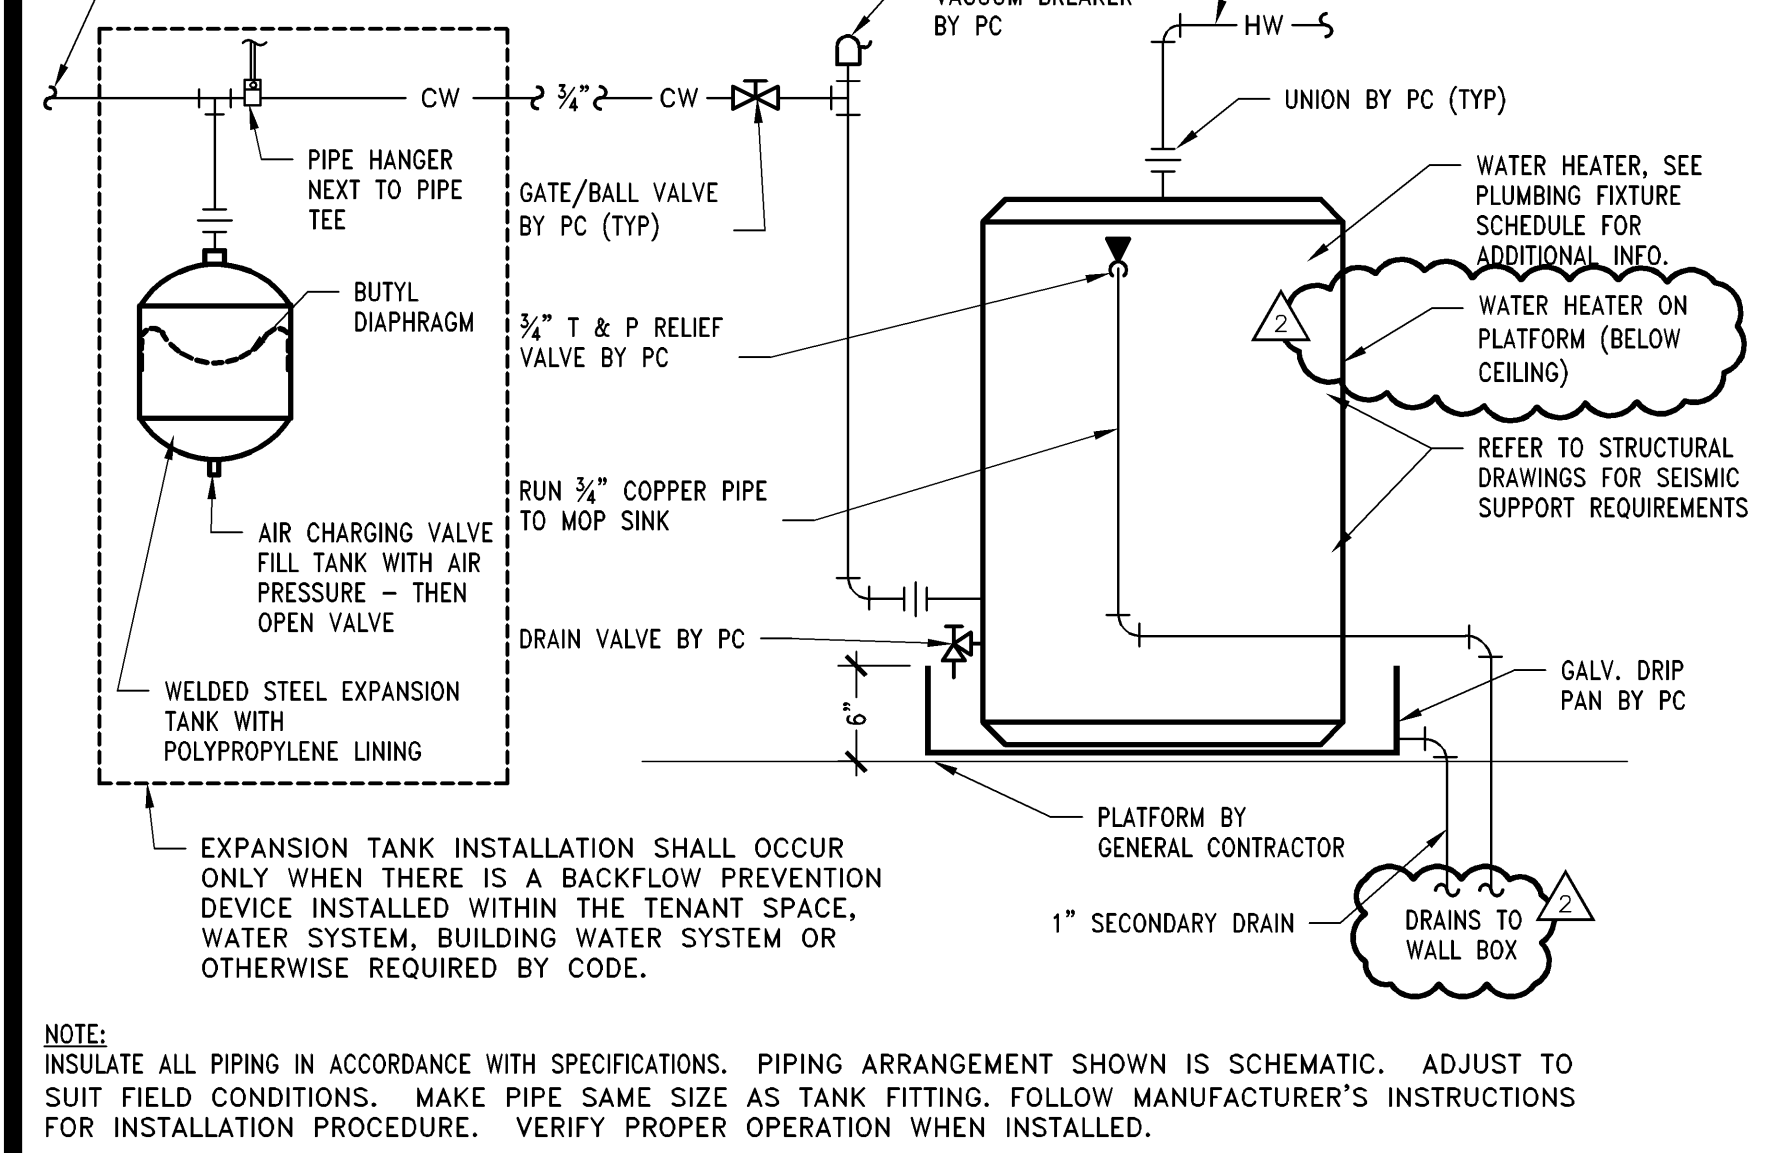


WATER HEATER DETAIL 1" = 1'-0" B 00D-P0301-B00-WTHR 09/03/2015

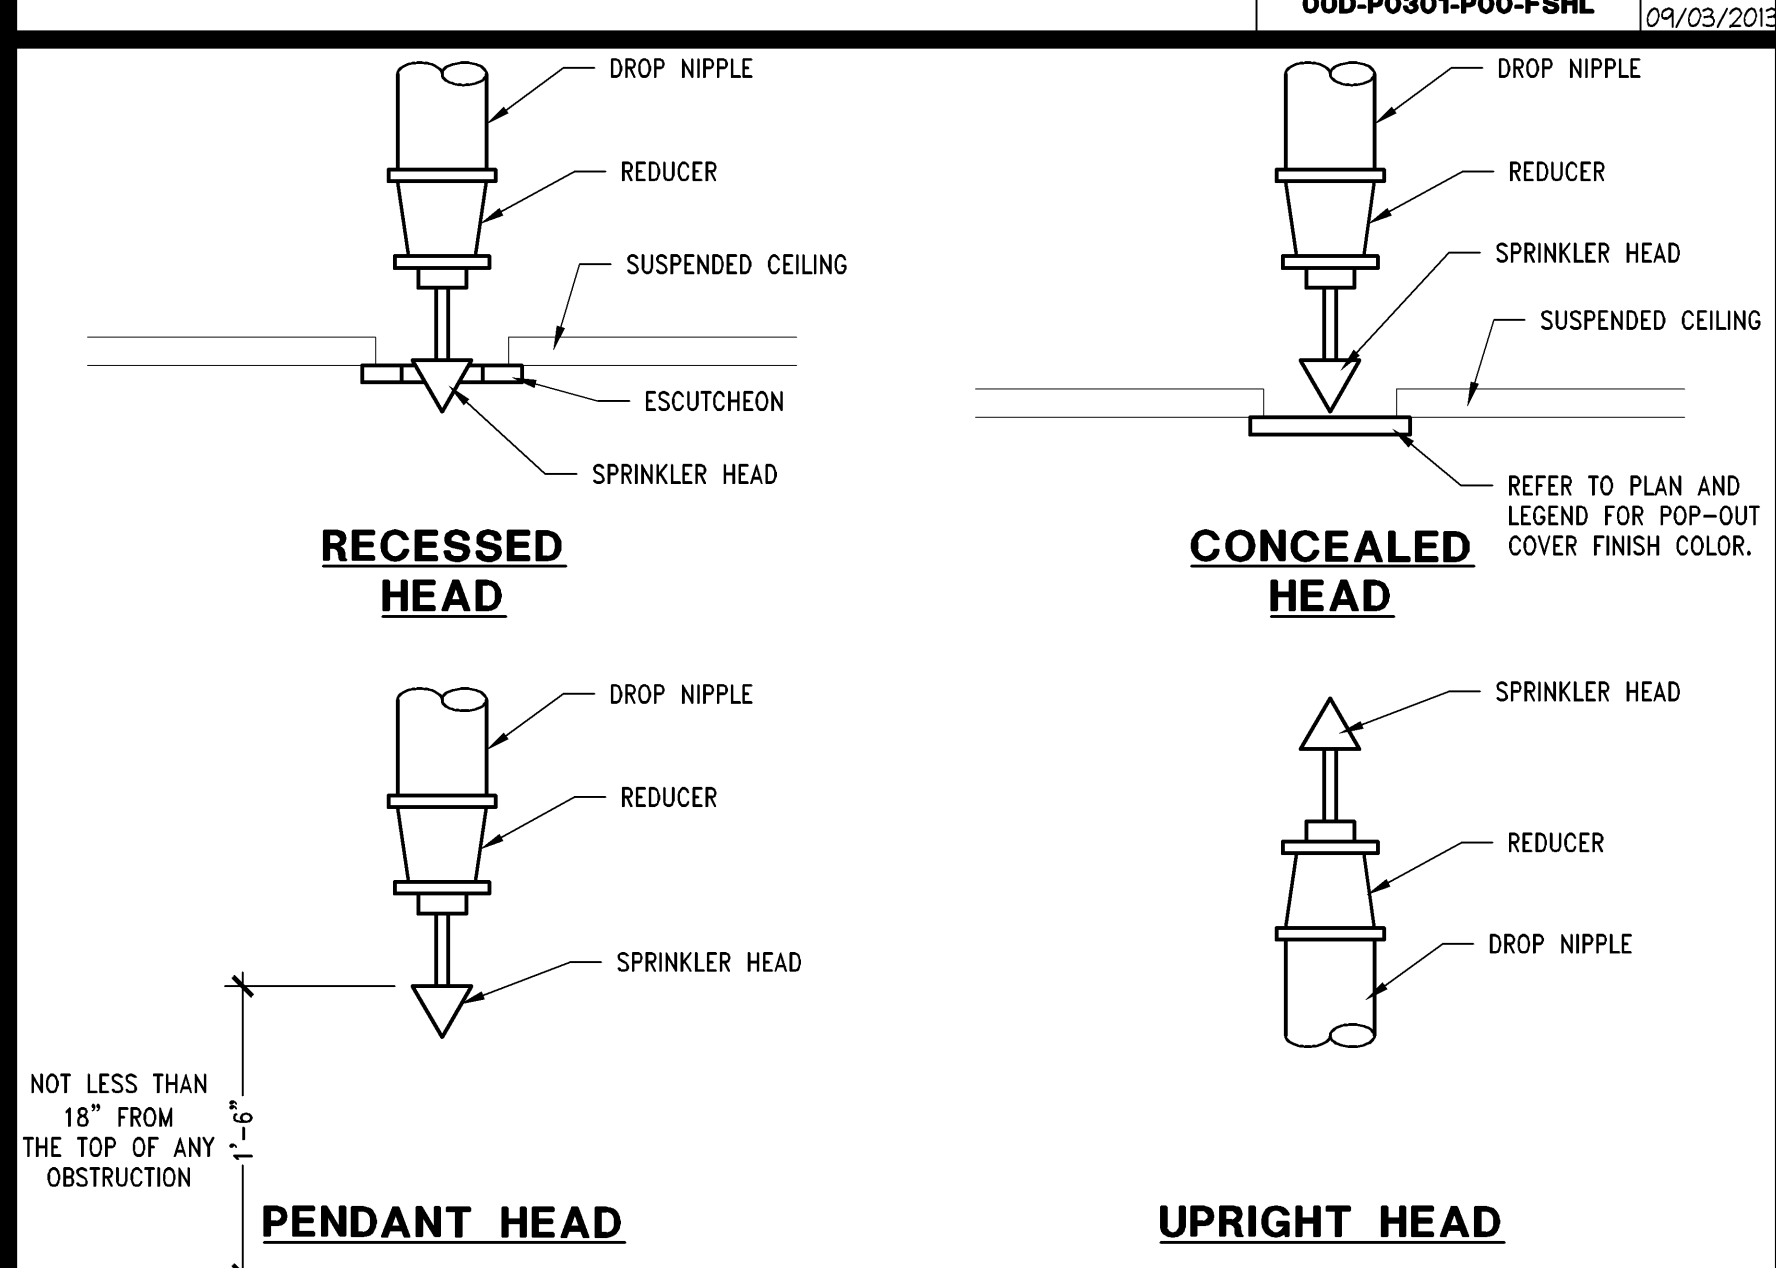


FIRE SPRINKLER HEAD DETAILS NTS 00D-P0301-N00-FSHD 02/14/2016

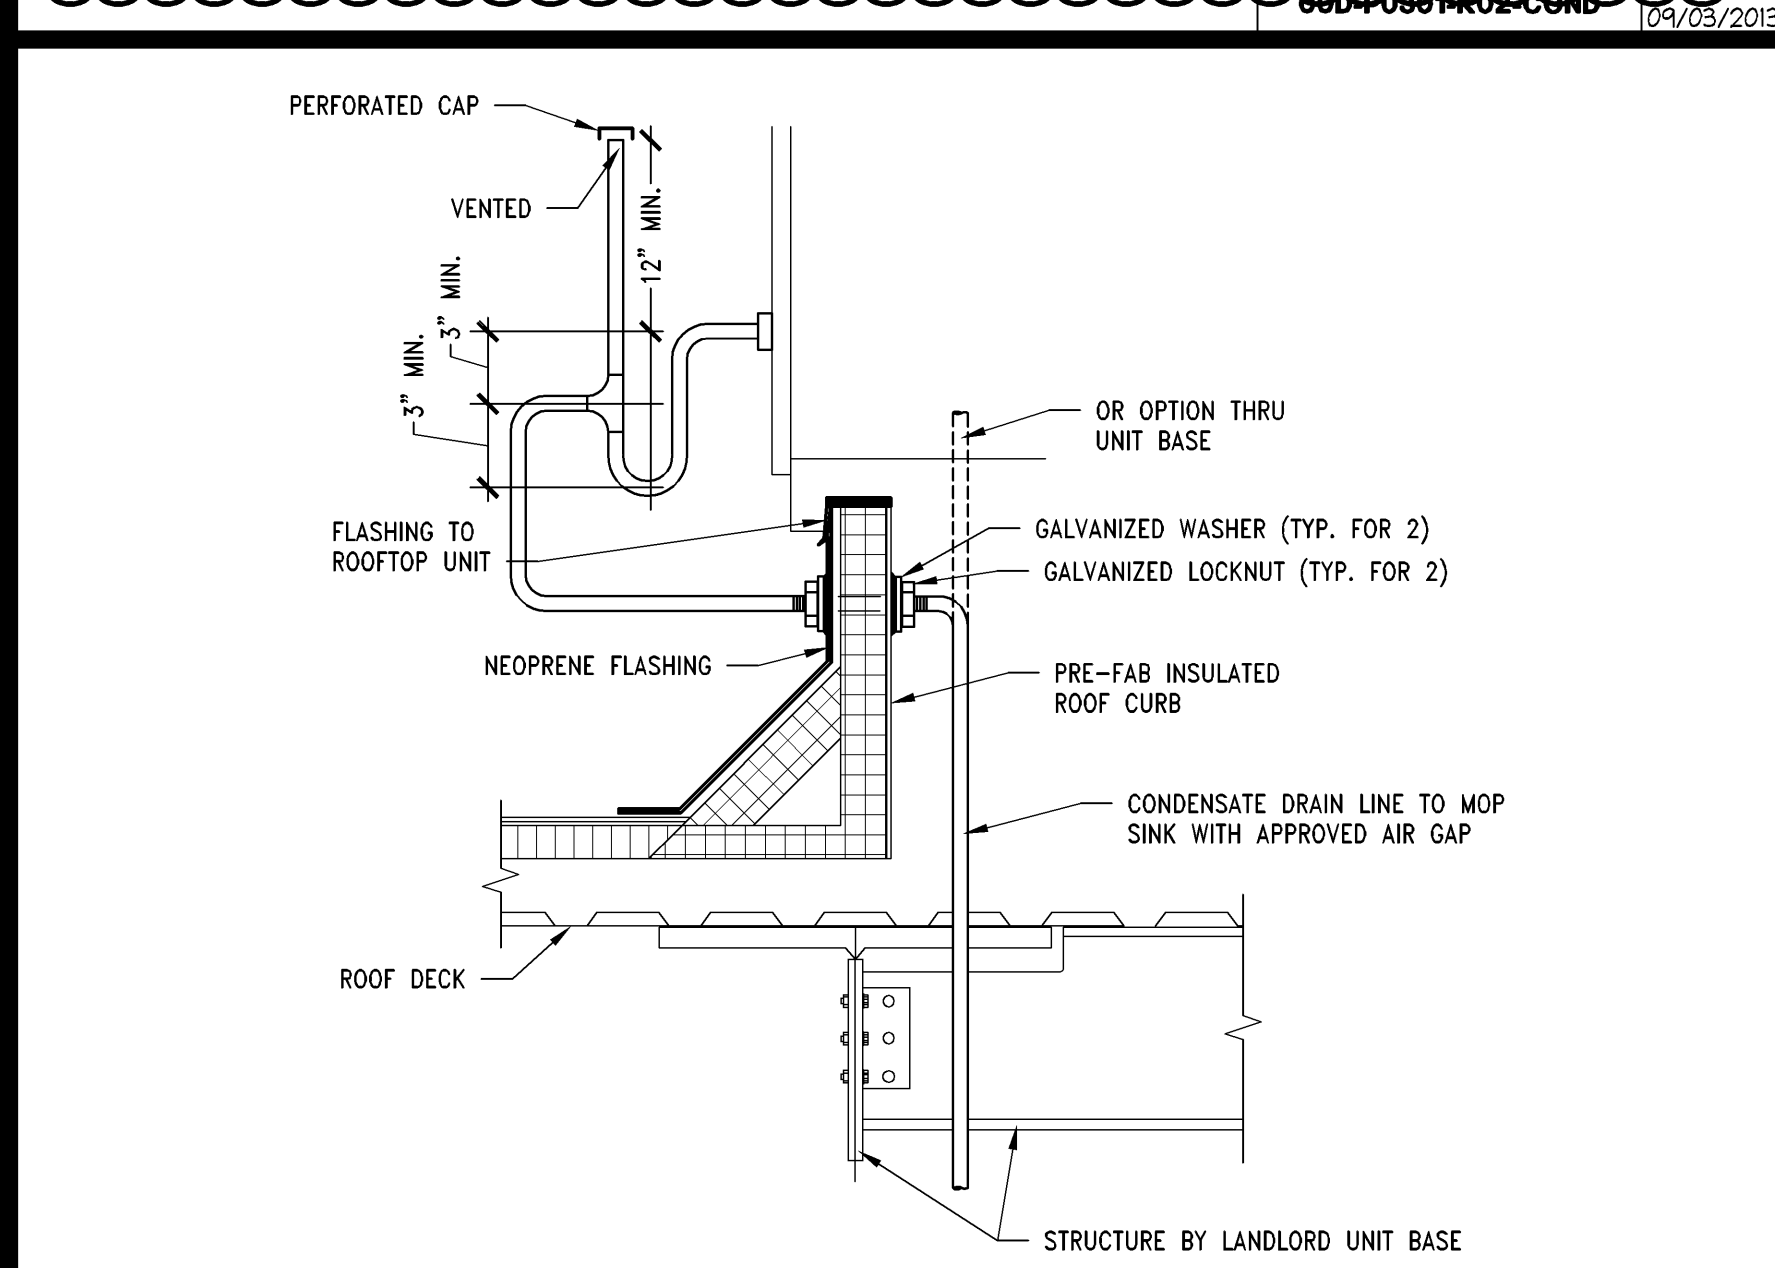

CONDENSATE DRAIN LINE 1" = 1'-0" J 00D-P0301-F00-COBD 09/03/2015

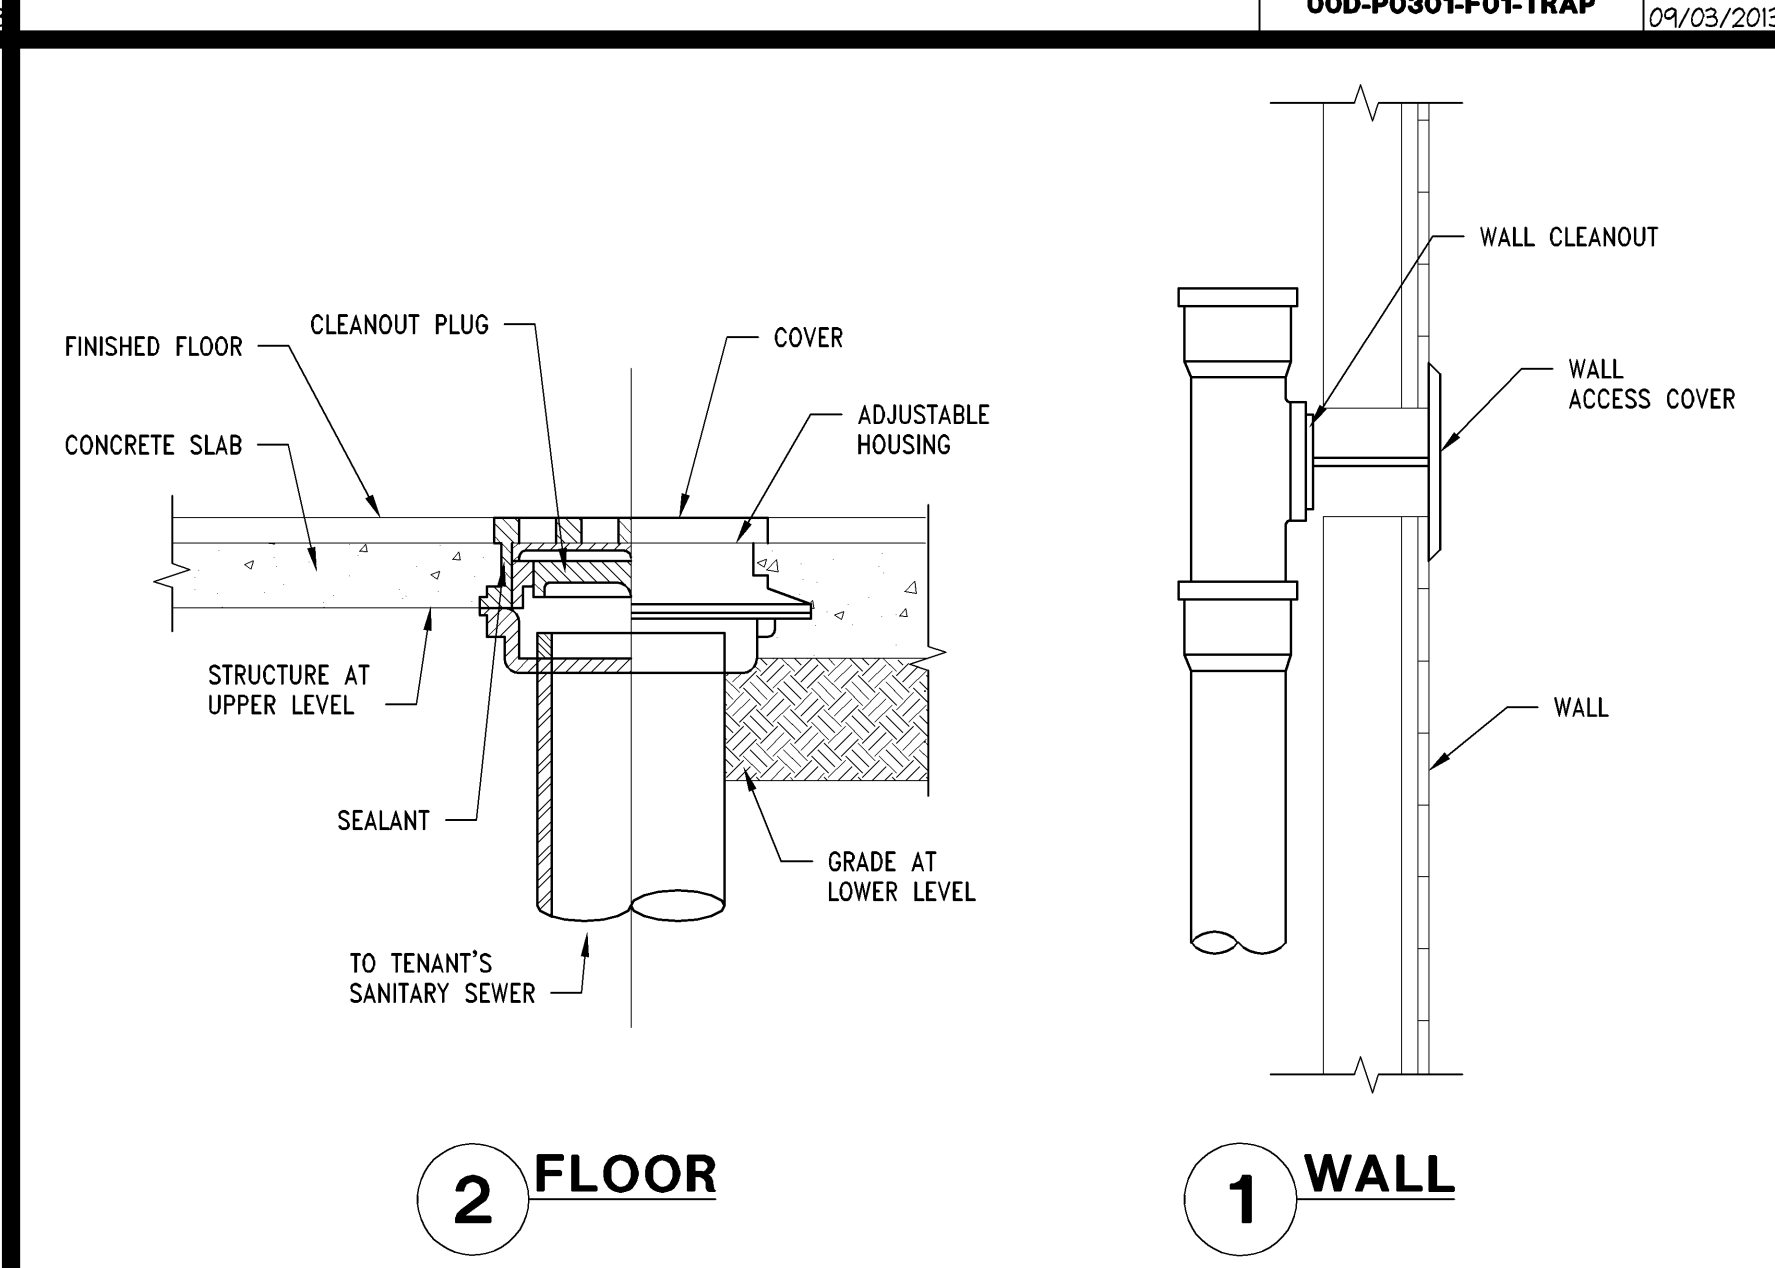

CLEANOUT DETAILS NTS 00D-P0301-E00-FWCO 09/03/2015

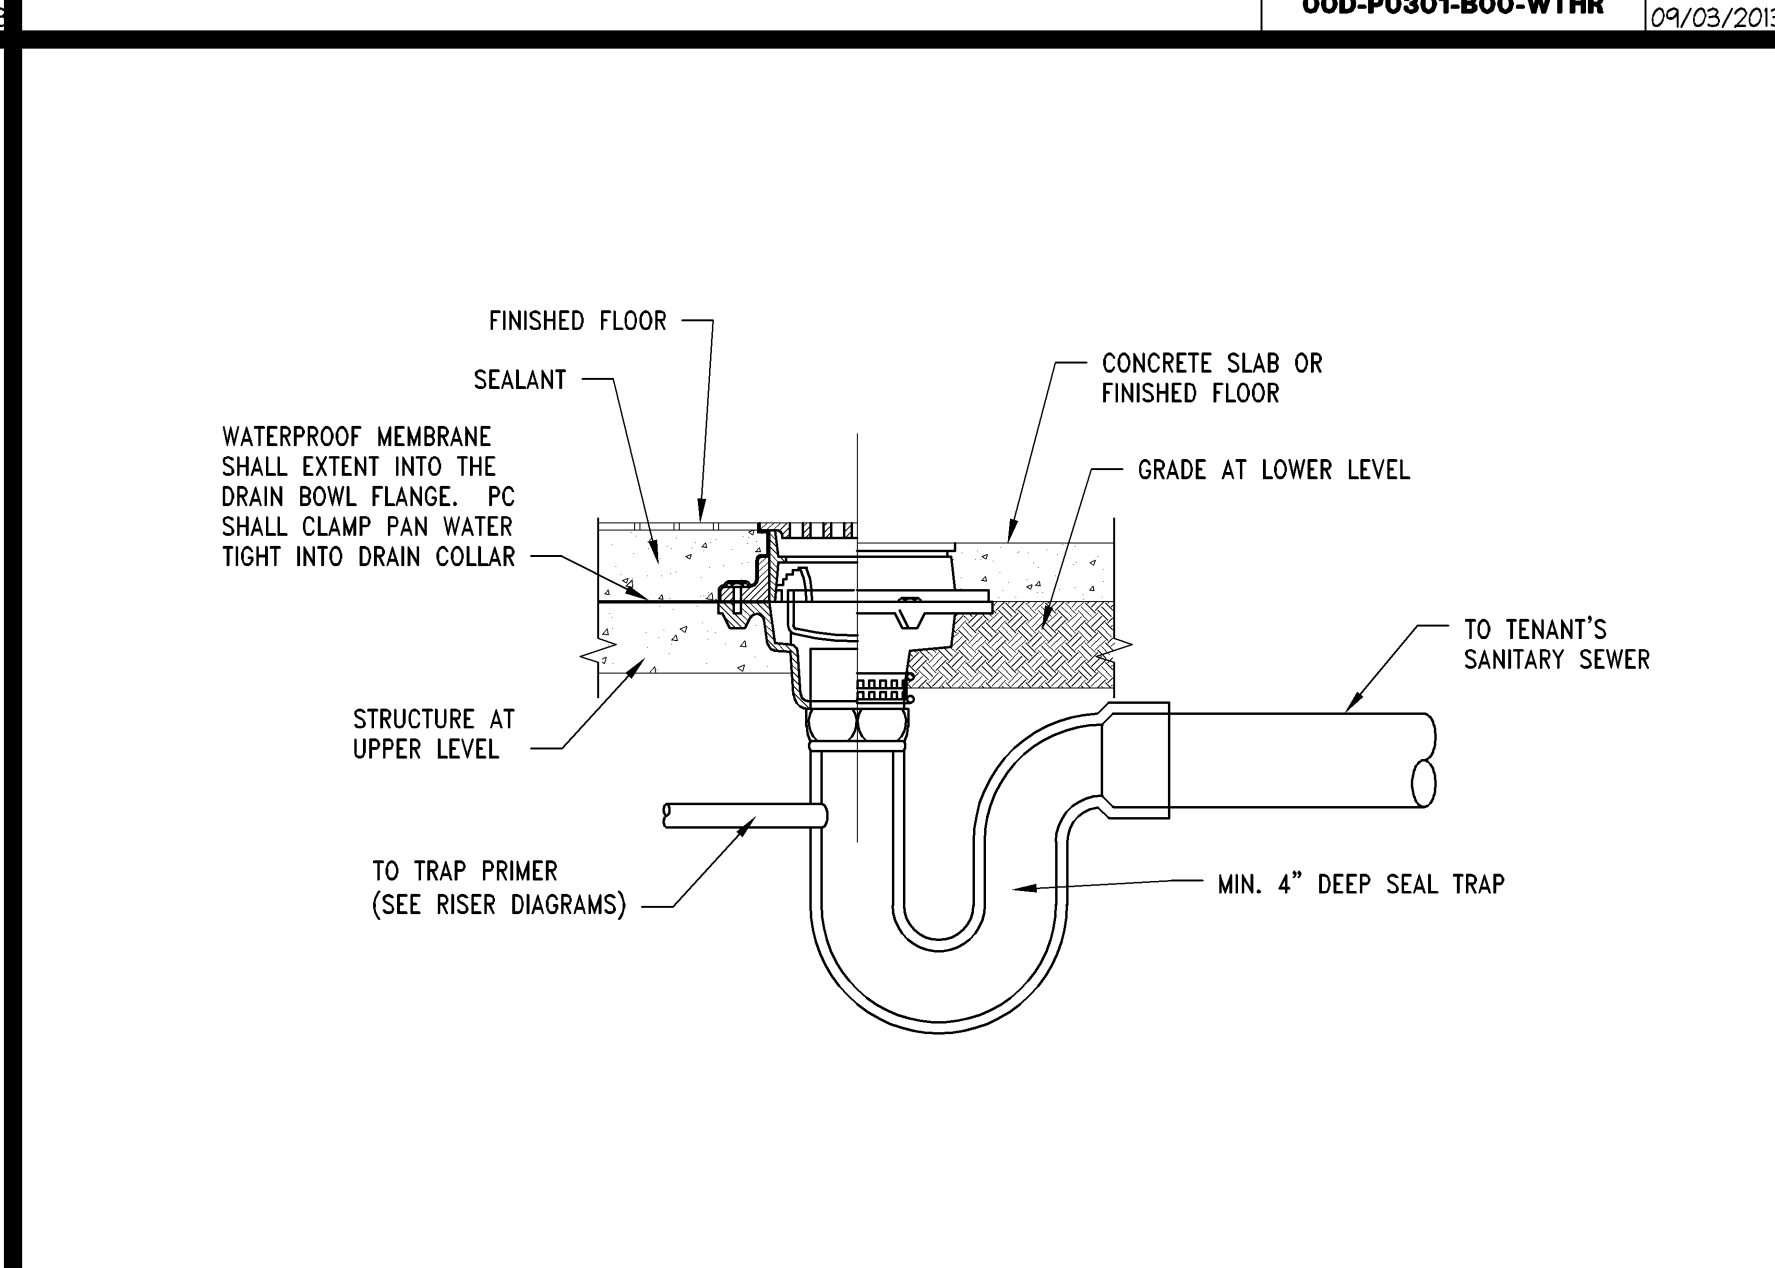

FLOOR DRAIN DETAIL NTS 00D-P0301-A00-FDRN 09/03/2015

LARSON BINKLEY
Larson Binkley, Inc.
310 W 20th Street, Suite 200
Kansas City, Missouri 64108
Texas Certificate of
Authorization Number P-1367
1 816-967-9601
F 816-967-9602
larsorbinkley.com

Limitedbrands
LIMITED STORE PLANNING, INC.
d/b/a STORE DESIGN & CONSTRUCTION
Three Limited Parkway • Columbus, Ohio 43230
Telephone: 614.415.7000 • Fax: 614.415.7349

024200396
BATH & BODY WORKS
MEMORIAL CITY MALL
303 MEMORIAL CITY WAY
SUITE 735
HOUSTON, TX 77024
SCOPE: RELO DWN / NEW PACKAGE: EASTON-C GENERATION: 60685 A/E PROJECT #: 14159 13643

PROJECT INFORMATION:
REVISIONS:
DESIGNED BY: JES
DRAWN BY: JES
CHECKED BY: NRP
DATE ISSUED: 04/11/2014
PLUMBING AND FIRE PROTECTION DETAILS
DRAWING NUMBER: P03.01