




GAS PIPING SUPPORT DETAIL 1" = 1'-0" 00D-P0301-800-GPSD 09/03/2016

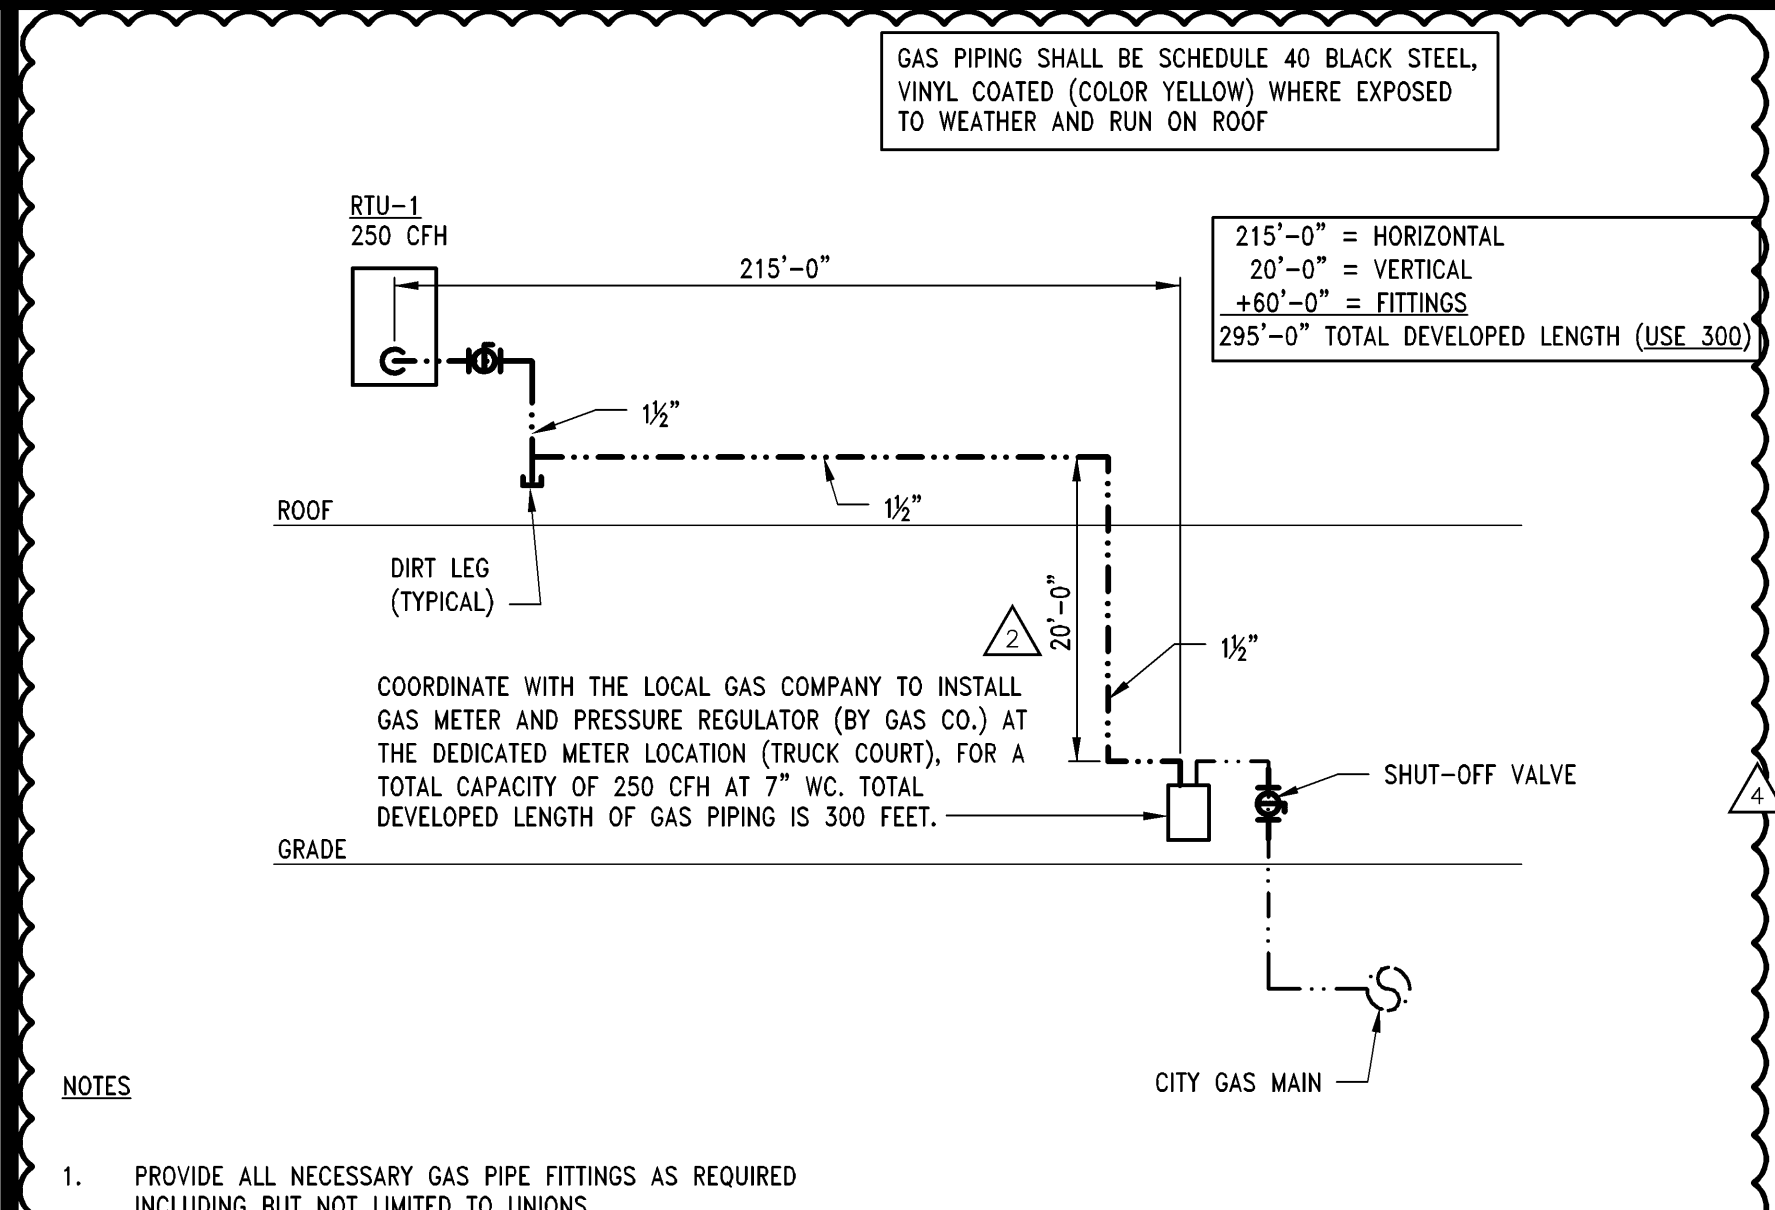


GAS PIPING DIAGRAM NTS 00D-P0301-M09-GSPD 09/03/2016

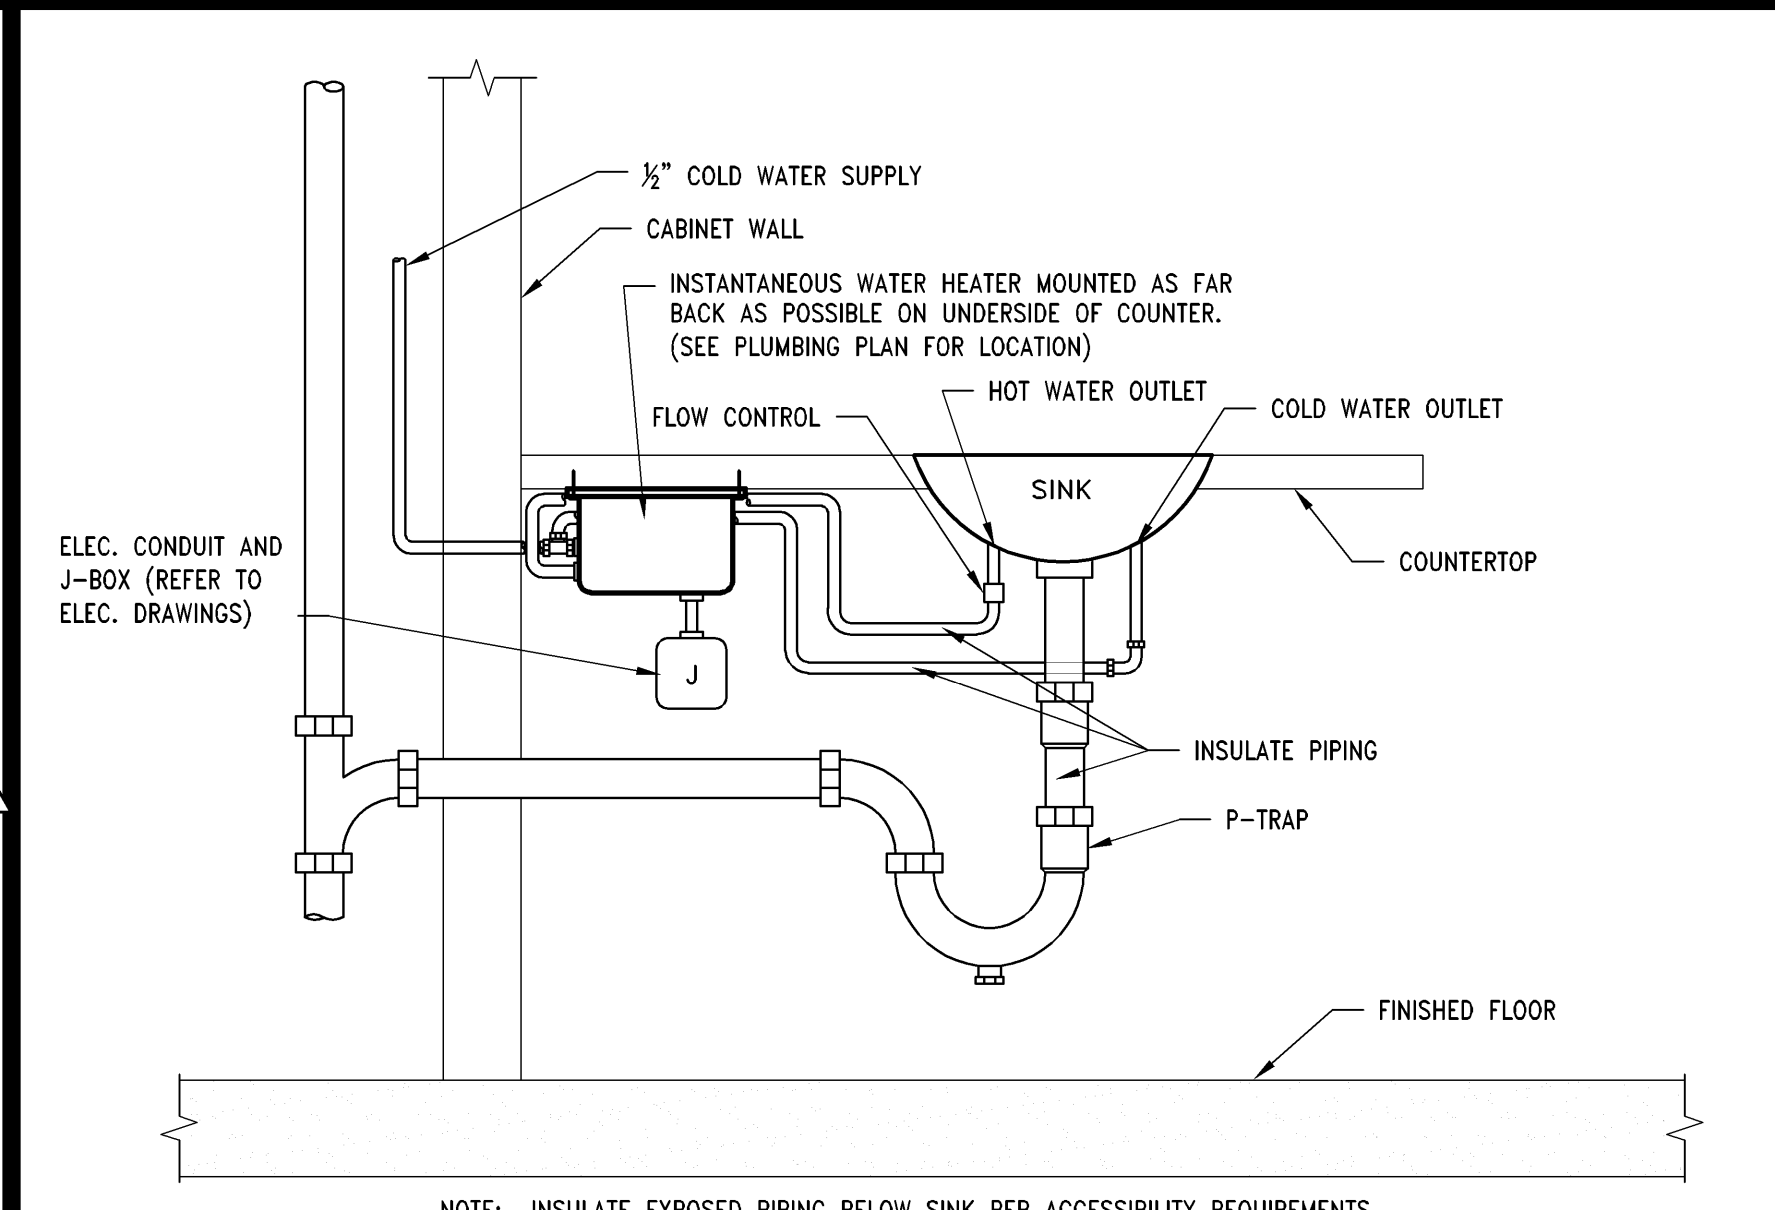

DEMONSTRATION SINK DETAIL NTS 42D-P0301-H02-DEMO 09/03/2016

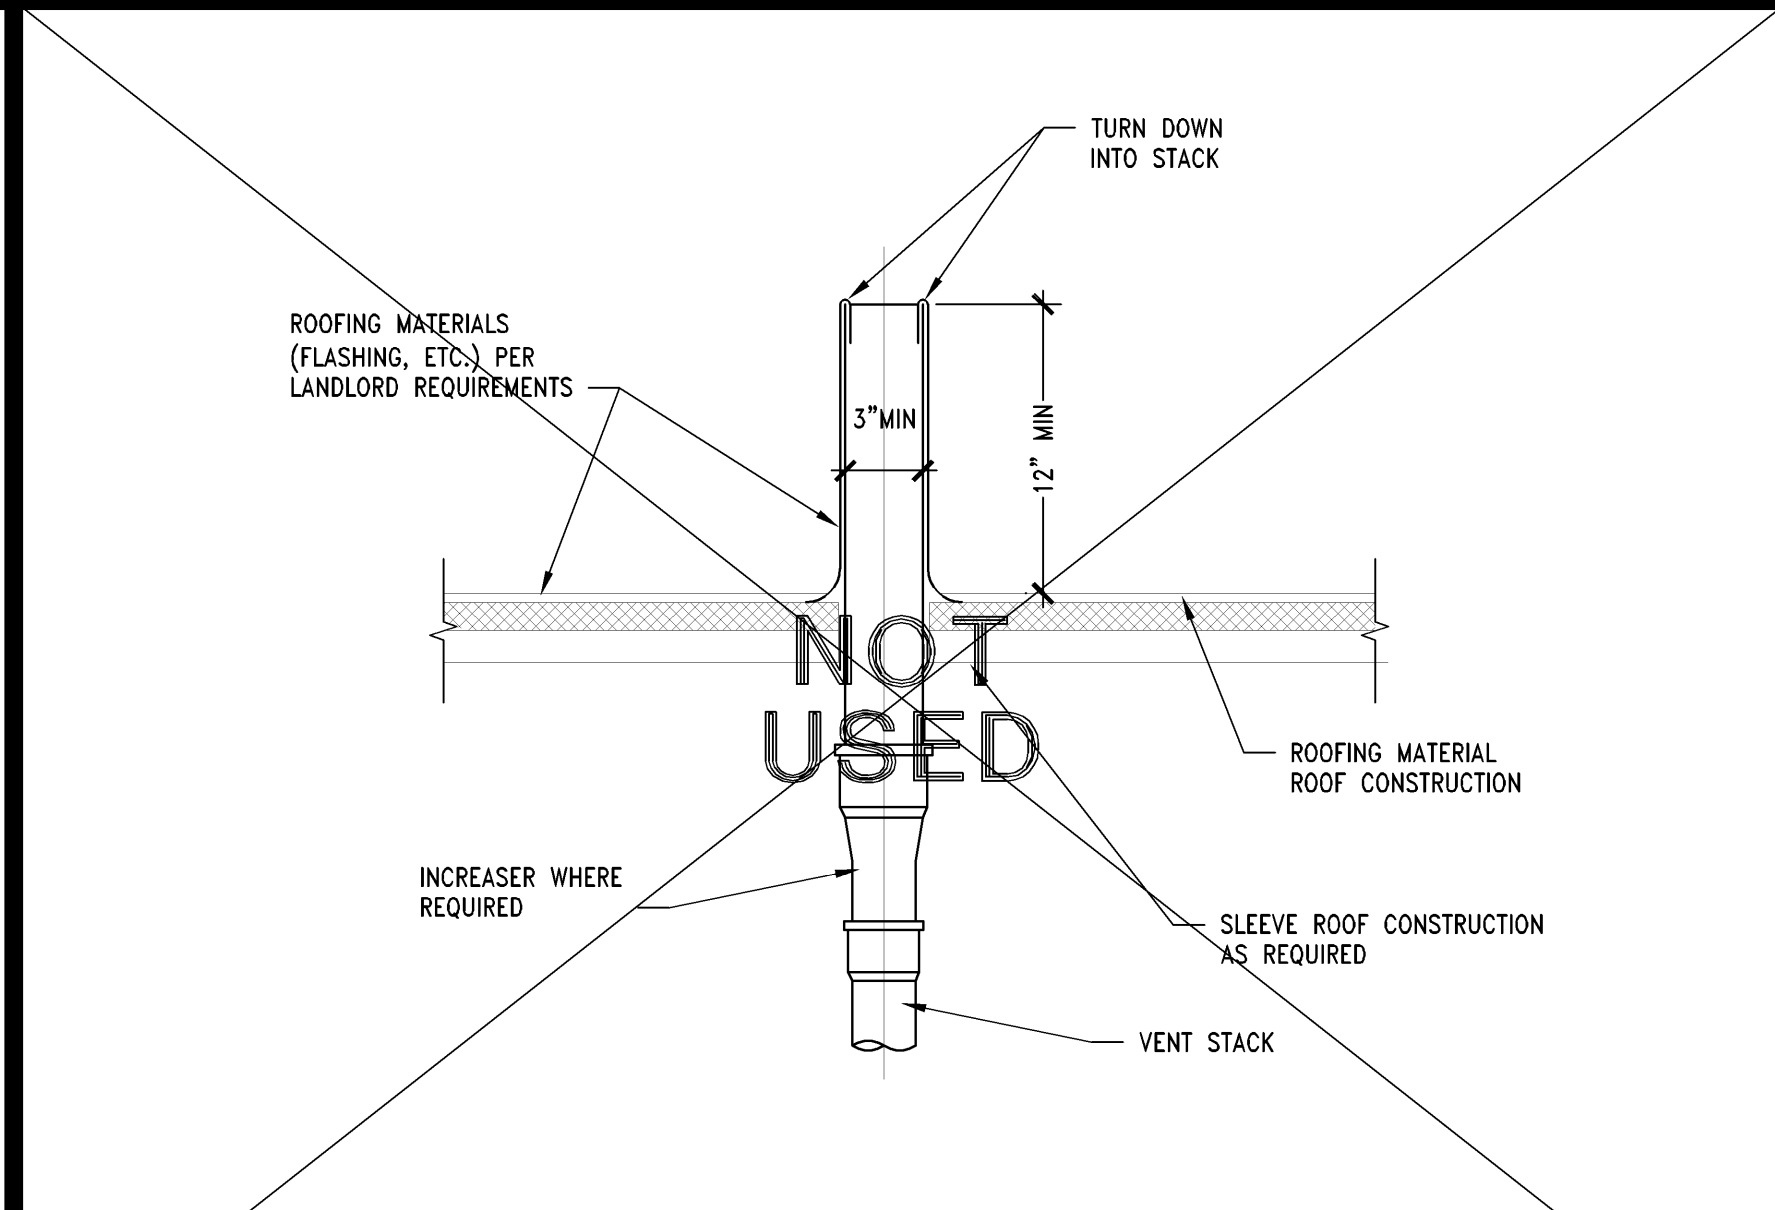


VENT THRU ROOF DETAIL 1-1/2"=1'-0" 00D-P0301-D00-VTR 09/03/2016

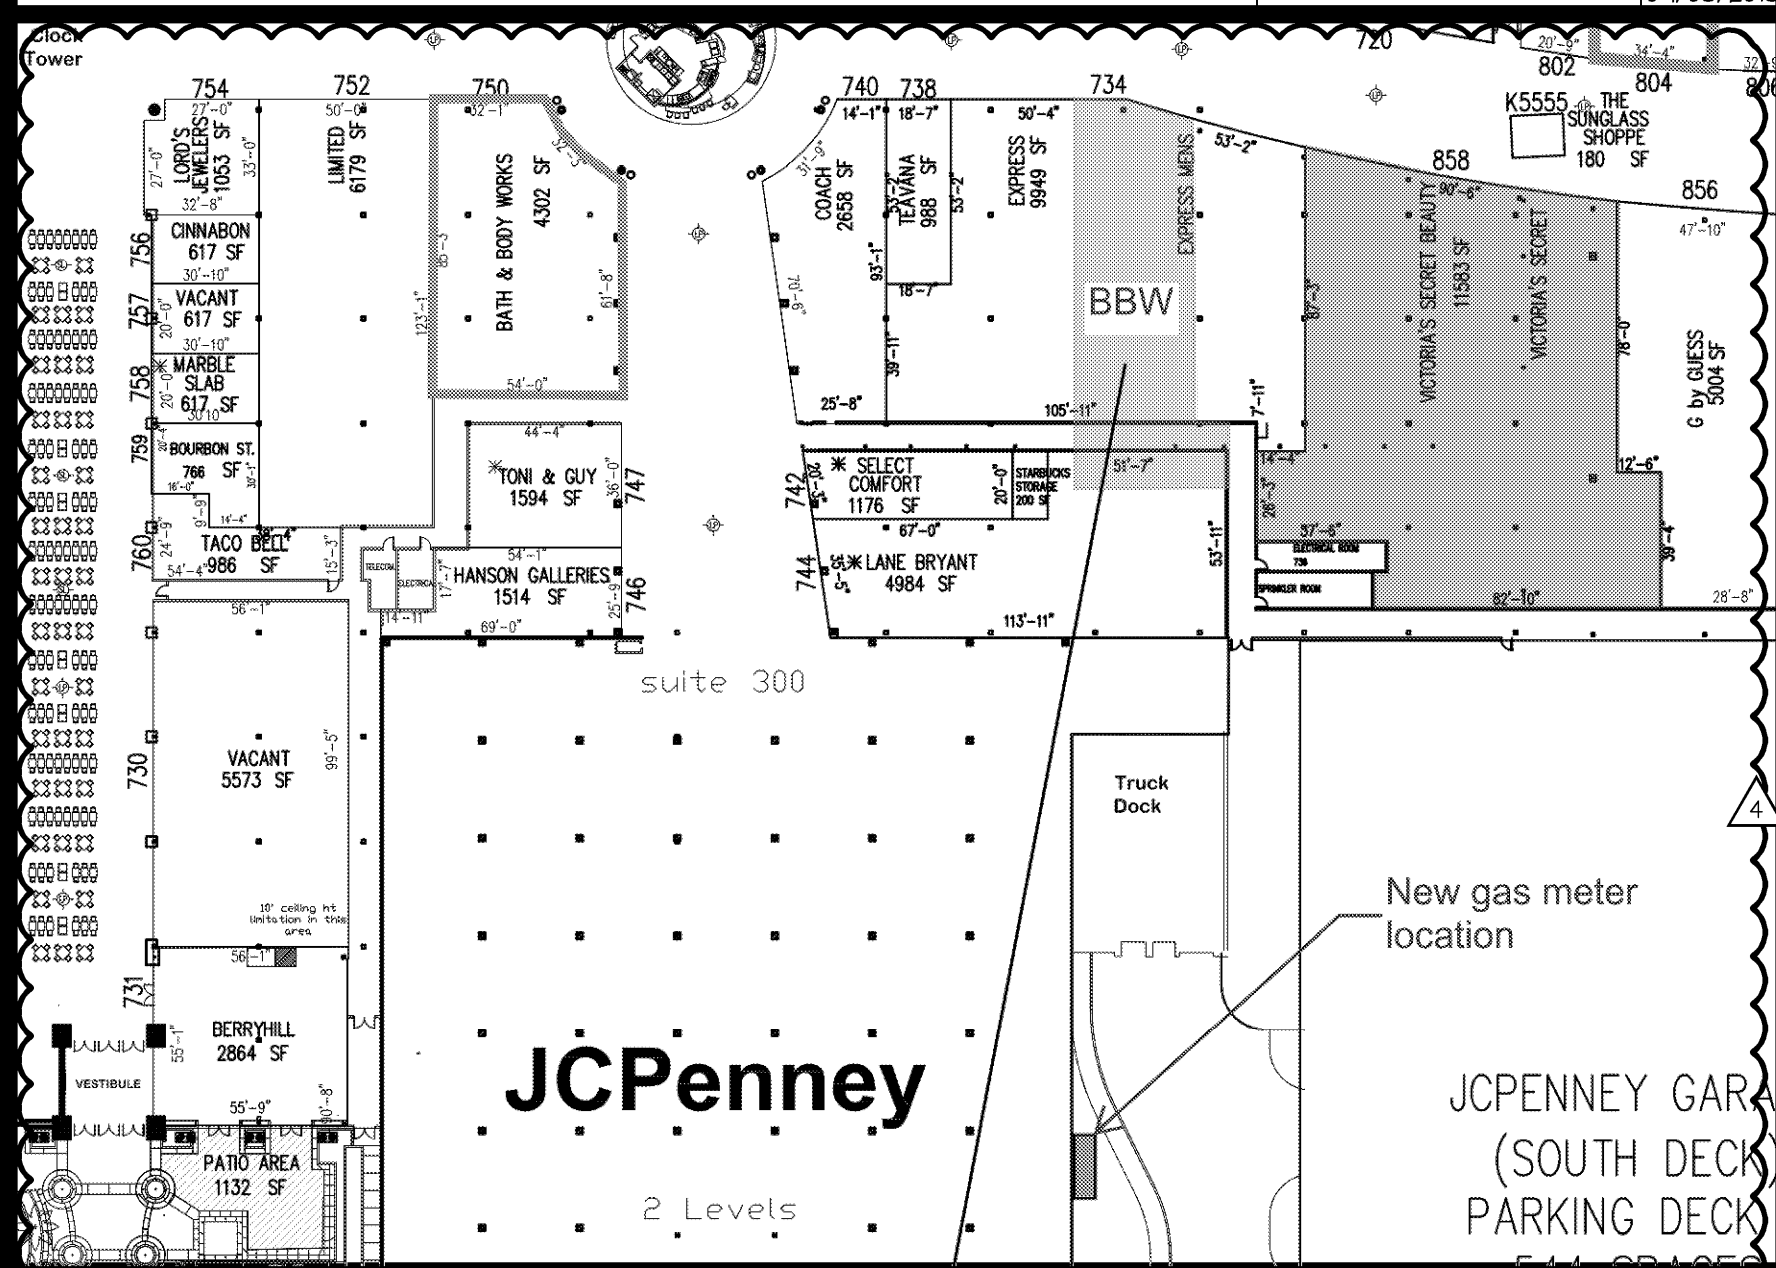


GAS METER LOCATION KEY PLAN NTS 00D-P0301-M09-GSPD 09/03/2016




PIPE FLOOR PENETRATION DETAIL NTS 00D-P0301-G00-PPEN 09/03/2016

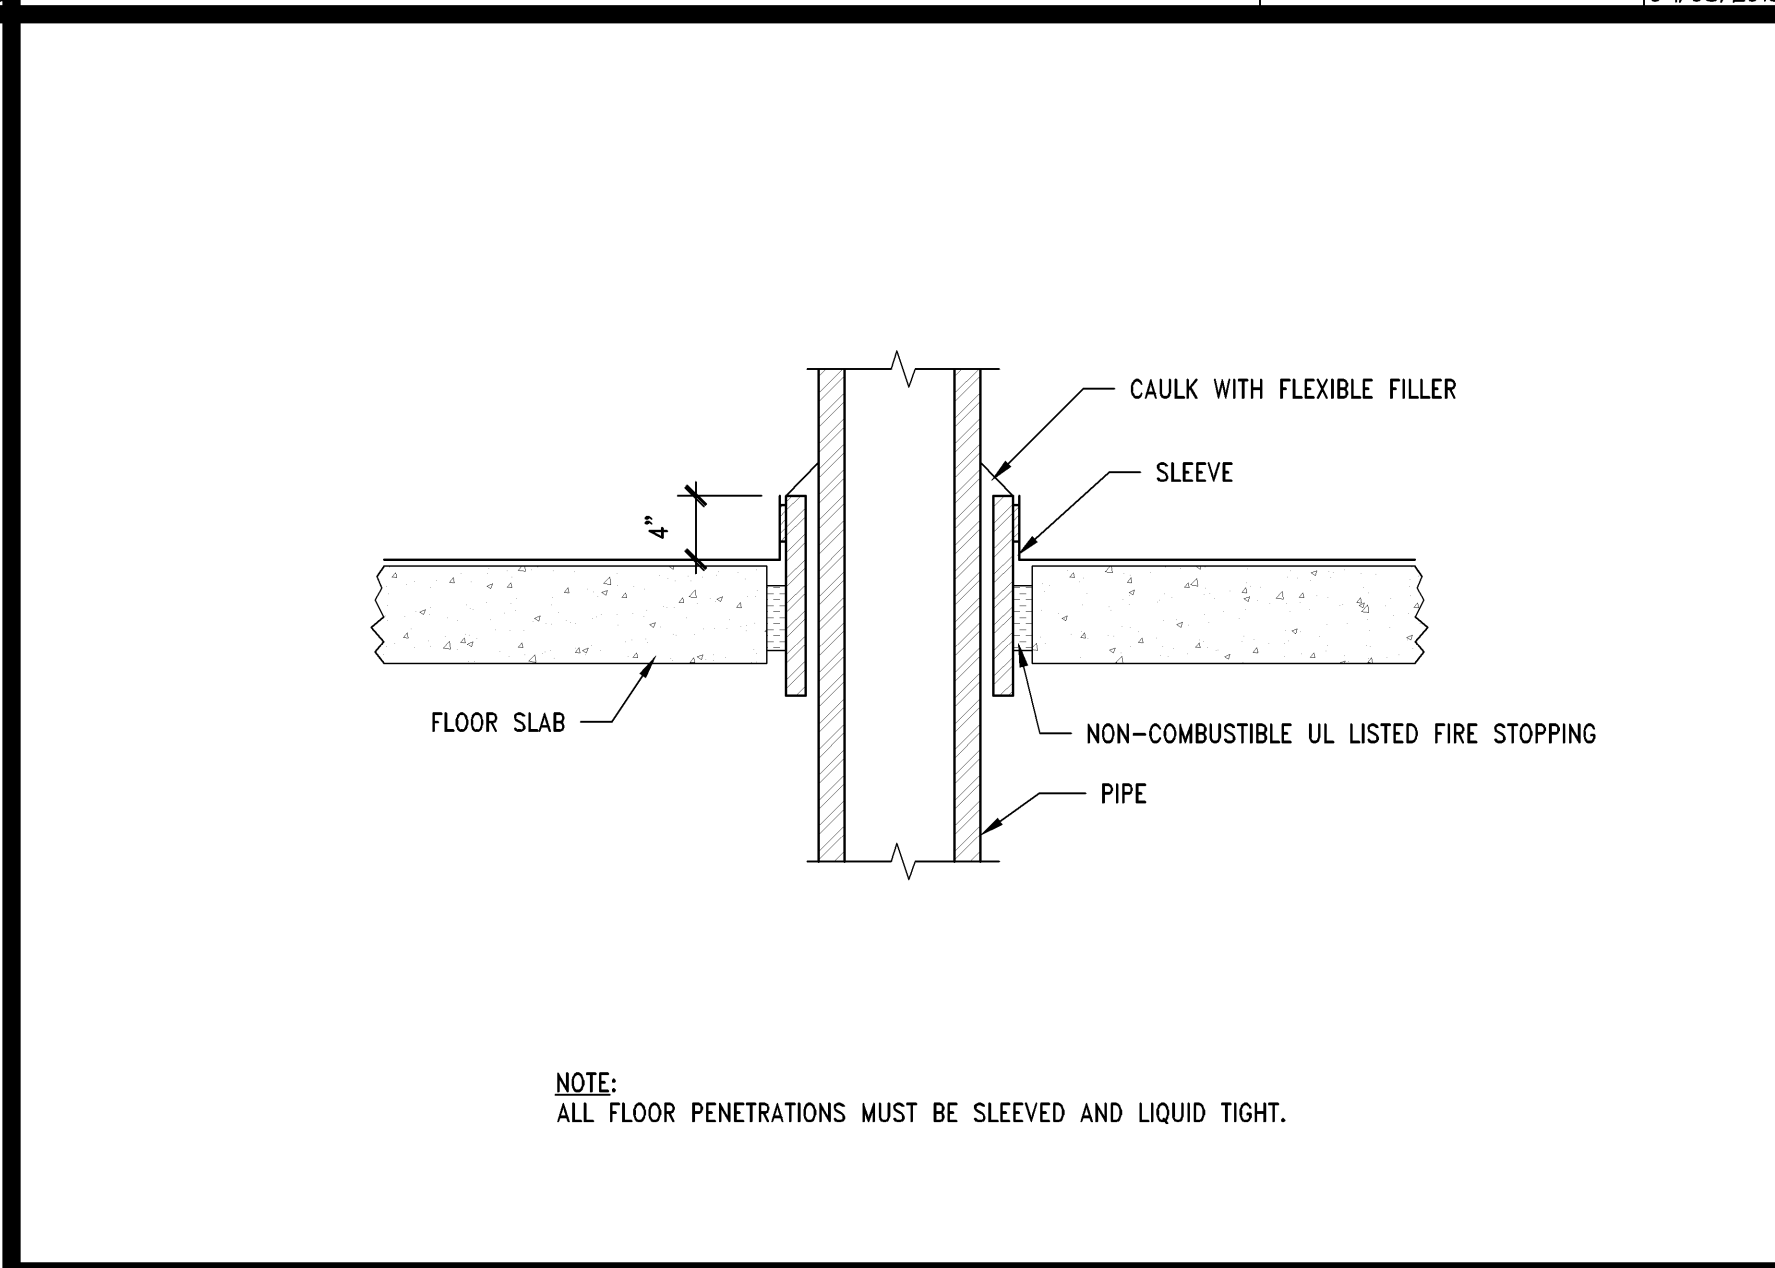


PIPE THRU FIRE WALL PENETRATION DETAIL NTS 00D-P0301-C00-PTFW 09/03/2016

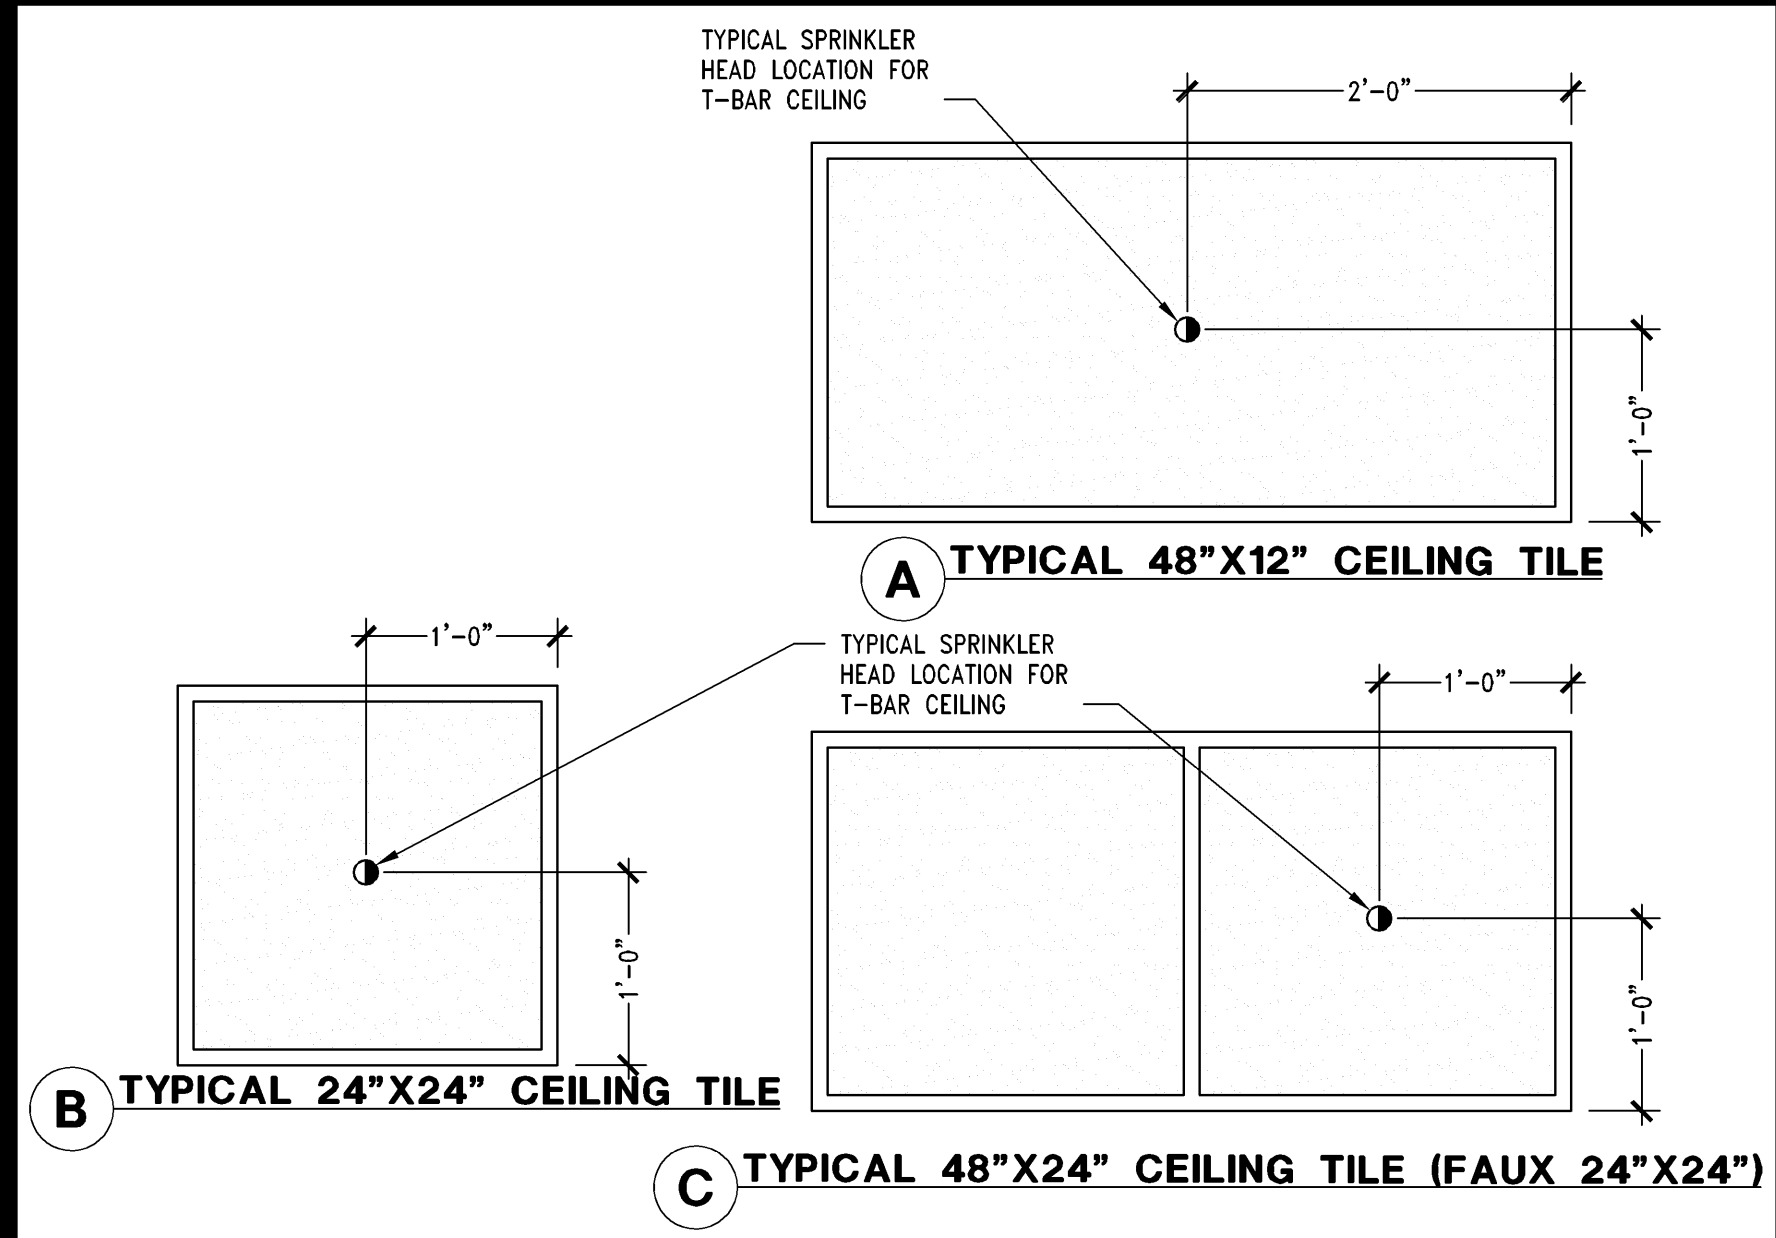


FIRE SPRINKLER HEAD LOCATION DETAILS 1" = 1'-0" 00D-P0301-P00-FSHL 09/03/2016

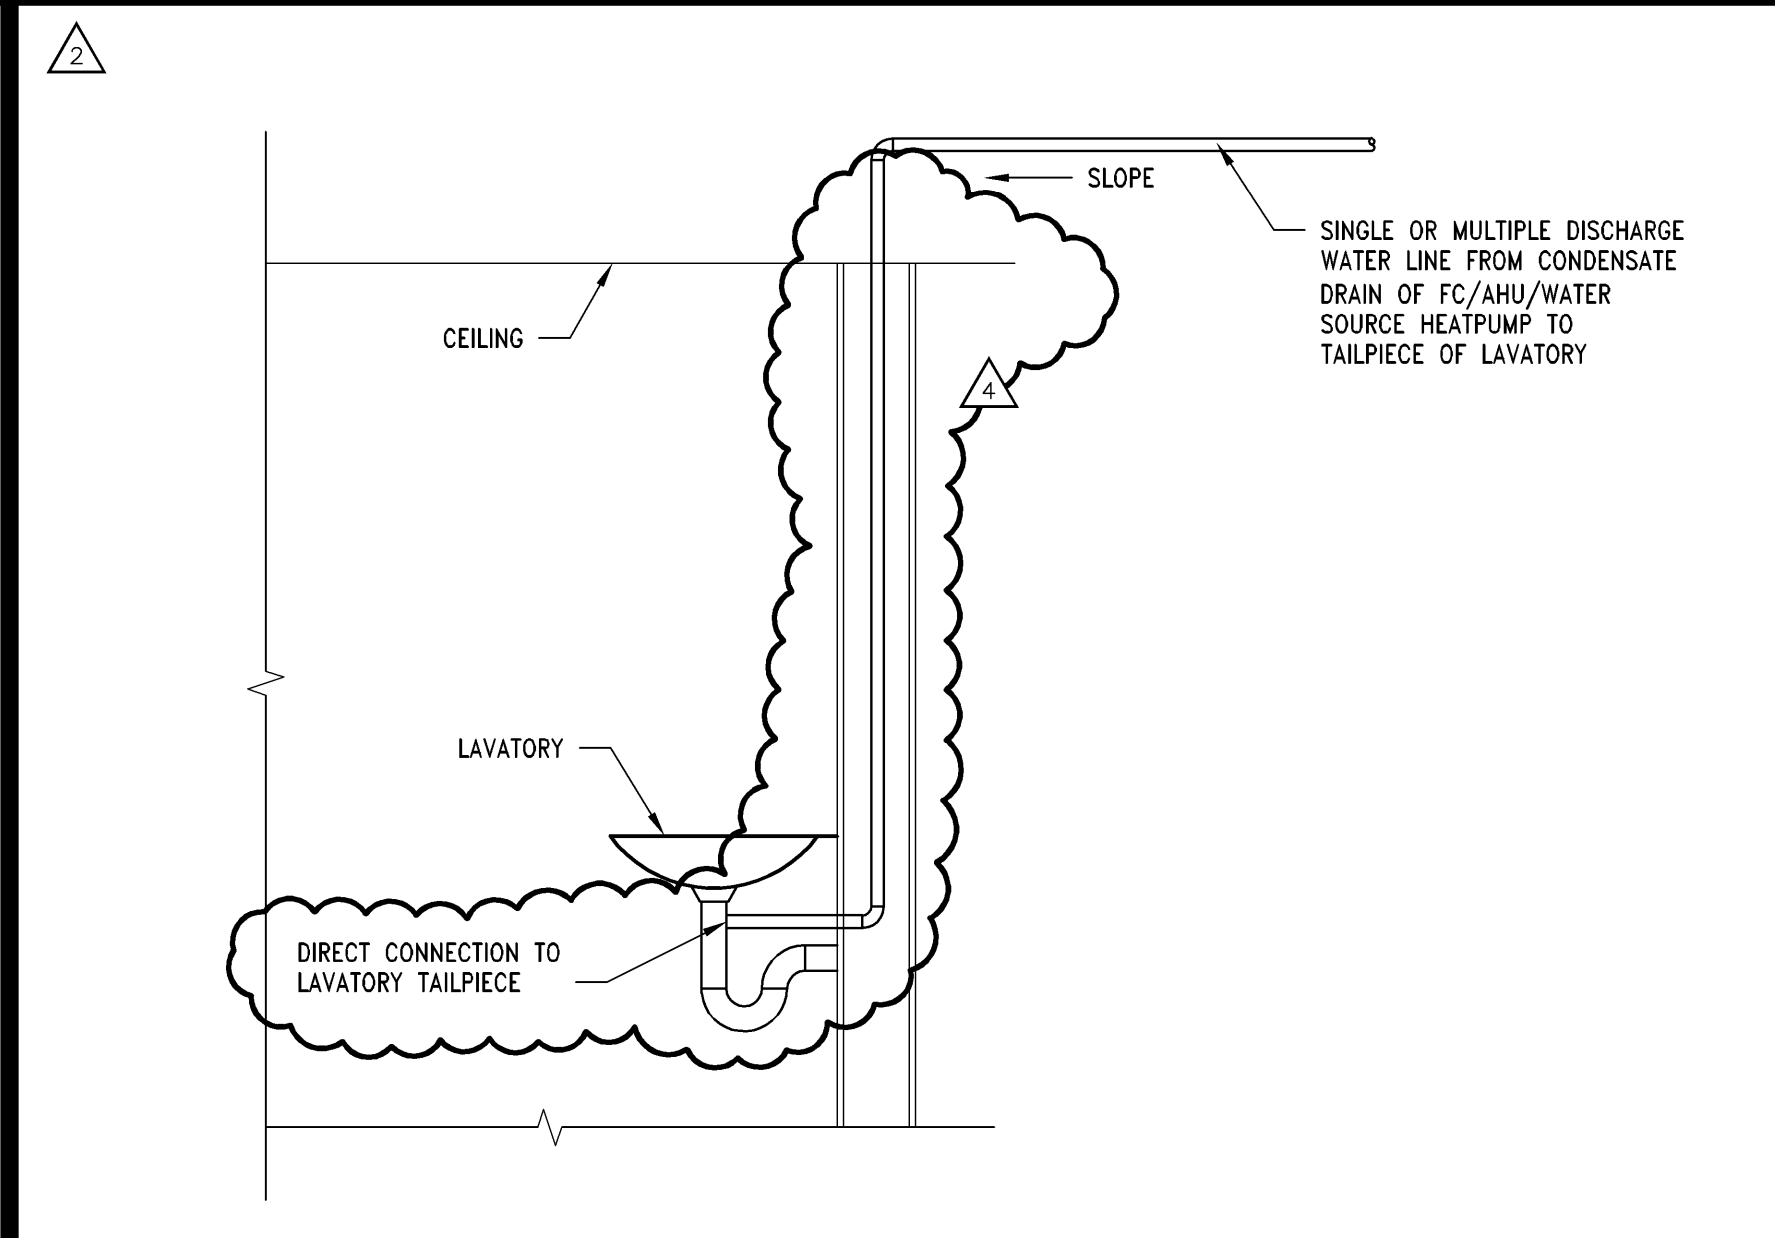


CONDENSATE DRAIN DETAIL NTS 00D-P0301-K02-COND 09/03/2016

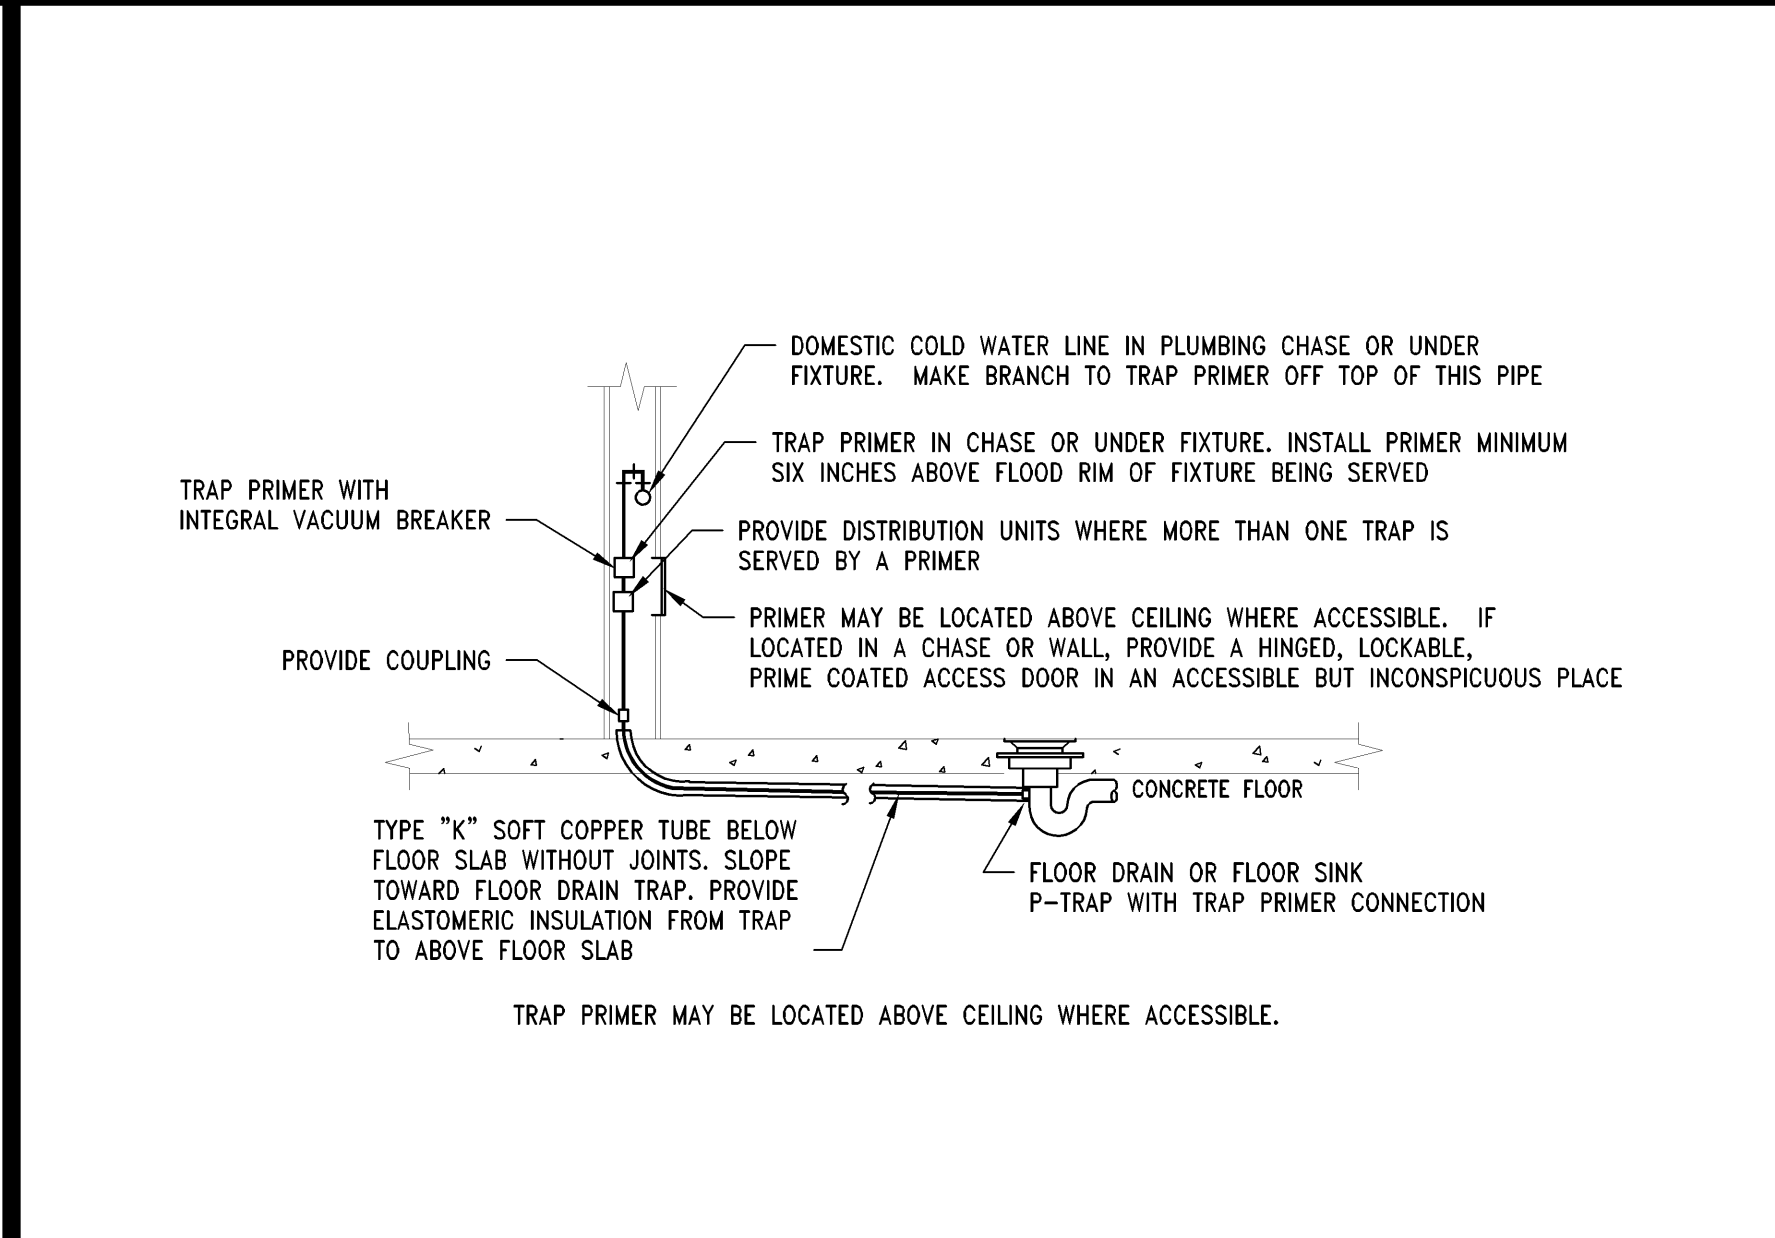


TRAP PRIMER 1" = 1'-0" 00D-P0301-F01-TRAP 09/03/2016

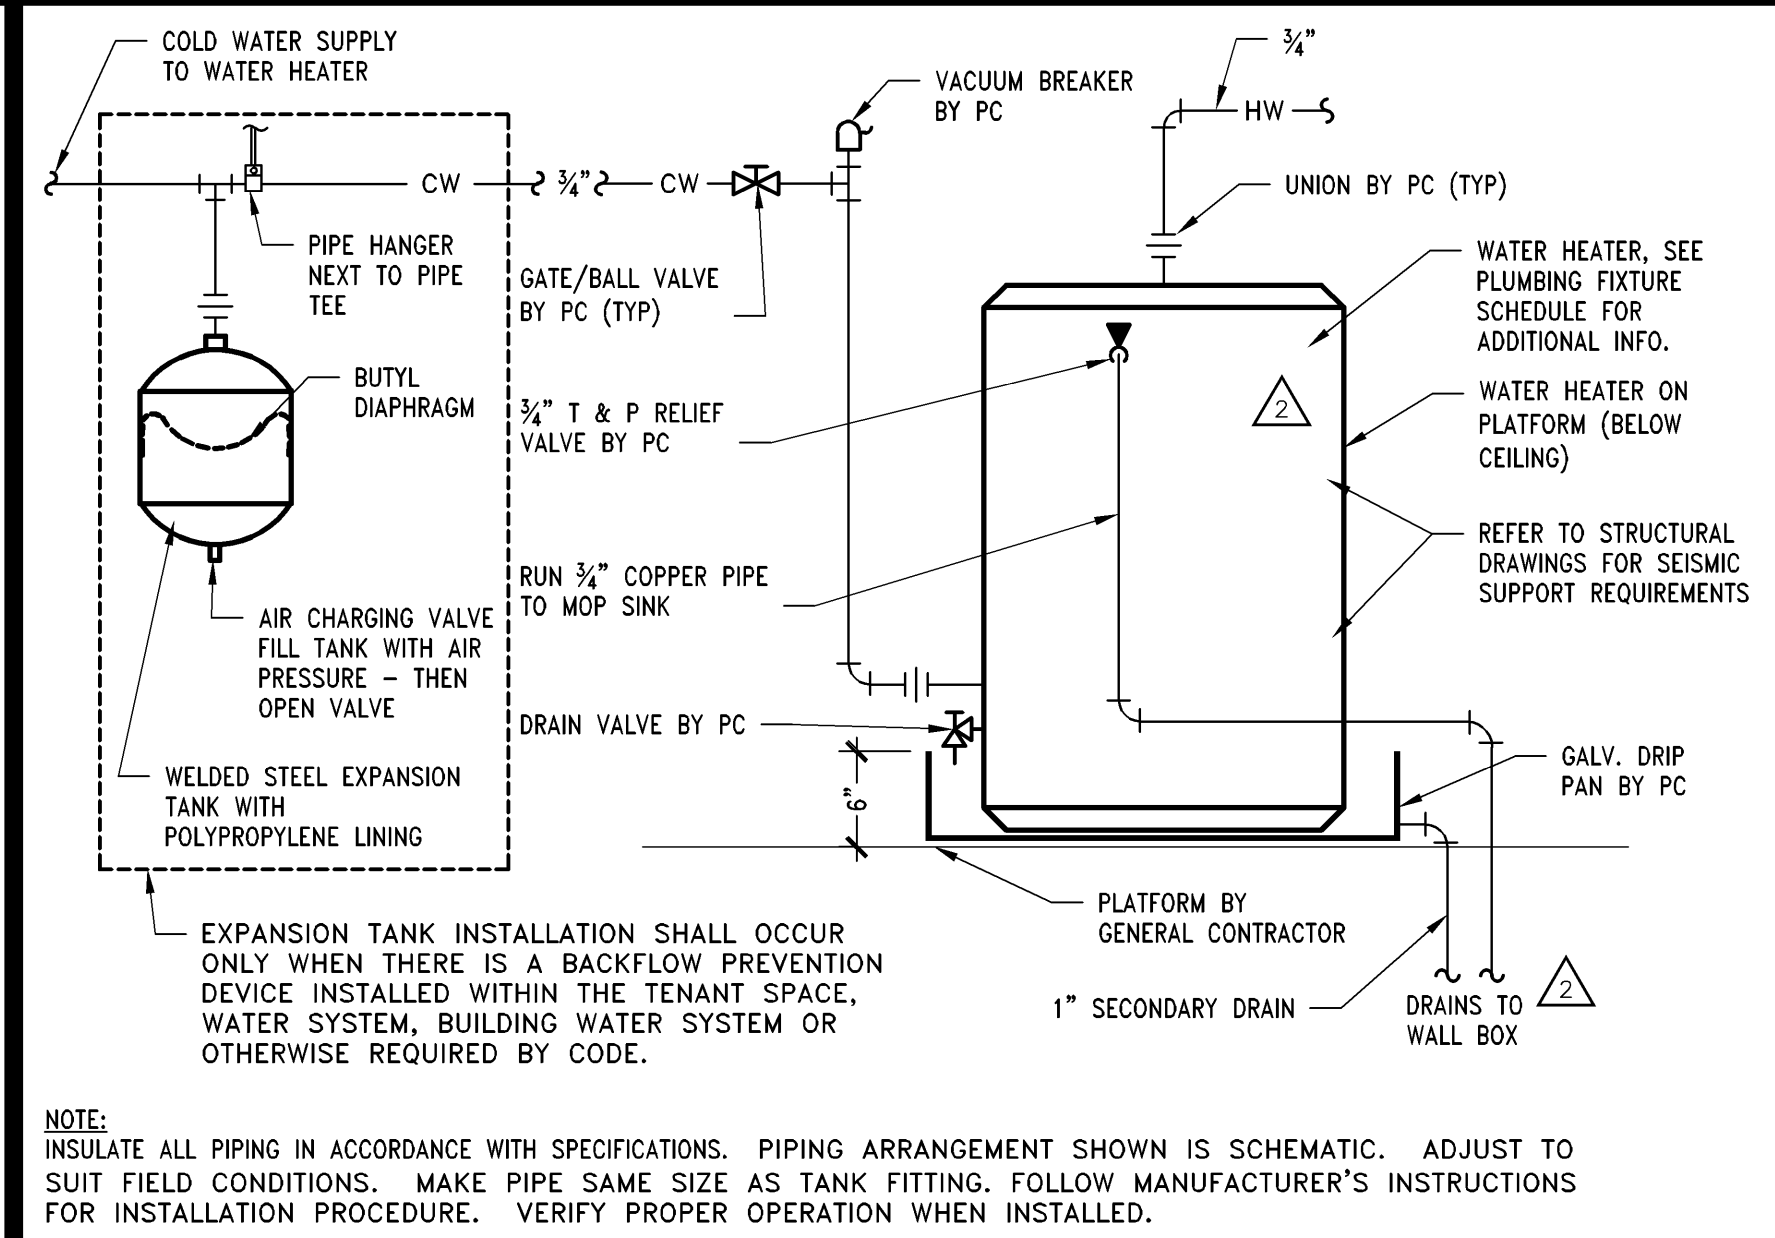


WATER HEATER DETAIL 1" = 1'-0" 00D-P0301-B00-WTHR 09/03/2016

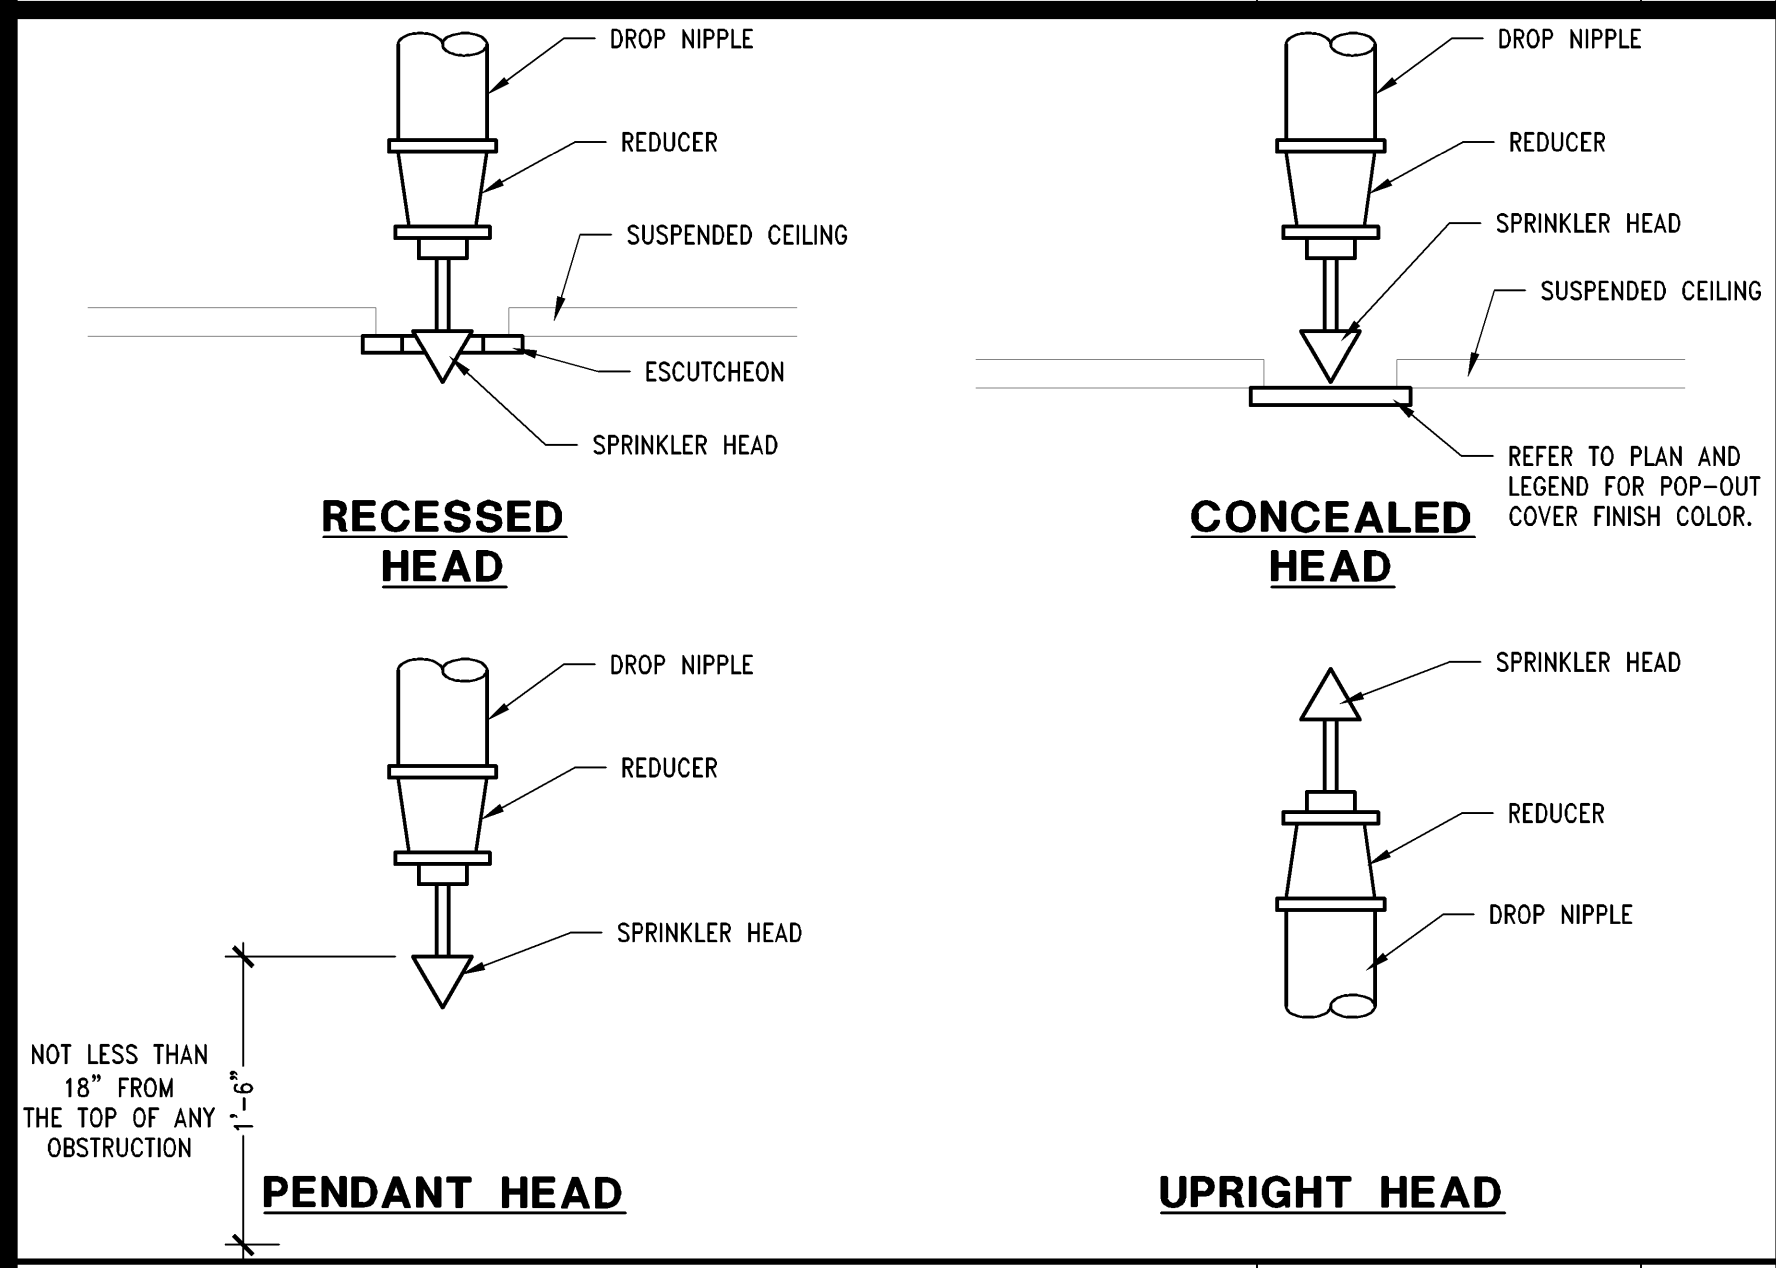


FIRE SPRINKLER HEAD DETAILS NTS 00D-P0301-N00-FSHD 02/14/2016

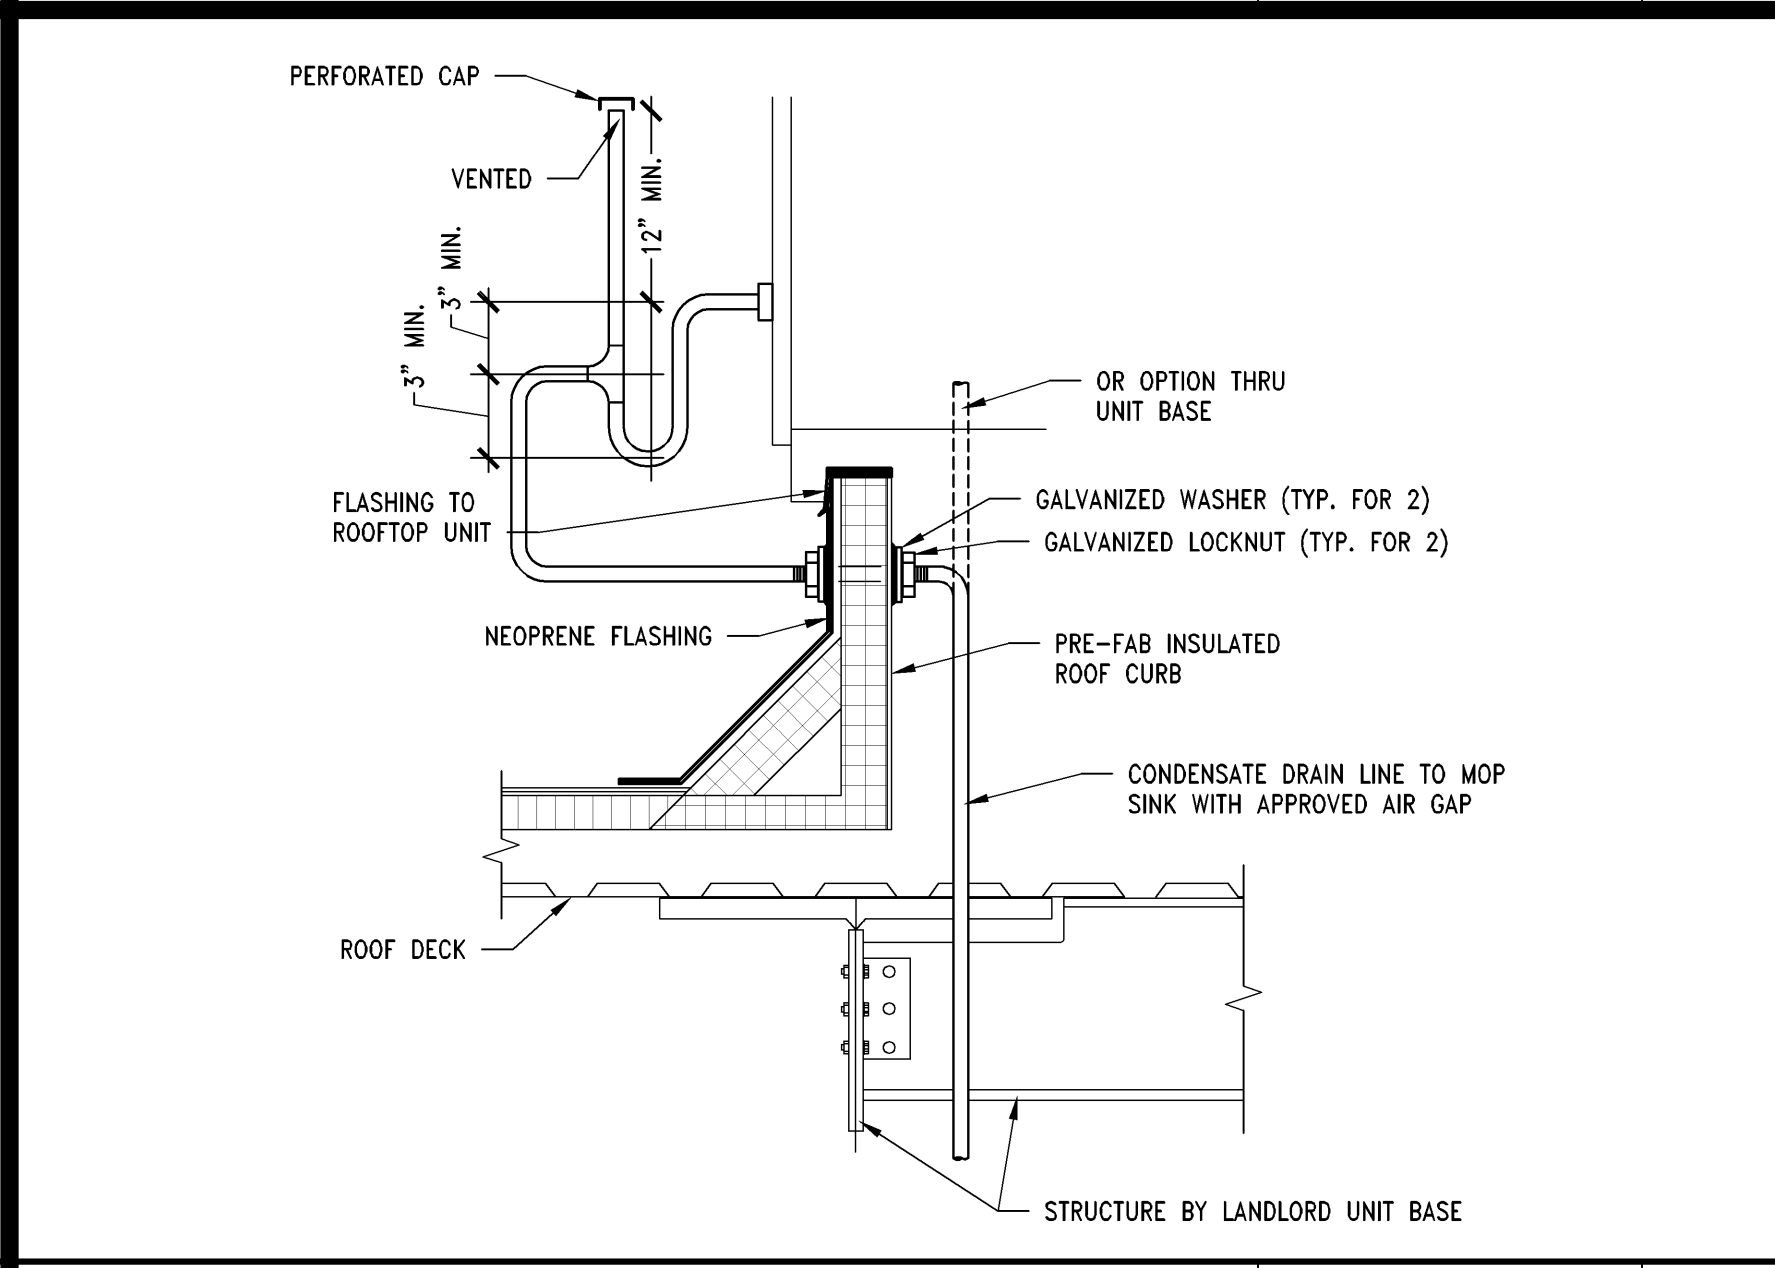

CONDENSATE DRAIN LINE 1" = 1'-0" 00D-P0301-F00-COND 09/03/2016

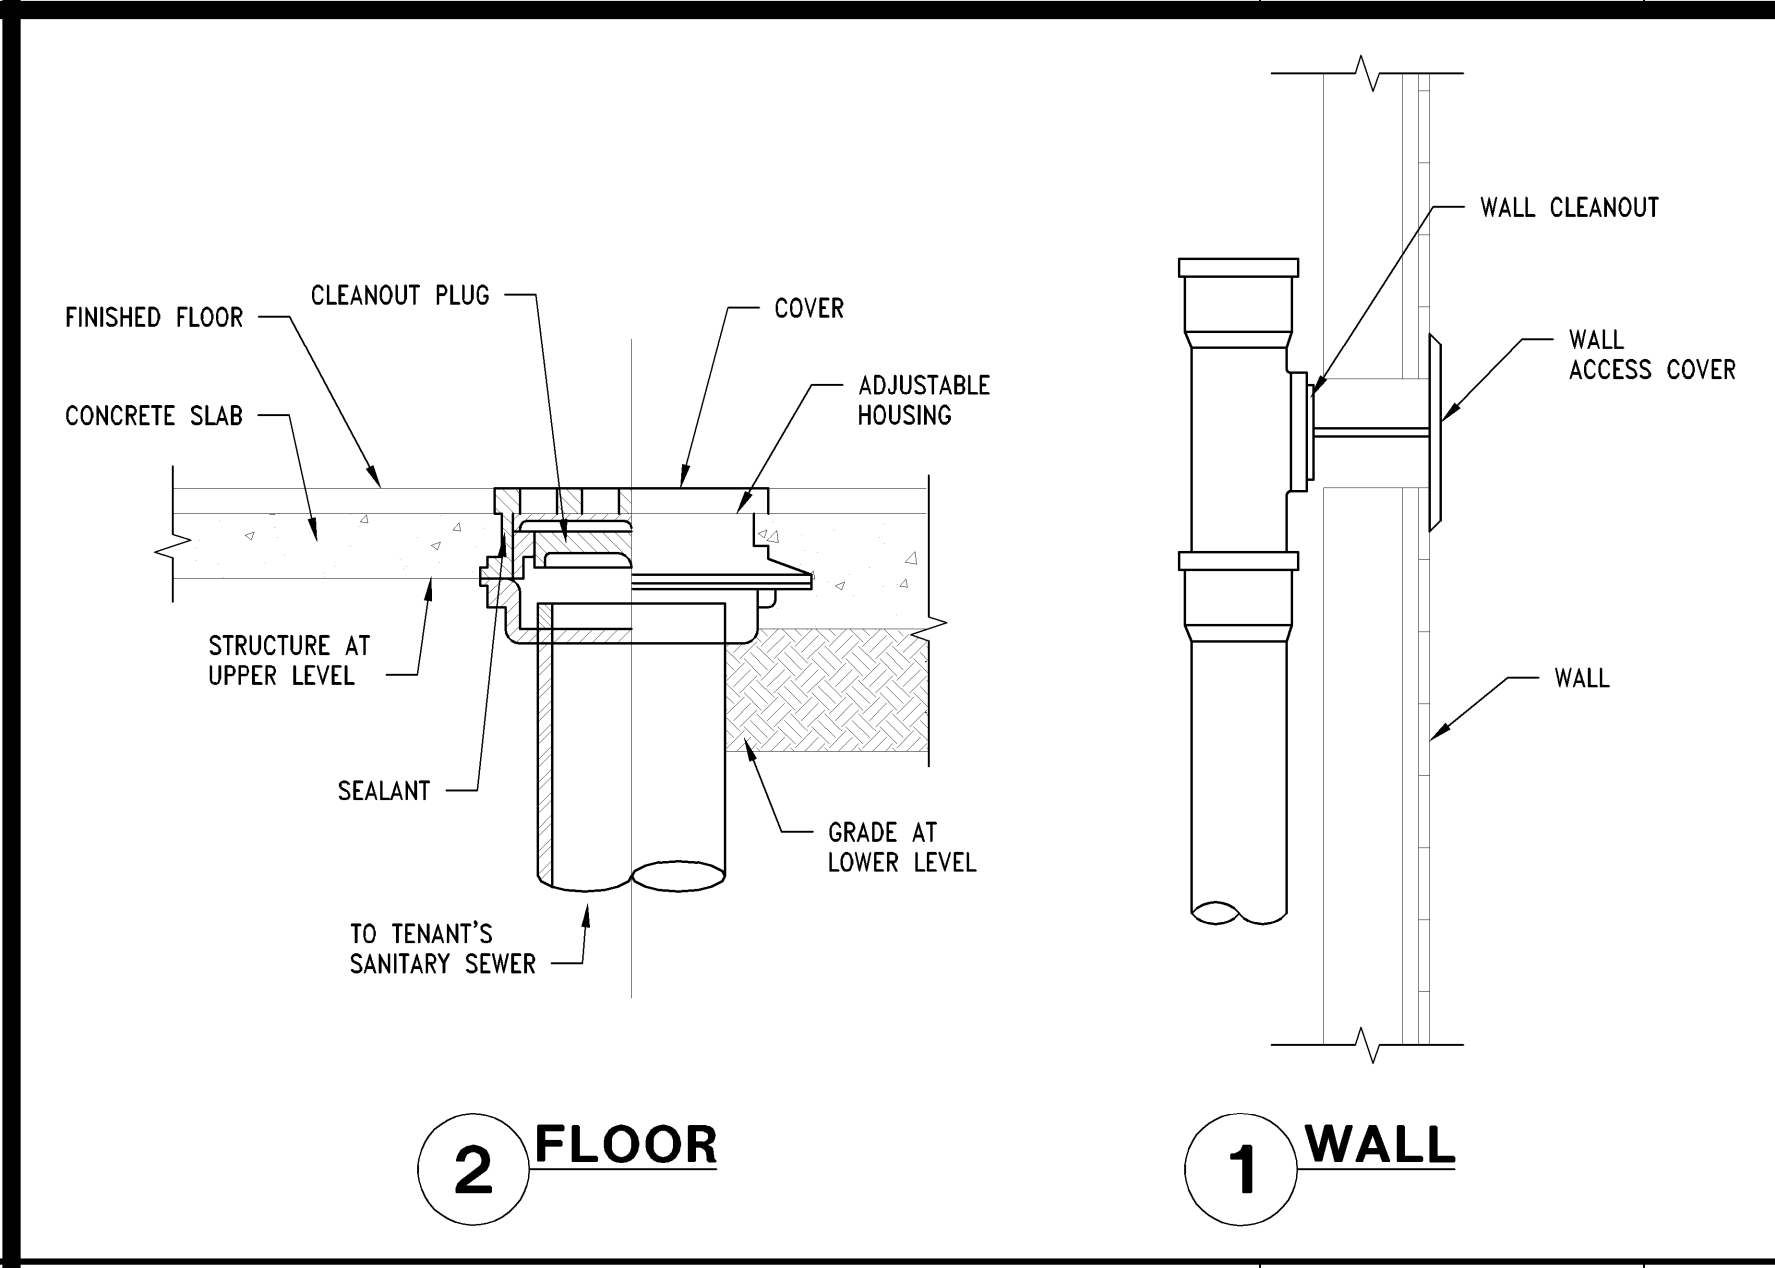

CLEANOUT DETAILS NTS 00D-P0301-E00-FWCO 09/03/2016

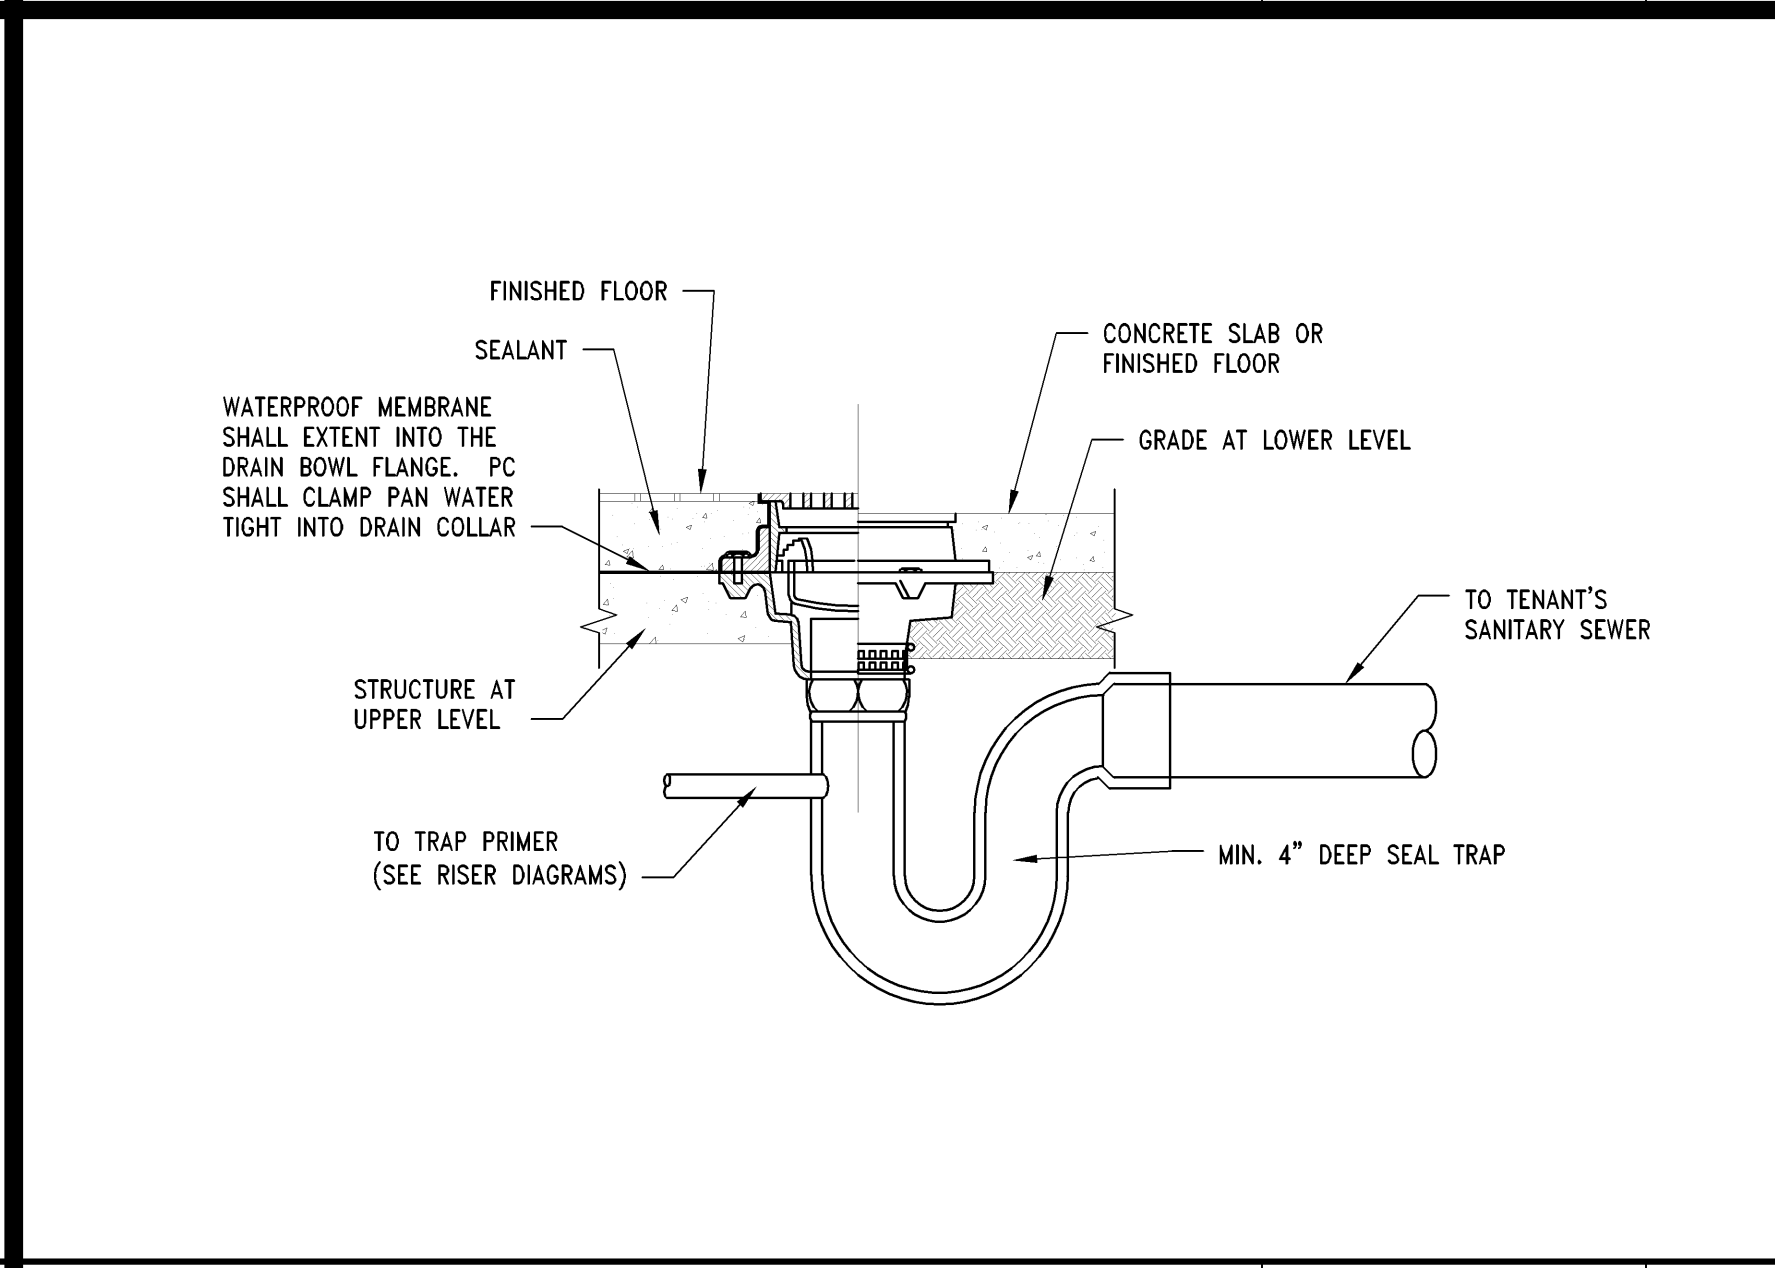

FLOOR DRAIN DETAIL NTS 00D-P0301-A00-FDRN 09/03/2016

LARSON BINKLEY
Larson Binkley, Inc.
310 W 20th Street, Suite 200
Kansas City, Missouri 64108
Telephone: 816-987-9801
Fax: 816-987-9802
Email: info@larsonbinkley.com
www.larsonbinkley.com

Limitedbrands
LIMITED STORE PLANNING, INC.
d/b/a STORE DESIGN & CONSTRUCTION
Three Limited Parkway • Columbus, Ohio 43230
Telephone: 614.415.7000 • Fax: 614.415.7349

0242003996
BATH & BODY WORKS
MEMORIAL CITY MALL
303 MEMORIAL CITY WAY
SUITE 735
HOUSTON, TX 77024
SCOPE: RELO DOWN / NEW PACKAGE: EASTON-C GENERATION: 60685 A/E PROJECT #: 14159 13643

REVISIONS:
REVISION 1 - PERMIT COMMENTS 6/10/2014
REVISION 2 - LL / PERMIT COMMENTS 6/23/2014
FIELD DIRECTIVE 1 07/02/2014
REVISION 3 - PERMIT COMMENTS 07/21/2014
ELITE CONSTRUCTION GROUP
LAKE JACKSON, TX
PHONE: 979-284-0712
NOTE: THESE PRINTS HAVE BEEN REDUCED BY 50 PERCENT SCALE. WILL BE 50 PERCENT OF WHAT IS NOTED ON PLANS.
DATE ISSUED: 04/11/2014
DESIGNED BY: JES
DRAWN BY: JES
CHECKED BY: NRP
PLUMBING AND FIRE PROTECTION DETAILS
DRAWING NUMBER: P03.01