

**Limited brands**  
LIMITED STORE PLANNING, INC.  
d/b/a STORE DESIGN & CONSTRUCTION  
Three Limited Parkway • Columbus, Ohio 43230  
Telephone: 614.415.7000 • Fax: 614.415.7349

PROJECT INFORMATION:

**BATH & BODY WORKS**  
**MEMORIAL CITY MALL**  
303 MEMORIAL CITY WAY  
SUITE 733  
HOUSTON, TX 77024

024200396

SCOPE: RELO DWN / NEW PACKAGE:  
DESIGN TYPE: EASTON, G  
PROJECT #: 14150

REVISIONS:		
	REQUIRED BY:	DATE
1	STOREFRONT REVISION - REV 1	6/10/20
2	REVISION 2 - LL / PERMIT COMMENTS	6/27/20

ELITE CONSTRUCTION GROUP  
LAKE JACKSON, TX  
PHONE: 979-285-0712  
NOTE: THESE PRINTS HAVE BEEN  
REDUCED BY 50 PERCENT. SCALE  
WILL BE 50 PERCENT OF WHAT IS  
NOTED ON PLANS

DATE ISSUED: 04/11/201  
DESIGNED BY: JO  
DRAWN BY: JO  
CHECKED BY: JM

## MECHANICAL DETAILS

DRAWING NUMBER:  
MO3.01



NTS



**1" = 1'-0"**

---

**D-M0301-D00-E**



3" = 1'-0"



**NTS**

---


**D-M0301-C00-E**



NTS



**NTS**

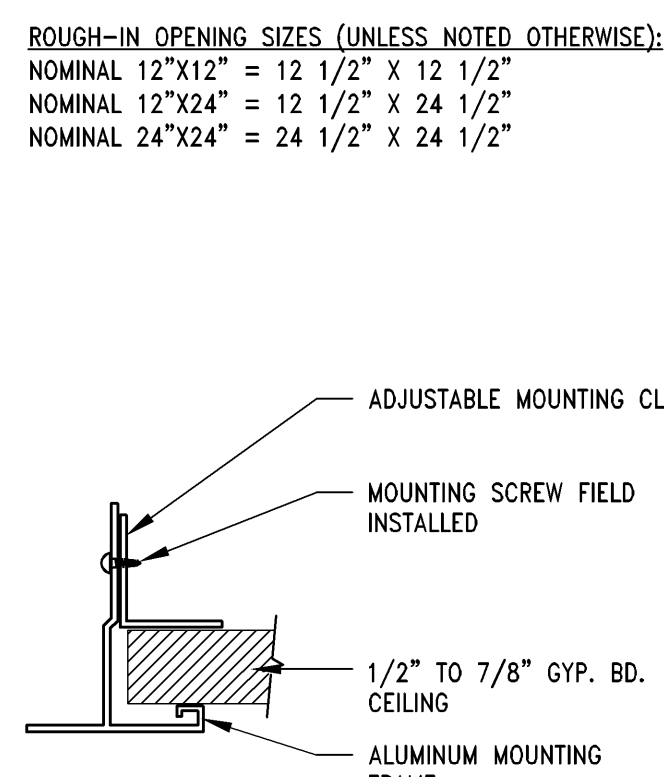

### DRYWALL CEILING DIFFUSER MOUNTING FRAME DETAIL

1" = 1'-0"



### CEILING DIFFUSER MOUNTING DETAIL

**NTS**